

In addition to the hazards/risks normally associated with the types of work detailed on this drawing, note the following:

CONSTRUCTION

MAINTENANCE/CLEANING


DECOMMISSIONING/DEMOLITION

It is assumed that all works will be carried out by a competent contractor working, where appropriate, to an approved method statement

NOTES




1. DO NOT SCALE FROM THIS DRAWING.
2. ALL MEASUREMENTS ARE IN MILLIMETRES UNLESS STATED OTHERWISE.
3. THIS DRAWING IS TO BE READ IN CONJUNCTION WITH THE SPECIFICATION AND ALL RELEVANT ARCHITECTURAL, ELECTRICAL, MECHANICAL AND STRUCTURAL DRAWINGS.

LEGEND

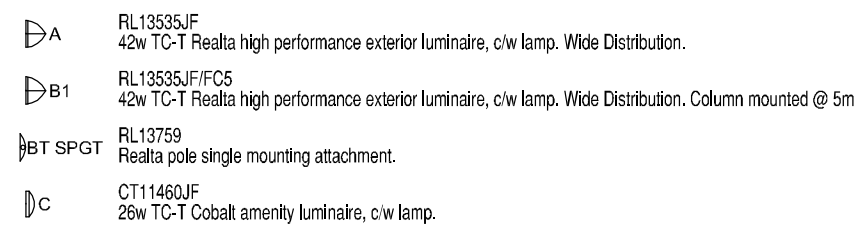


Isolines

- 1.0 lx
2.0 lx
5.0 lx
7.0 lx
10.0 lx
15.0 lx
20.0 lx
30.0 lx

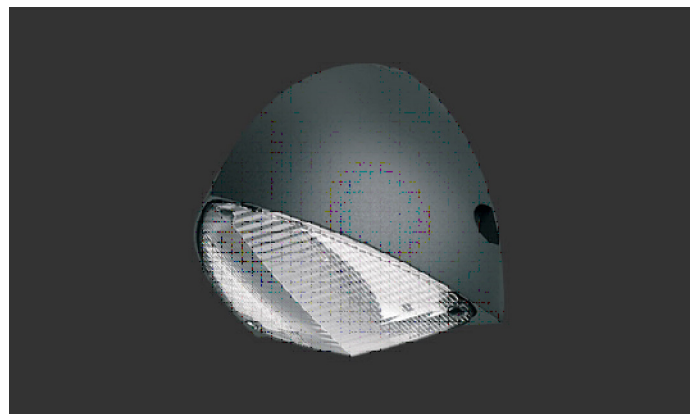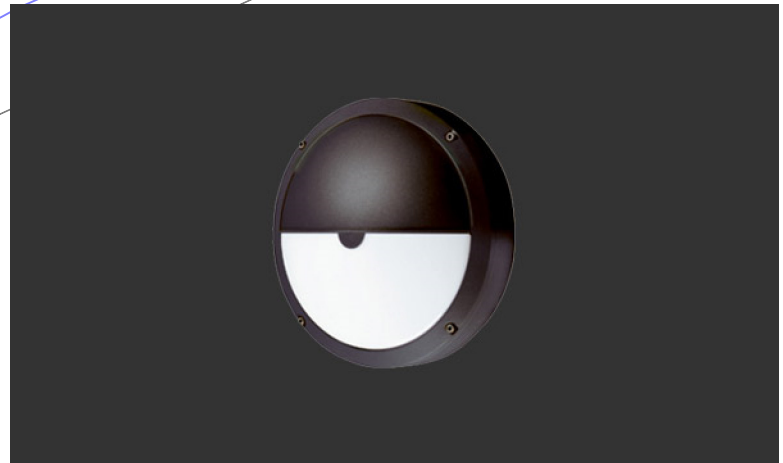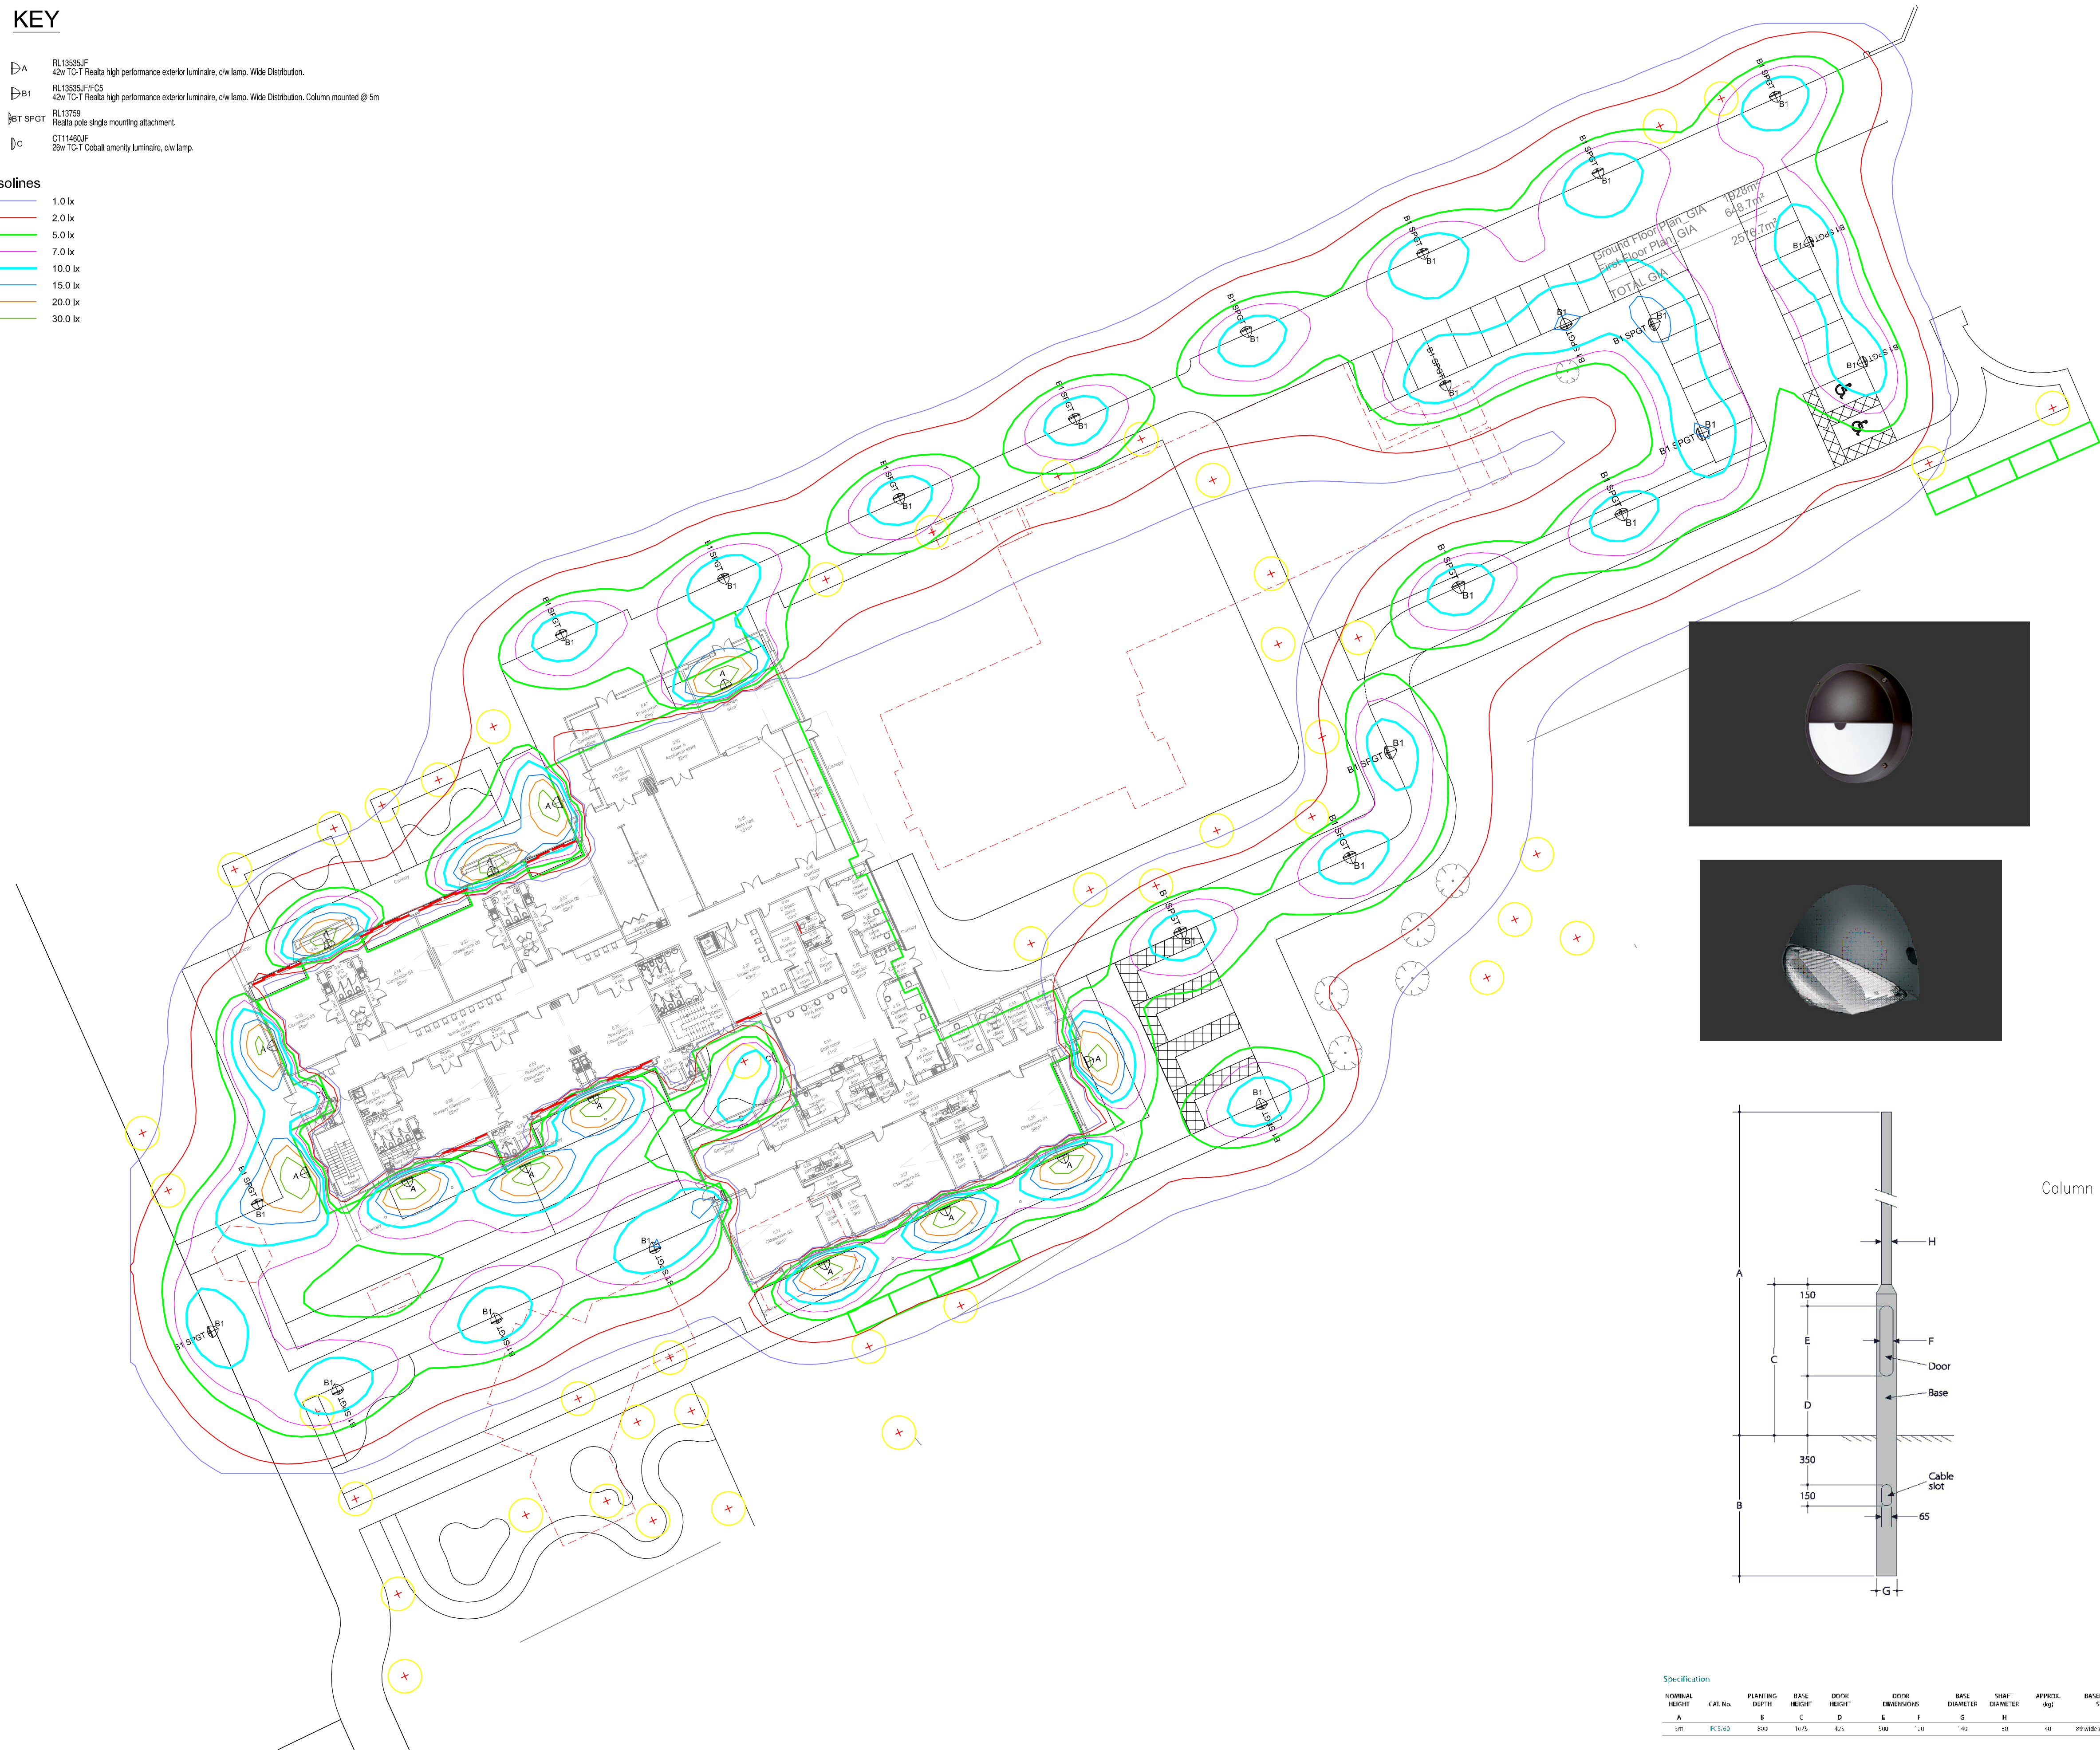

Column Detail

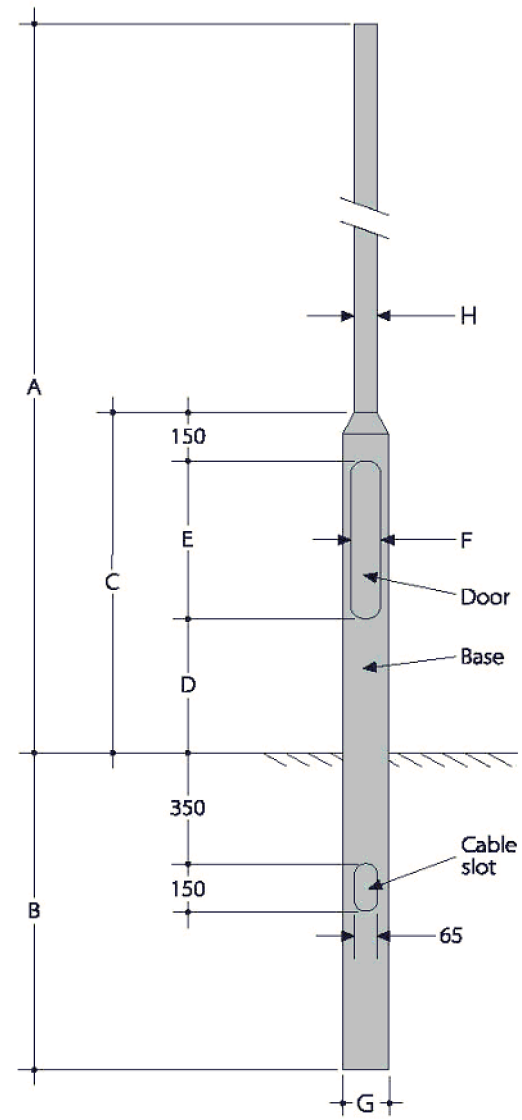

Specification

NOMINAL HEIGHT	CAT. No.	PLANTING DEPTH	BASE HEIGHT	DOOR HEIGHT	DOOR DIMENSIONS		BASE DIAMETER	SHAFT DIAMETER	APPROX. (kg)	BASEBOARD SIZE
A		B	C	D	E	F	G	H		
500	FC5-60	800	1605	425	500	1100	140	50	90	279 wide x 560 high

P1	26.11.14	PLANNING	NB	DJS	SW
Rev.	Date	Description	By	Chk'd	App'd

Drawing Status

D1


ATKINS

Woodcote Grove
Ashley Road
Epsom
Surrey
KT18 5BW

Tel: +44 (0)1372 726140
Fax: +44 (0)1372 740065
www.atkinsglobal.com

Copyright © Atkins Limited (2013)

Client

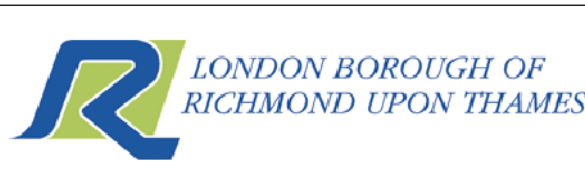

Project Title

THE RUSSELL AND
STRATHMORE SCHOOLS

Drawing Title

PROPOSED EXTERNAL LIGHTING LAYOUT

Scale 1:300	Designed PO	Drawn NB	Checked DJS	Authorised SW
Original Size A1	Date 26.11.14	Date 26.11.14	Date 26.11.14	Date 26.11.14

Drawing Number

5127940-ATK-Z1-SW-DR-E-0001

revision

P1