

Rev	Date	By	Amendment

- LEGEND**
- ABBREVIATIONS
- CPD CUPBOARD
 - CF CEILING FALL
 - IC INSPECTION COVER
 - GV GAS VALVE
 - TP TELEPHONE POLE
 - WV WATER VALVE
 - RS ROAD SIGN
 - RWP RAIN WATER PIPE
 - RE RODDING EYE
 - BT BRITISH TELECOM
 - LP LAMP POST
 - VP VENT PIPE
- C 800 HEIGHT FROM FLOOR TO CILL
 - SP 1000 HEIGHT FROM CILL TO SPRING OF ARCH
 - H 1250 HEIGHT FROM CILL TO HEAD
- (280) HEIGHT TO CEILING, BEAM OR DOOR
- S/C STRUCTURAL CEILING HEIGHT
 - F/C FALSE CEILING HEIGHT
- [Symbol] ELECTRIC CONTROL PANEL

LEVELS ARE RELATED TO
ORDNANCE SURVEY BENCH MARK

POSITION:
ON WALL OF SITE, WALDEGRAVE ROAD
OPPOSITE NUMBER 277
VALUE 11.72m

06/1368/LBC

TRIBAL
property services

A member of Tribal Group PLC


TRIBAL SURVEYS

LONDON
RIVERSIDE OFFICES, BLOCK A, LITTLEBROOK BUSINESS PARK,
DARTFORD, KENT DA1 5PZ
Tel: 01322 627800 E-mail: adcl@tribalps.co.uk
Fax: 01322 290155 Website: www.tribalps.co.uk

BRISTOL
1 PORTLAND SQUARE,
BRISTOL, BS2 8RR
Tel: 0117 311 6420 Fax: 0117 311 5422

LEEDS
SUITE 1, GRIMSTON GRANGE OFFICES,
SHERBURN ROAD, TADCASTER, LS24 9BX
Tel: 01937 833875 Fax: 01937 833812

Client	St. Mary's College- Internet Café		
Project	Waldergrave Road, Strawberry Hill, Twickenham TW1 4SX		
Drawing	EXISTING GROUND FLOOR PLAN		
Date	Scale	Drawn by	SEJ
APRIL 2004	1/100	Checked by	
Project No	Drawing No	Revision	
03767	L(0)02		

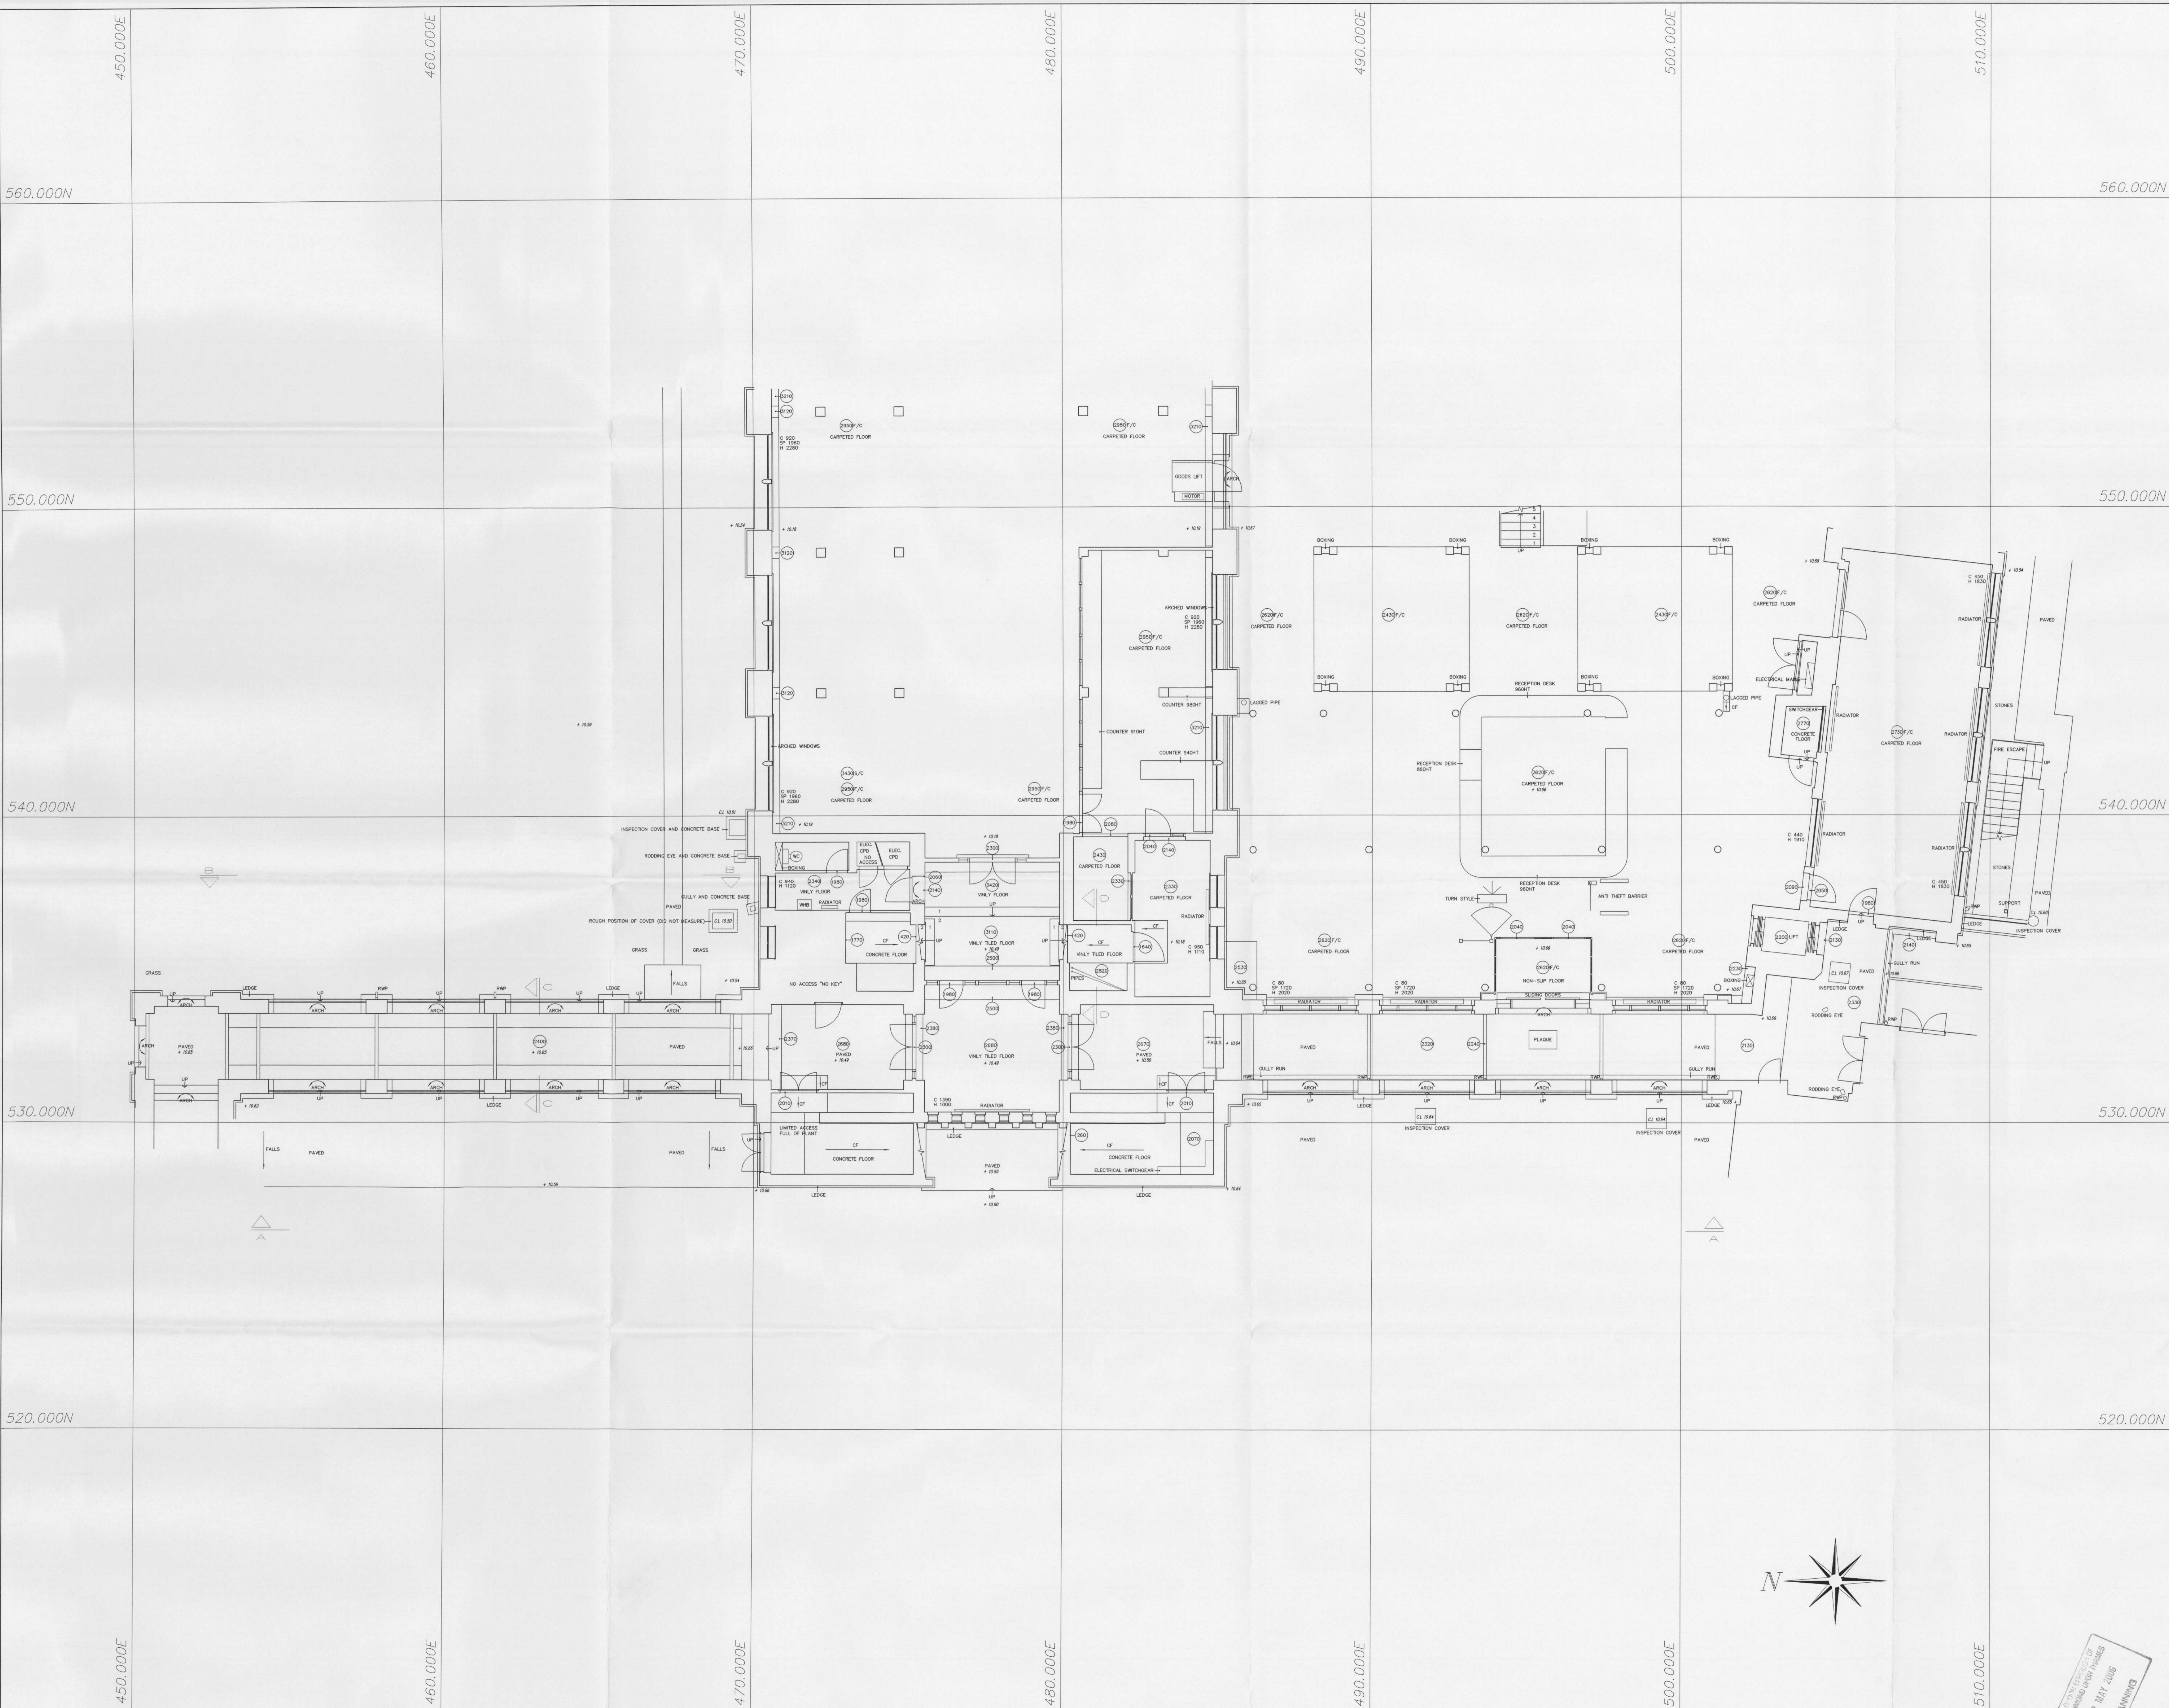

APPROVED FOR PLANNING
02 MAY 2004
PLANNING