


KITCHEN

SINK: 50 dia pipe and trap 75 depth of seal
STAND PIPE: for dishwasher 50 dia pipe and trap 75 depth of seal. Both to new stub stack as below.

WC/UTILITY

WC: 100 dia pipe and trap 50 depth of seal
WHS: 40 dia pipe 32 dia trap 75 depth of seal
SINKS: 50 dia pipe 40 dia trap 75 depth of seal
all to new 100 dia stub stack + AIR valve SEE DRG N° 0305B02

PART P electrical work required to meet PART P to comply with building regulations see DRG N° 0305B10 General Specification

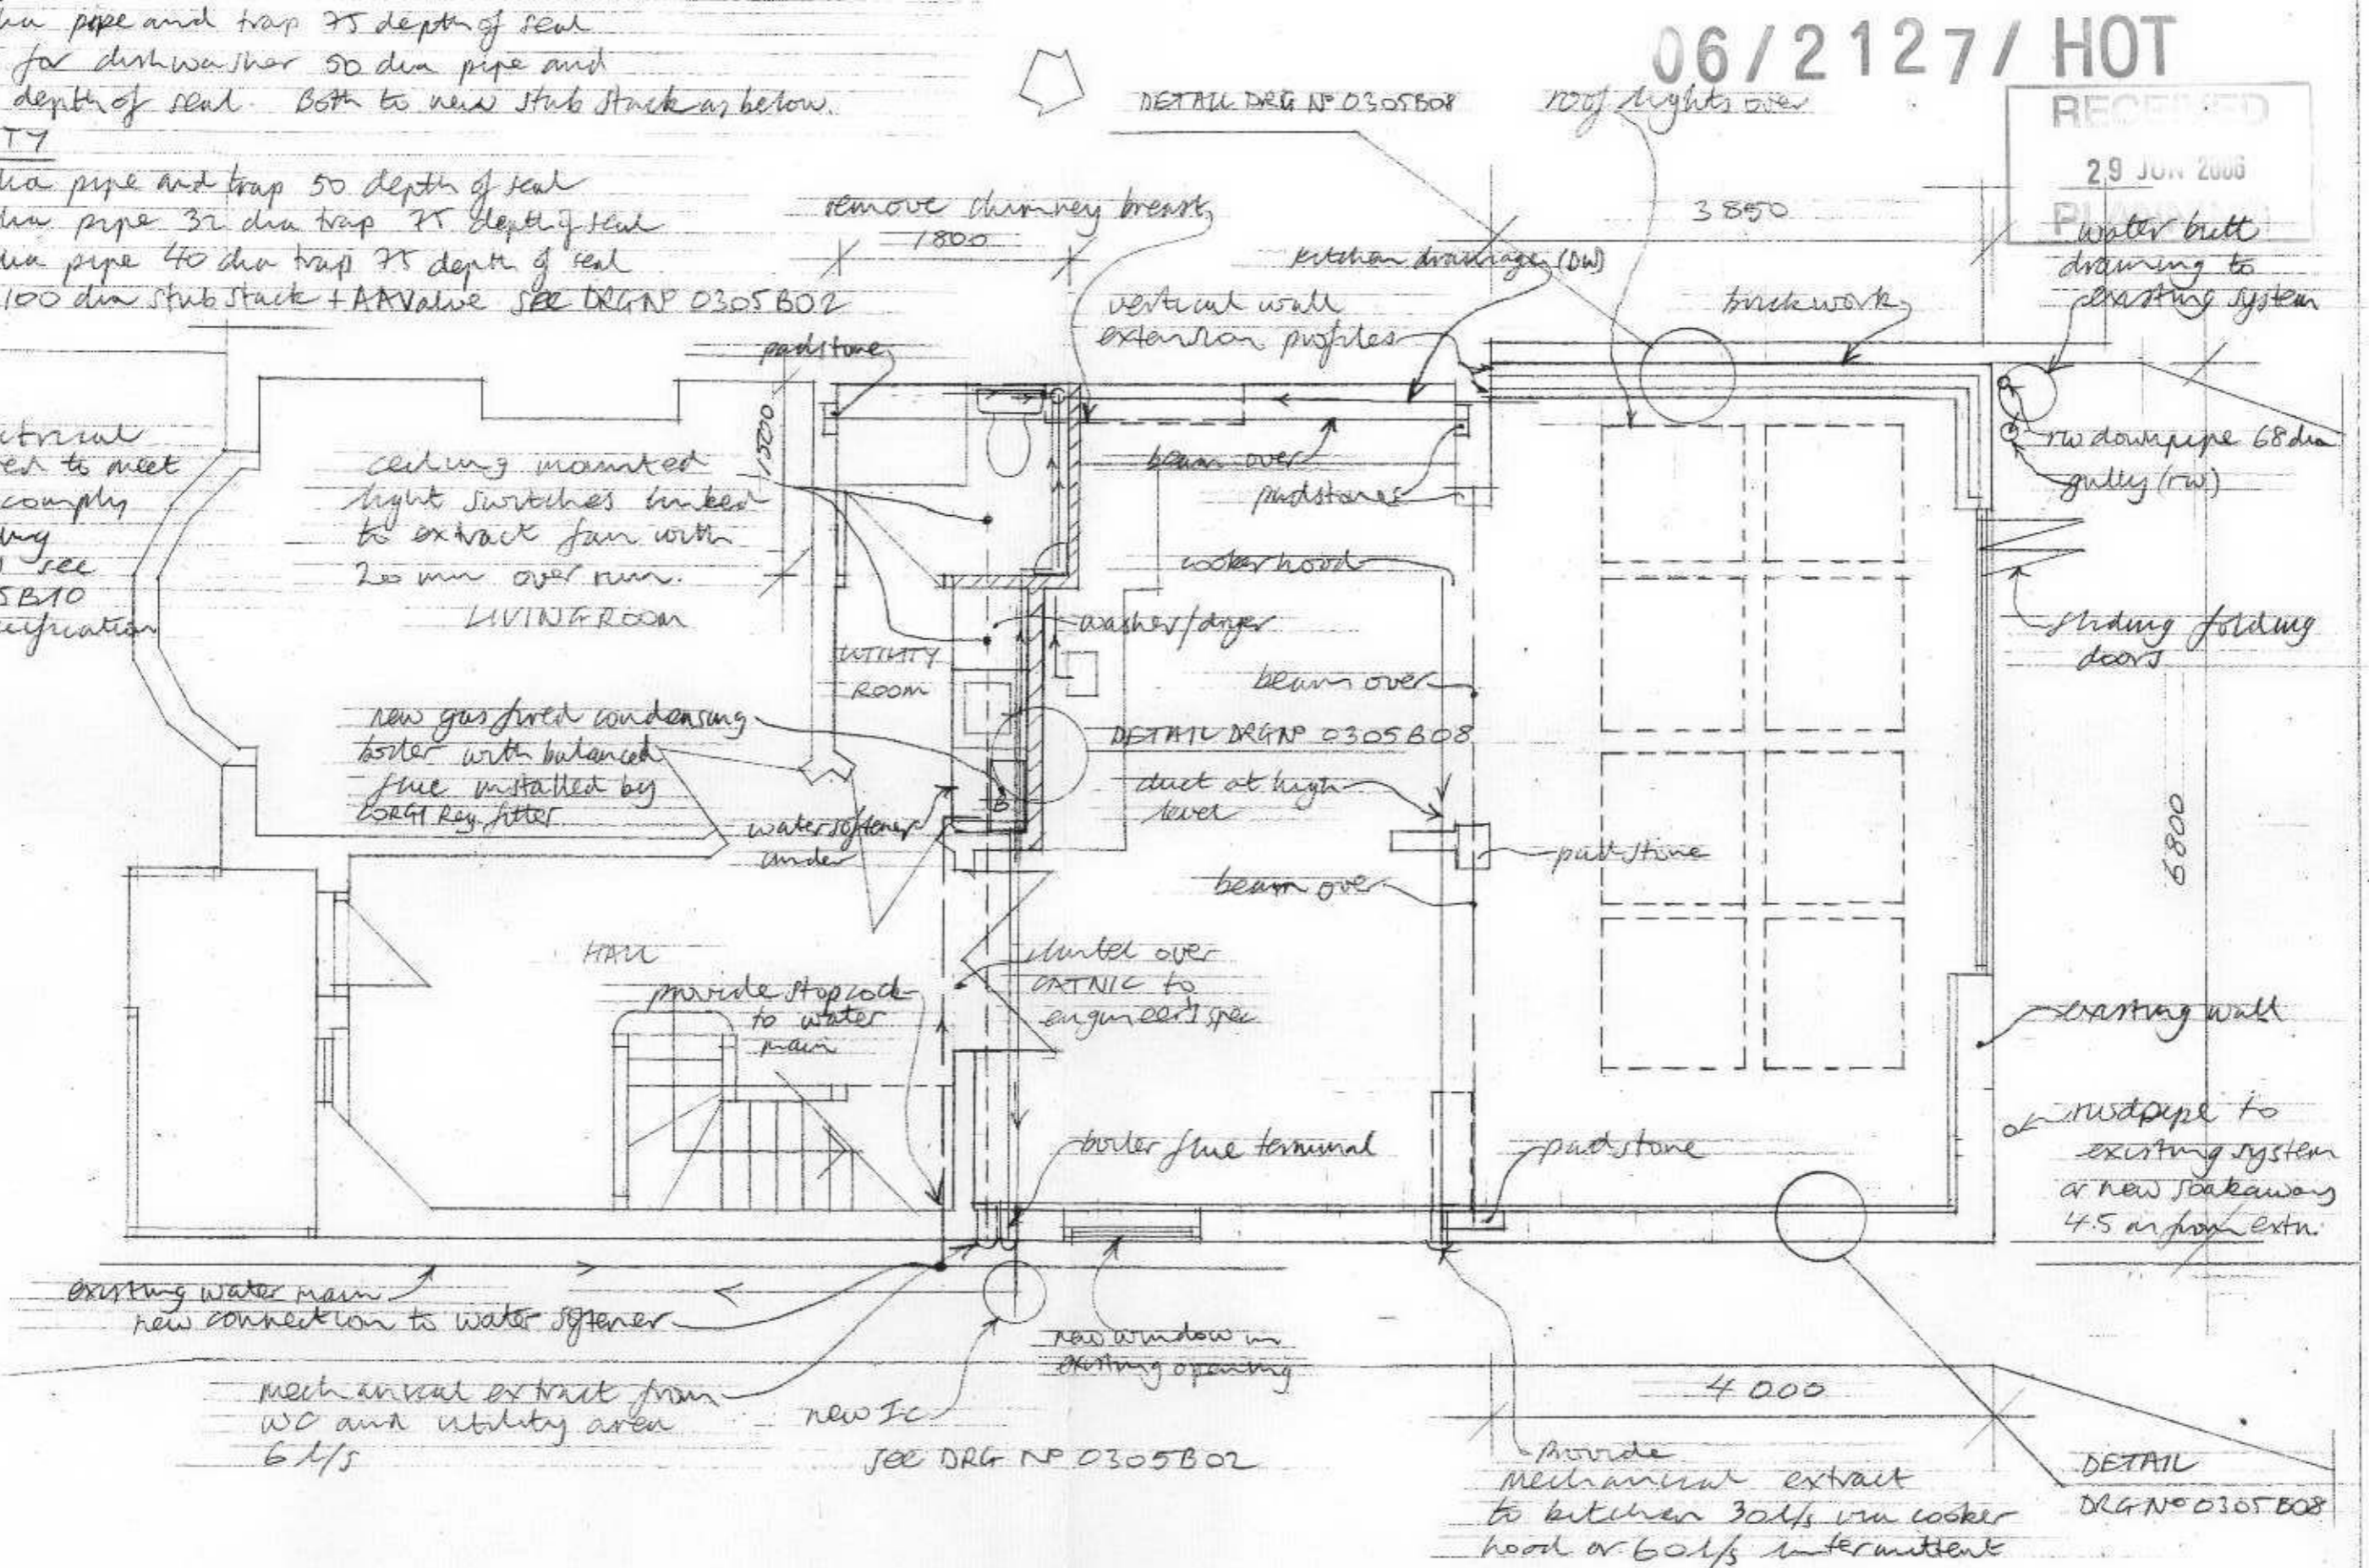

235 RICHMOND ROAD TWICKENHAM

PROPOSED GROUND FLOOR PLAN

SCALE: 1:50
DRAWING N° 0305B04C SEPT 2005