


NOTES:  
 DO NOT SCALE FROM THIS DRAWING.  
 ALL DIMENSIONS TO BE CHECKED ON SITE.  
 ALL OMISSIONS AND DISCREPANCIES TO BE REPORTED TO THE ARCHITECT IMMEDIATELY.

ALL RIGHTS RESERVED. THIS WORK IS COPYRIGHT AND CANNOT BE REPRODUCED OR COPIED OR MODIFIED IN ANY FORM OR BY ANY MEANS, GRAPHIC ELECTRONIC OR MECHANICAL, INCLUDING PHOTOCOPYING WITHOUT THE WRITTEN PERMISSION OF SQUIRE AND PARTNERS ARCHITECTS.

--- Site Boundary

Site Area: 14350 m2

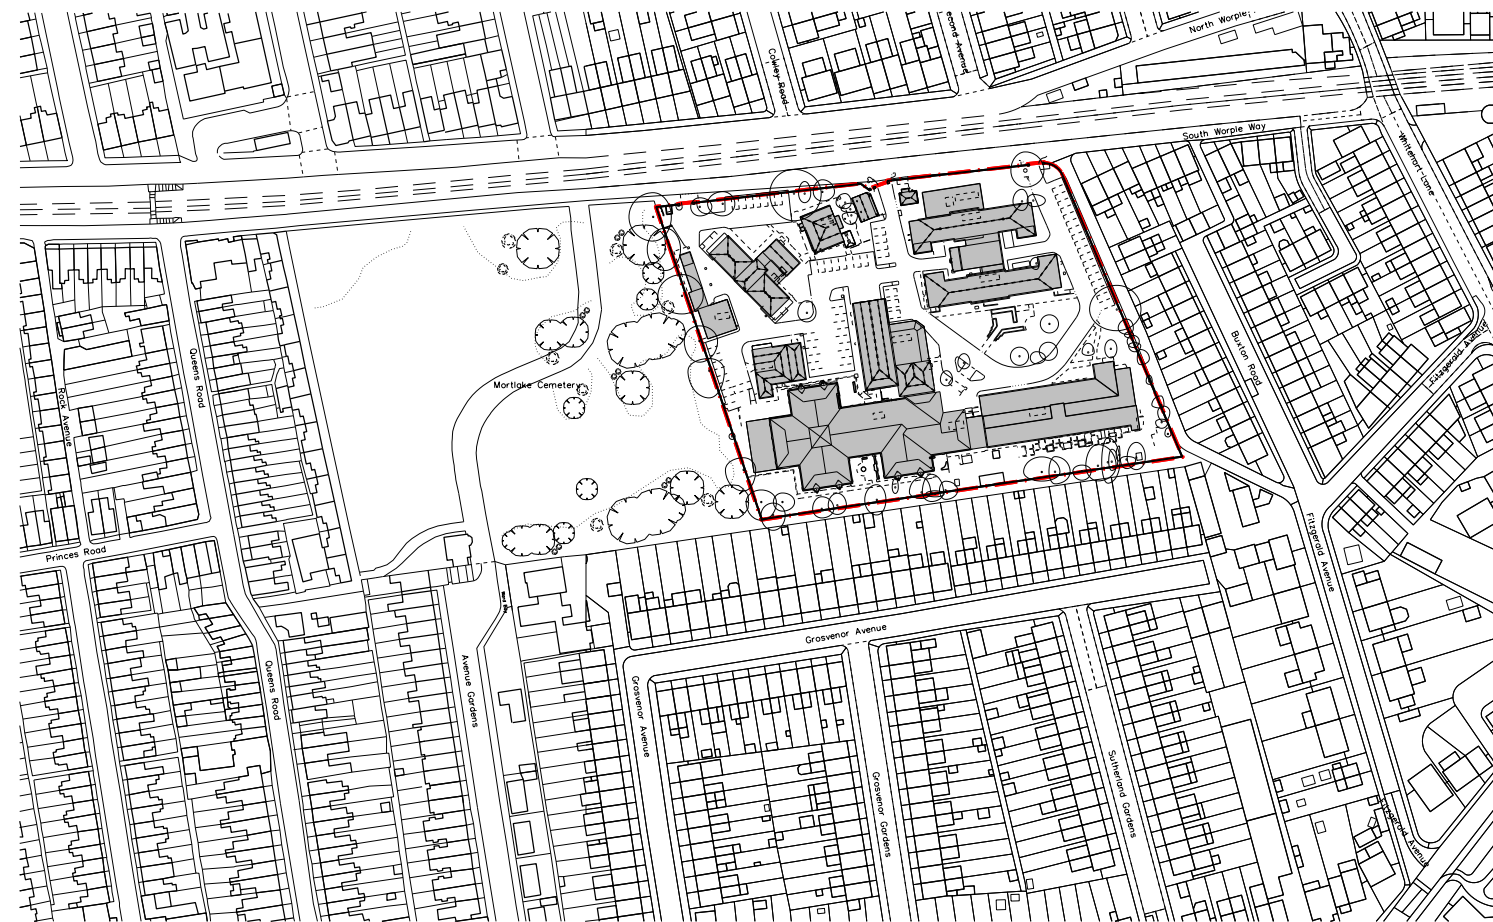

Revision description	Date	Check	Rev
----------------------	------	-------	-----

## SQUIRE & PARTNERS

The Department Store  
 248 Ferndale Road, London SW9 8FR  
 T: 020 7278 5555  
 info@squireandpartners.com  
 www.squireandpartners.com

Project  
**Barnes Hospital**  
 South Worple Way  
 Barnes, SW14 8SU

Drawing  
**Site Location Plan**

Drawn	Date	Scale
SSI	31/10/2018	1:1250@A1 1:2500@A3
Job number	Drawing number	Revision
18002	P_00_C645_001	-