

NOTES:  
 DO NOT SCALE FROM THIS DRAWING.  
 ALL DIMENSIONS TO BE CHECKED ON SITE.  
 ALL OMISSIONS AND DISCREPANCIES TO BE REPORTED TO THE ARCHITECT IMMEDIATELY.

ALL RIGHTS RESERVED. THIS WORK IS COPYRIGHT AND CANNOT BE REPRODUCED OR COPIED OR MODIFIED IN ANY FORM OR BY ANY MEANS, GRAPHIC ELECTRONIC OR MECHANICAL, INCLUDING PHOTOCOPYING WITHOUT THE WRITTEN PERMISSION OF SQUIRE AND PARTNERS ARCHITECTS.




Pembroke Lodge, Sheen Lodge & ESM Unit  
Noth Elevation



Administration Building  
Noth Elevation



Pembroke Lodge, Sheen Lodge & ESM Unit  
Noth Elevation

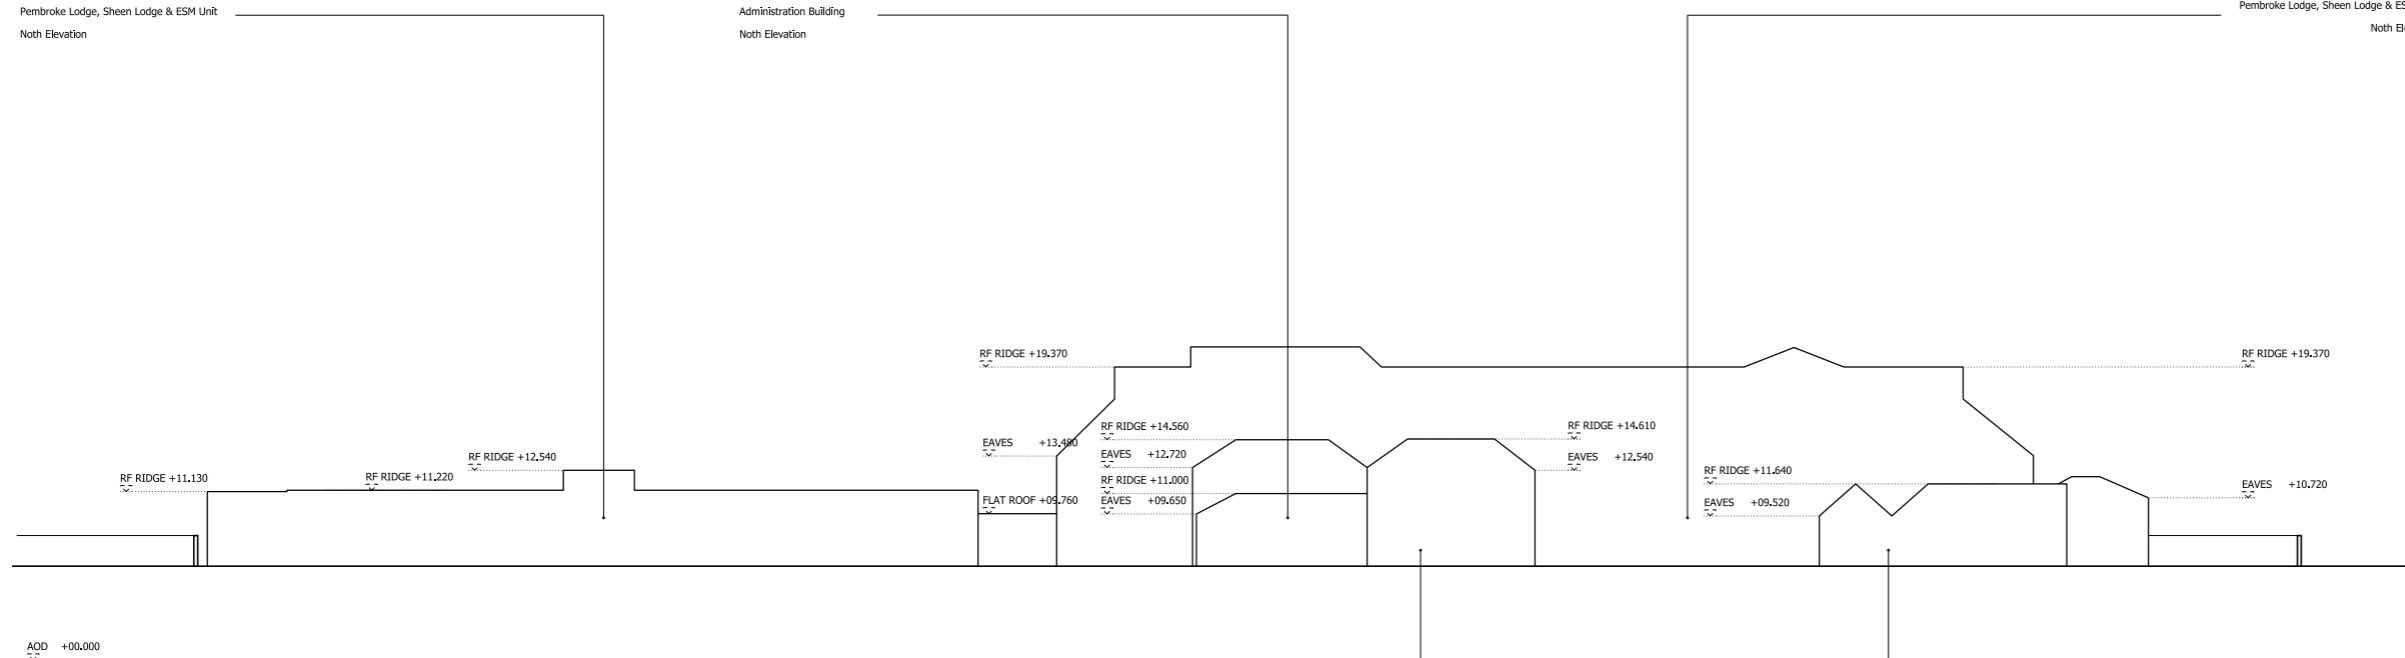

Administration Building  
Noth West Elevation



Fleming Lodge  
Noth Elevation



Revision description	Date	Check	Rev

## SQUIRE & PARTNERS

The Department Store  
 248 Ferndale Road, London SW9 8FR  
 T: 020 7278 5555

info@squireandpartners.com  
 www.squireandpartners.com

Project  
**Barnes Hospital**  
 South Worple Way  
 Barnes, SW14 8SU

Drawing  
**Existing**  
 Site Section

Drawn	Date	Scale
SSI	30/11/2018	1: 250@A1 1: 500@A3
Job number	Drawing number	Revision
18002	JA12_E_N_002	-