




REFERENCE K LUMINAIRE
 - EXTERNAL LED BULKHEAD LUMINAIRE INCORPORATING PHOTOCELL CONTROL AND EMERGENCY LIGHTING



REFERENCE L LUMINAIRE
 - EXTERNAL FLOOR MOUNTED LED SEALED UPLIGHT

- NOTES:**
1. THIS DRAWING IS THE PROPERTY OF HITEK CONSULTANTS LIMITED AND IS PROTECTED UNDER THE COPYRIGHTS DESIGNS AND PATENTS ACT 1988. ALL RIGHTS RESERVED. THIS DRAWING IS ISSUED ON CONDITION THAT IT IS NOT COPIED, REPRINTED OR REPRODUCED, WHOLLY OR IN PART, WITHOUT THE CONSENT OF HITEK CONSULTANTS LIMITED.
 2. DO NOT SCALE FROM THIS DRAWING. ALL DIMENSIONS AND SETTING OUT TO BE TAKEN FROM ARCHITECTURAL DRAWINGS.
 3. THIS DRAWING SHALL BE READ IN CONJUNCTION WITH THE ARCHITECTS, STRUCTURAL ENGINEERS AND ALL OTHER SERVICES DRAWINGS.
 4. THE INFORMATION CONTAINED ON THIS DRAWING HAS BEEN PRODUCED FROM A NON DESTRUCTIVE VISUAL SURVEY.

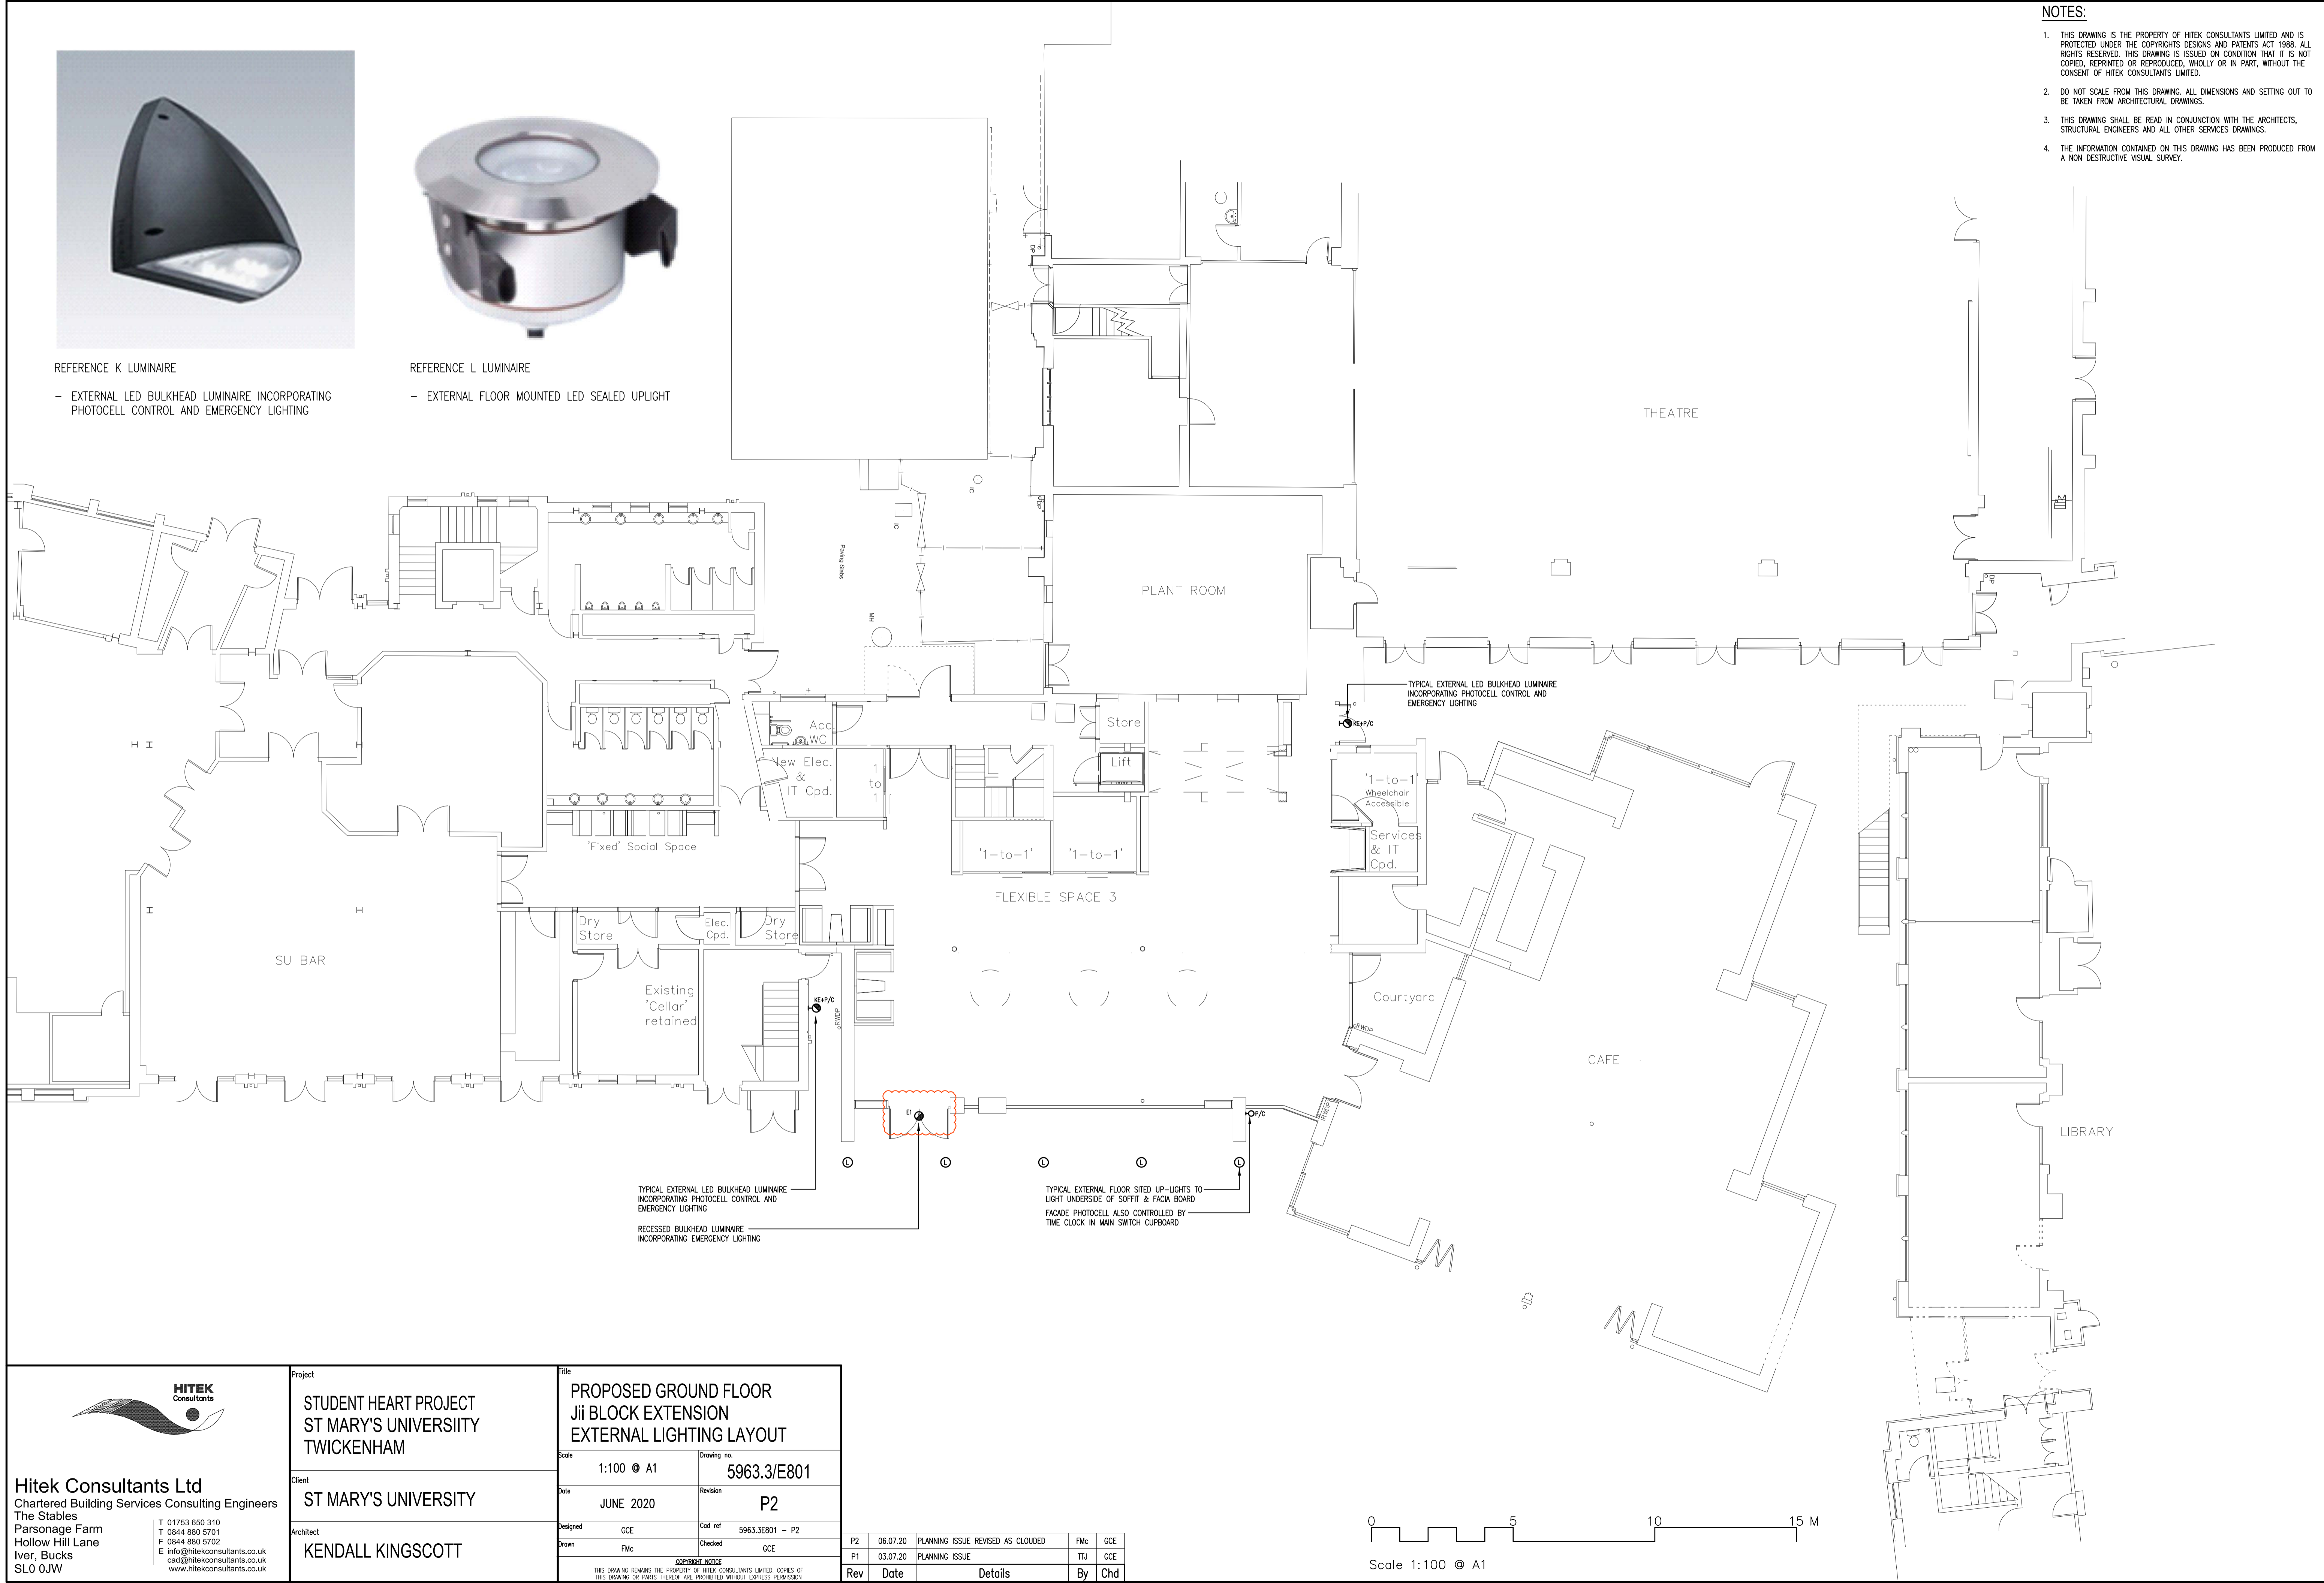

Hitek Consultants Ltd
 Chartered Building Services Consulting Engineers
 The Stables
 Parsonage Farm
 Hollow Hill Lane
 Iver, Bucks
 SL0 0JW

T 01753 650 310
 T 0844 880 5701
 F 0844 880 5702
 E info@hitekconsultants.co.uk
 cad@hitekconsultants.co.uk
 www.hitekconsultants.co.uk

Project	STUDENT HEART PROJECT ST MARY'S UNIVERSITY TWICKENHAM
Client	ST MARY'S UNIVERSITY
Architect	KENDALL KINGSCOTT

Title	PROPOSED GROUND FLOOR Jii BLOCK EXTENSION EXTERNAL LIGHTING LAYOUT
Scale	1:100 @ A1
Drawing no.	5963.3/E801
Date	JUNE 2020
Revision	P2
Designed	GCE
Drawn	FMc
Cad ref	5963.3E801 - P2
Checked	GCE

Rev	Date	Details	By	Chd
P2	06.07.20	PLANNING ISSUE REVISED AS CLOUDED	FMc	GCE
P1	03.07.20	PLANNING ISSUE	TTU	GCE

COPYRIGHT NOTICE
 THIS DRAWING REMAINS THE PROPERTY OF HITEK CONSULTANTS LIMITED. COPIES OF THIS DRAWING OR PARTS THEREOF ARE PROHIBITED WITHOUT EXPRESS PERMISSION

