


LEGEND

- EXISTING PRIVATE SURFACE WATER SEWER
- - -●- - - EXISTING PRIVATE FOUL SEWER
- EXISTING PRIVATE COMBINED SEWER
- EXISTING PUBLIC SURFACE WATER SEWER
- - -●- - - EXISTING PUBLIC FOUL SEWER
- EXISTING PUBLIC COMBINED SEWER
- - - - - EXISTING PUBLIC RISING MAIN

NOTES
 1) EXISTING DRAINAGE LAYOUT BASED ON THAMES WATER SEWER RECORDS AND PENBORN TECHNICAL SERVICES DRAWING (REF: P979/07/31).

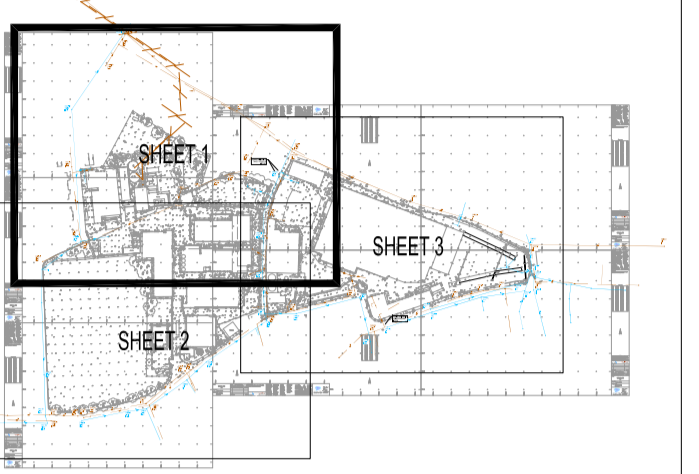

Client	GERALD EVE LLP	Date	JULY 2016	Drawn	ADG	Checked	ADG	Scale	AS SHOWN
Project Title	STAG BREWERY, MORTLAKE	Project No.	915213	Project Date	20160715	Project Status	PRELIMINARY	Project Location	STAG BREWERY, MORTLAKE

Rev	Date	Description	By
A01	20.10.16	PRELIMINARY ISSUE	DO

Project
 Amendments
STAG BREWERY

Title
 EXISTING FOUL AND SURFACE WATER DRAINAGE LAYOUT
 SHEET 1 OF 3


Client
 DARTMOUTH CAPITAL ADVISORS LIMITED



Drawing Status
PRELIMINARY

Designed by	Checked by	DO	Project No.	WIE10667
Drawn by	DO	Date	OCTOBER 2016	Computer File No.
Scales @ A1	1:500	Work to figure dimensions only	1:500	WIE10667CSA20001.dwg

Publisher	Zone	Category	Number	Revision
WIE	SA	92	0001	A01

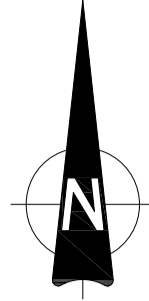

Revision	Date	Drawn	Checked	CPM
1	JULY 2015	LJC		



Revision	Date	Drawn	Checked	CPM
1	JULY 2015	LJC		

Client: GERALD EVE LLP

Project Title: STAG BREWERY, MORTLAKE

Scale: A09 1:200

Drawn: LJC

Checked: CPU

CPM: CPU

Date: JULY 2015

Drawn: LJC

Checked: CPU

CPM: CPU

Date: JULY 2015

Drawn: LJC

Checked: CPU


CPM: CPU

Date: JULY 2015

Drawn: LJC

Checked: CPU


CPM: CPU

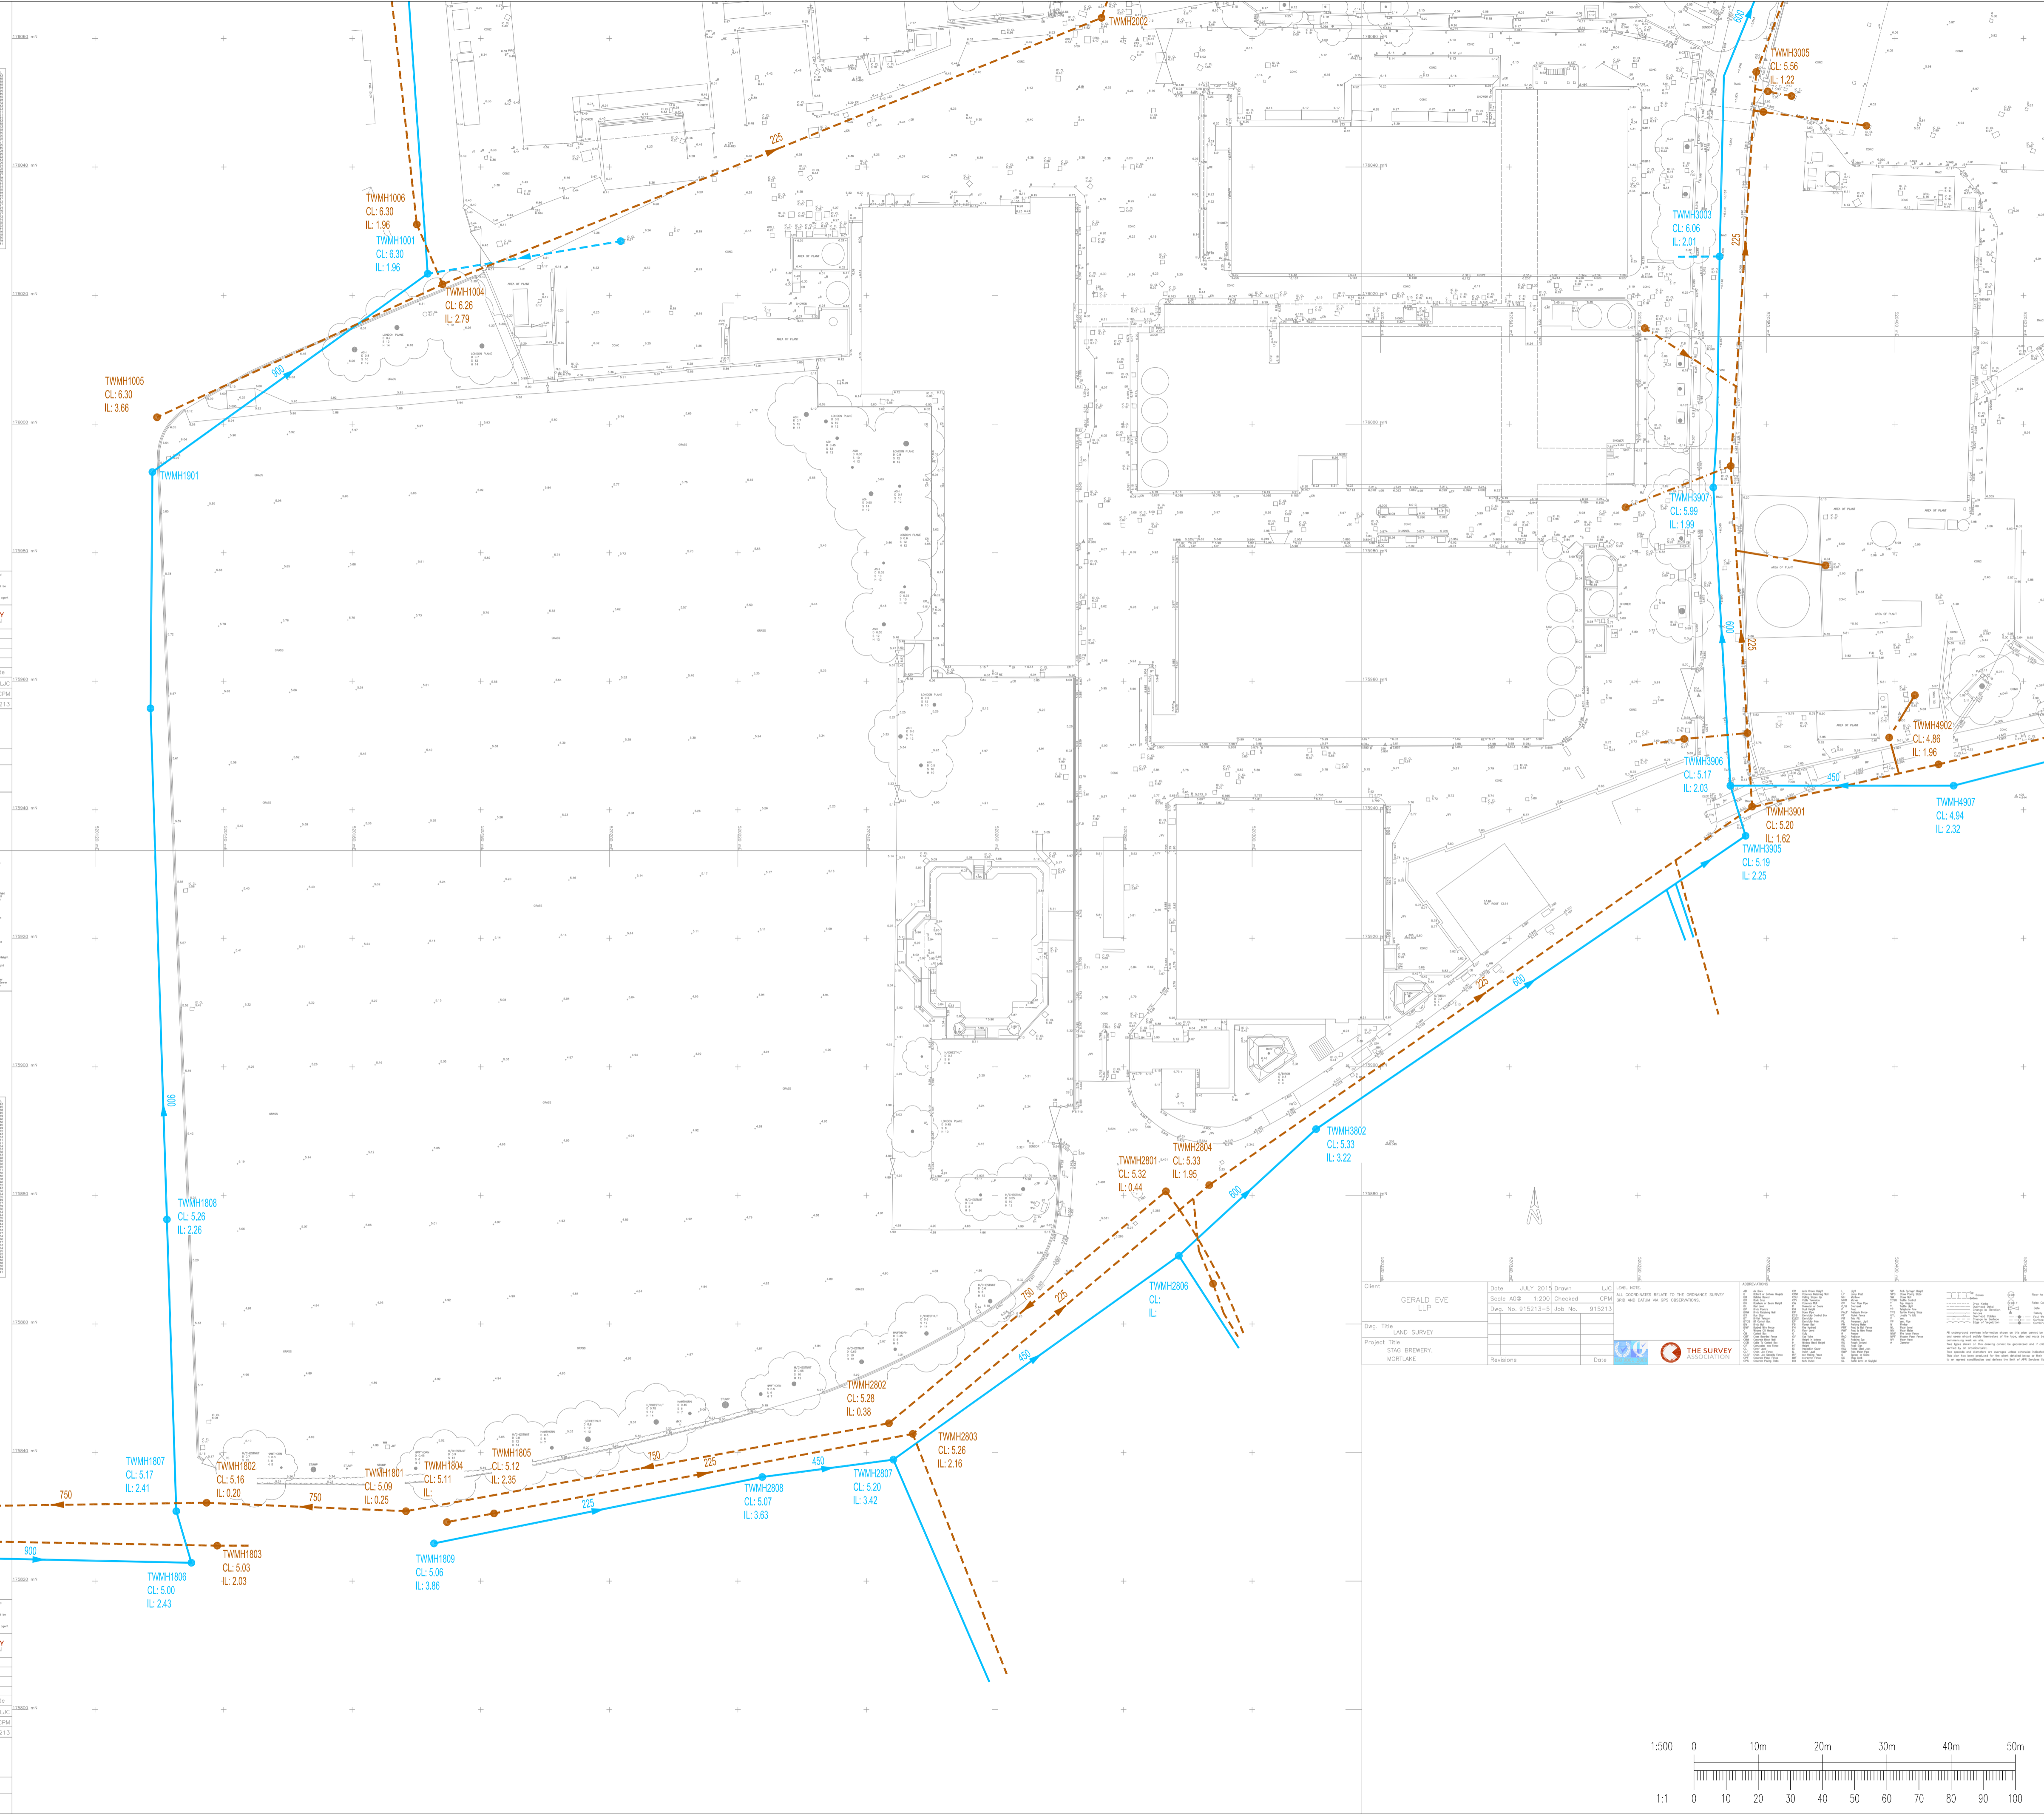

LEGEND

- EXISTING PRIVATE SURFACE WATER SEWER
- EXISTING PRIVATE FOUL SEWER
- EXISTING PRIVATE COMBINED SEWER
- EXISTING PUBLIC SURFACE WATER SEWER
- EXISTING PUBLIC FOUL SEWER
- EXISTING PUBLIC COMBINED SEWER
- EXISTING PUBLIC RISING MAIN

NOTES
1) EXISTING DRAINAGE LAYOUT BASED ON THAMES WATER SEWER RECORDS AND PENBORN TECHNICAL SERVICES DRAWING (REF: P97907/31).

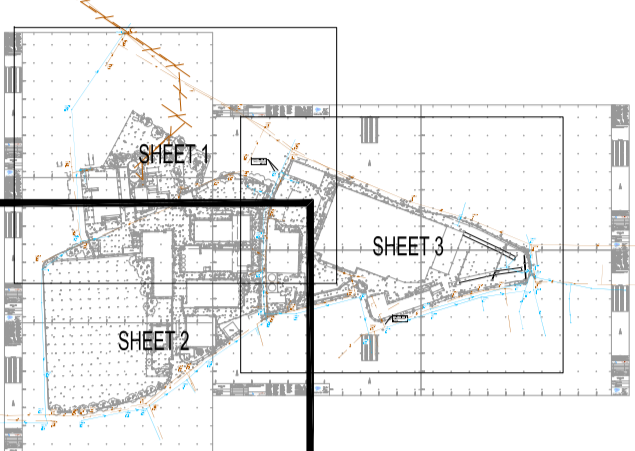

Rev	Date	Description	By
A01	20.10.16	PRELIMINARY ISSUE	DO


Project
STAG BREWERY


Title
EXISTING FOUL AND SURFACE WATER DRAINAGE LAYOUT SHEET 2 OF 3

Client
DARTMOUTH CAPITAL ADVISORS LIMITED



Drawing Status				
PRELIMINARY				
Designed by	Checked by	DO	Project No	WIE10667
Drawn by	DO	Date	OCTOBER 2016	Computer File No
Scales @ A1				WIE10667CSA20002.dwg
work to figured dimensions only				1:500
Publisher	Zone	Category	Number	Revision
WIE	SA	92	0002	A01

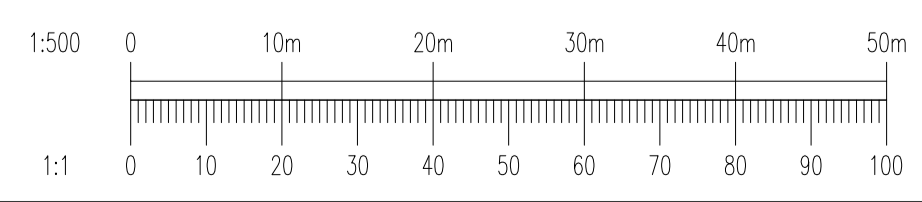


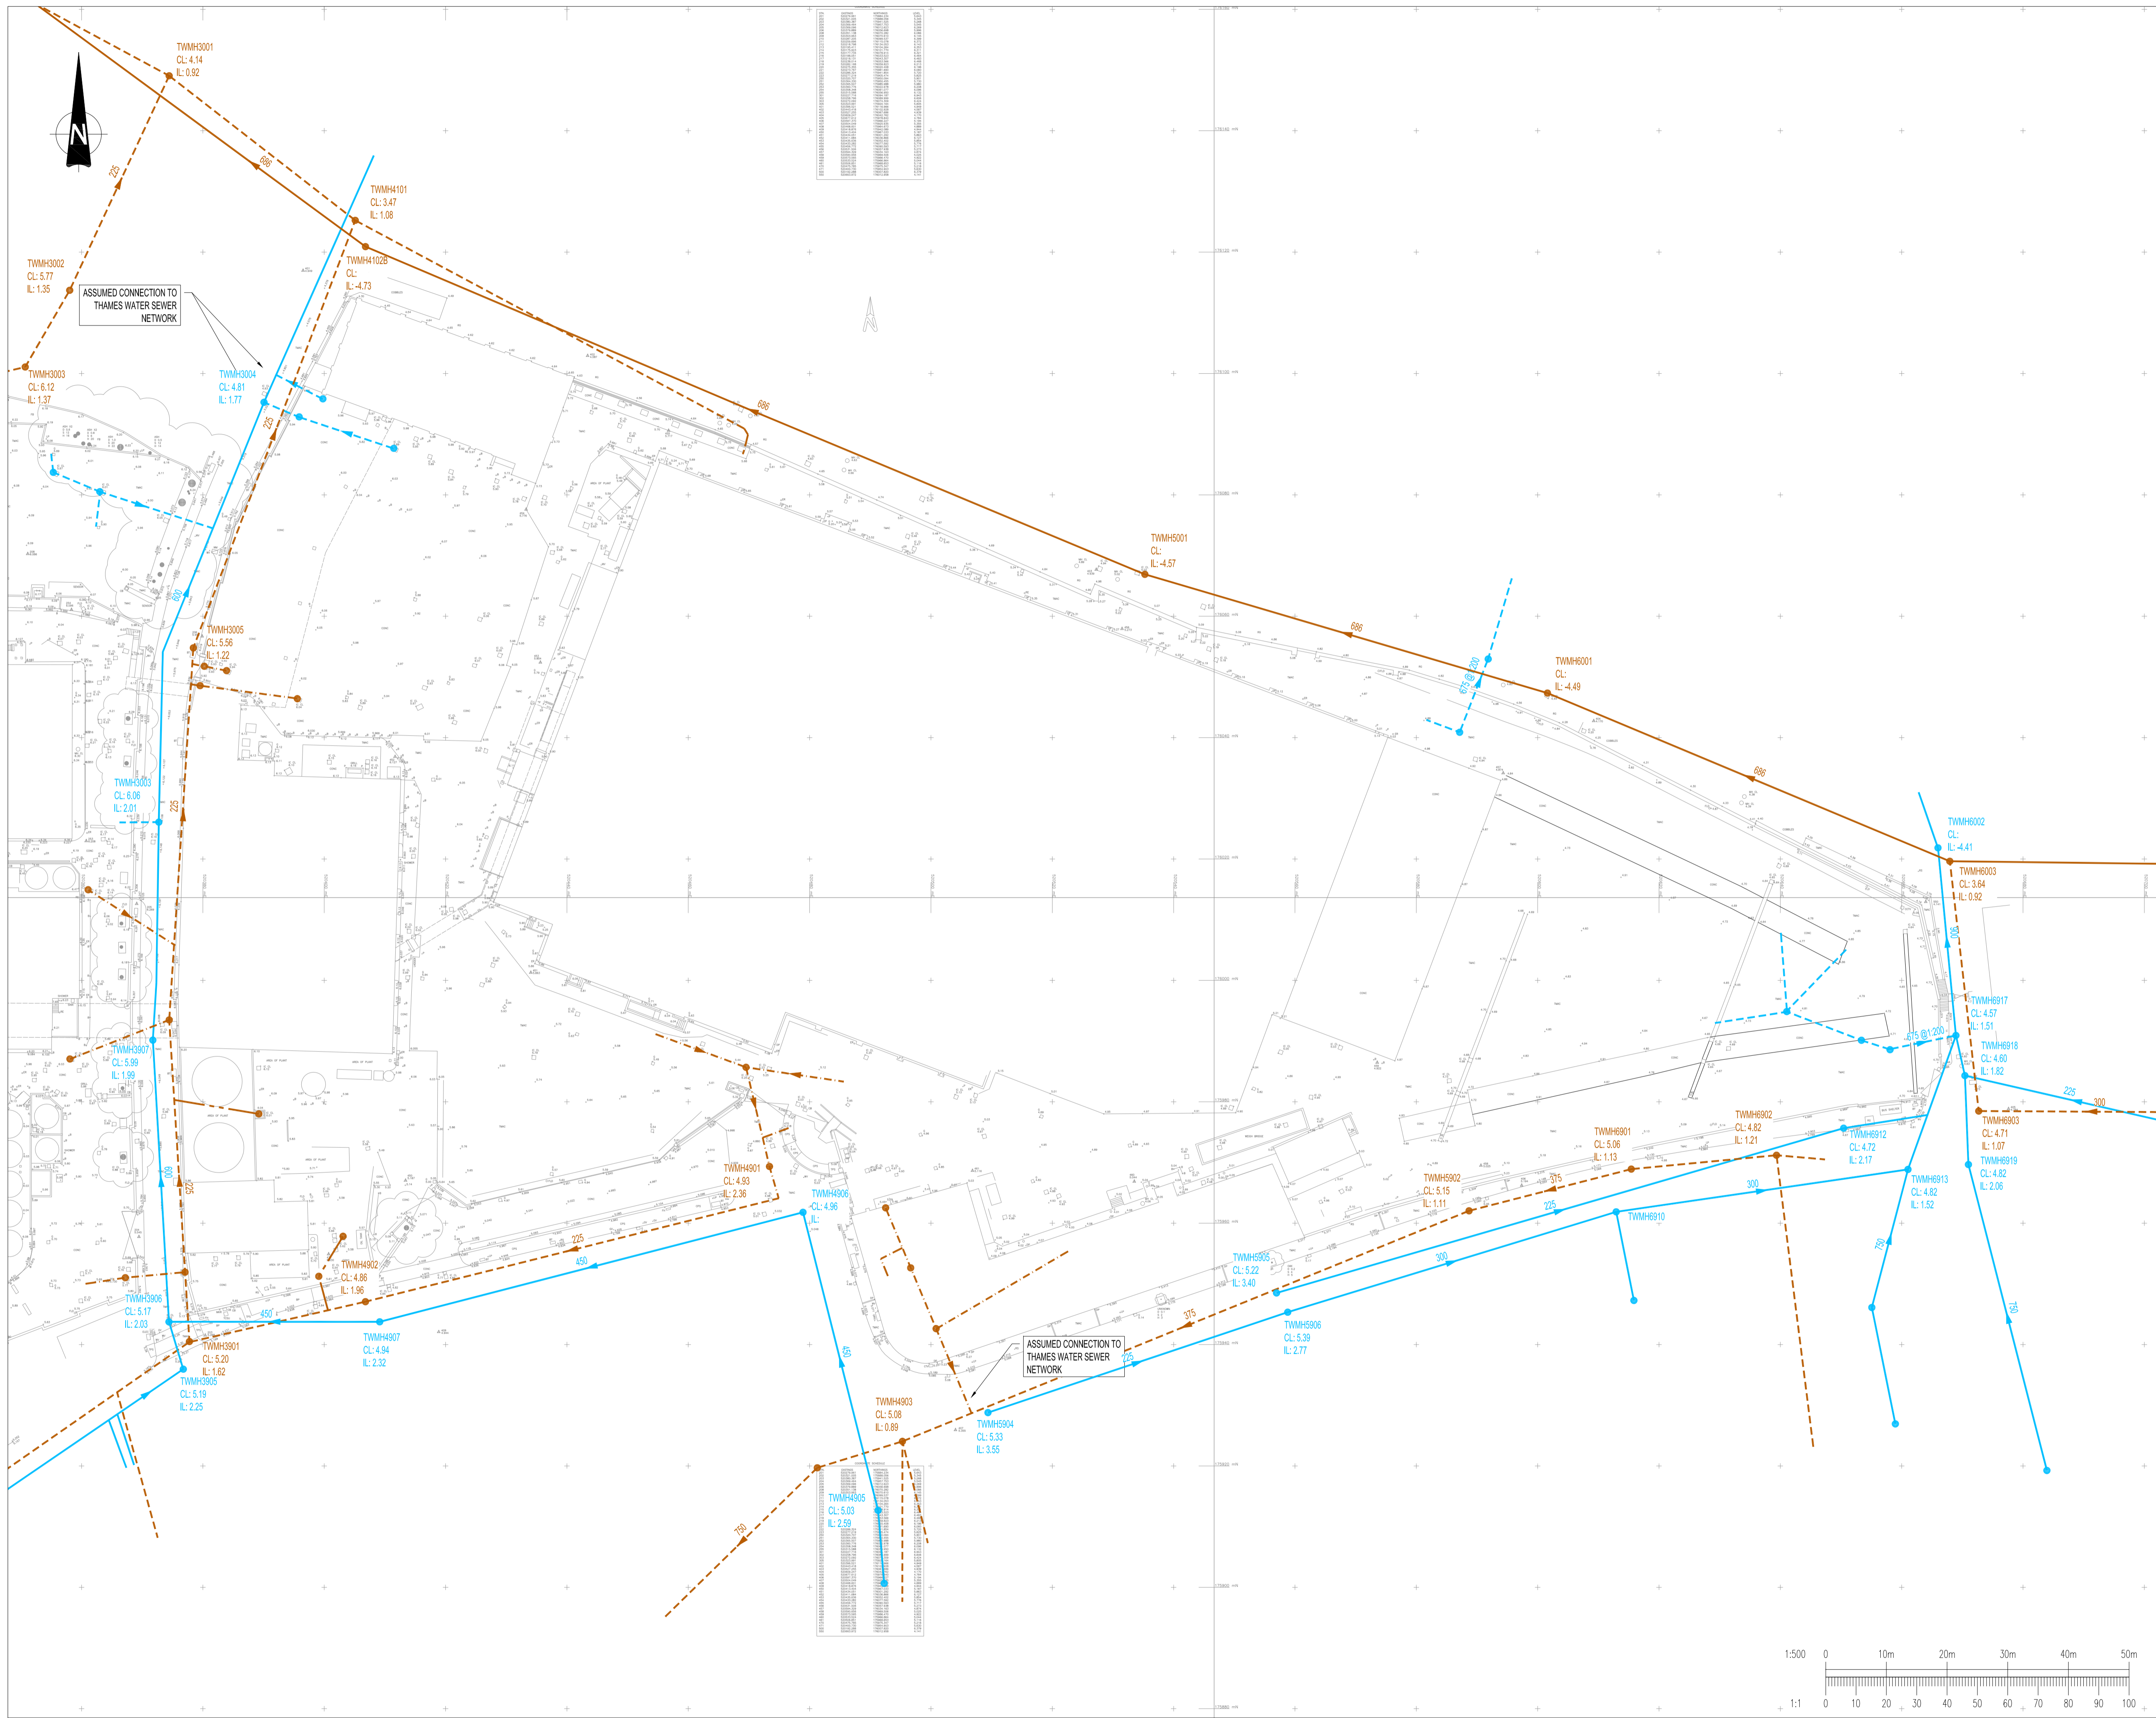

LEGEND

- EXISTING PRIVATE SURFACE WATER SEWER
- EXISTING PRIVATE FOUL SEWER
- EXISTING PRIVATE COMBINED SEWER
- EXISTING PUBLIC SURFACE WATER SEWER
- EXISTING PUBLIC FOUL SEWER
- EXISTING PUBLIC COMBINED SEWER
- EXISTING PUBLIC RISING MAIN

NOTES
 1) EXISTING DRAINAGE LAYOUT BASED ON THAMES WATER SEWER RECORDS AND PENBORN TECHNICAL SERVICES DRAWING (REF: P979/07/31).

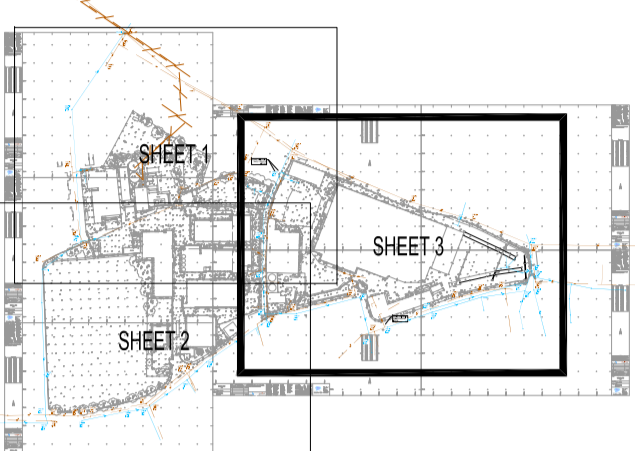

Rev	Date	Description	By
A03	21.11.16	INVERT/COVER LEVELS ADDED	DO
A02	24.10.16	VIEWPORT AMENDED	DO
A01	20.10.16	PRELIMINARY ISSUE	DO

Amendments	
Project	STAG BREWERY
Title	EXISTING FOUL AND SURFACE WATER DRAINAGE LAYOUT SHEET 3 OF 3
Client	DARTMOUTH CAPITAL ADVISORS LIMITED

Pickfords Wharf Clink Street London SE1 9DG
 t 020 7928 7888
 mail@watermangroup.com www.watermangroup.com

Drawing Status		PRELIMINARY	
Designed by	Checked by	DO	Project No
Drawn by	DO	Date	OCTOBER 2016
Scales @ A1		1:500	Computer File No
work to figured dimensions only		1:500	WIE10667CSA280003.dwg
Publisher	Zone	Category	Number
WIE	SA	92	0003
			Revision
			A03

