


LEGEND

- EXISTING PRIVATE SURFACE WATER SEWER
- - - ● - - - EXISTING PRIVATE FOUL SEWER
- EXISTING PRIVATE COMBINED SEWER
- EXISTING PUBLIC SURFACE WATER SEWER
- - - ● - - - EXISTING PUBLIC FOUL SEWER
- EXISTING PUBLIC COMBINED SEWER
- - - - - EXISTING PUBLIC RISING MAIN

NOTES

- 1) EXISTING DRAINAGE LAYOUT BASED ON THAMES WATER SEWER RECORDS AND PENBORN TECHNICAL SERVICES DRAWING (REF: P9790731).

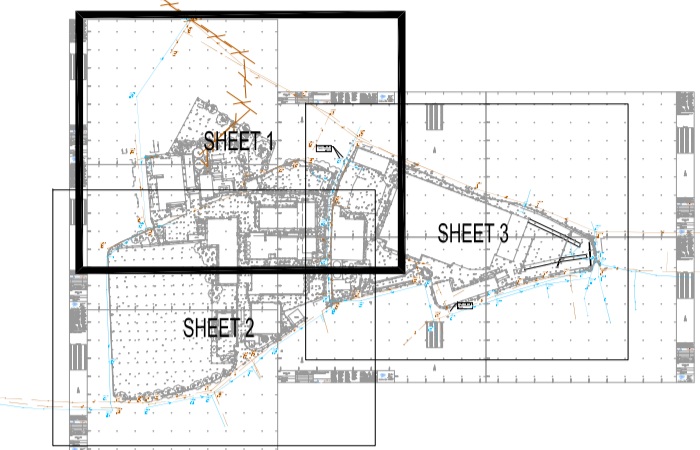

Client: GERALD EVE LLP Date: JULY 2016 Project Title: STAG BREWERY, MORTLAKE	Date: JULY 2016 Rev: A06 No. of Issues: 915213	Level: NPL No. of Coordinates: 915213 No. of Issues: 915213	TWMH3104 CL: -4.82 IL: -4.82
--	--	---	------------------------------------

THE SURVEY
 SURVEYORS
 150 NEWINGTON GREEN, LONDON SE14 6NU
 TEL: 020 7811 2222
 FAX: 020 7811 2223
 WWW.THE-SURVEY.CO.UK


Rev	Date	Description	By
A01	20.10.16	PRELIMINARY ISSUE	DO

Rev	Date	Description	By
A01	20.10.16	PRELIMINARY ISSUE	DO

Amendments			
STAG BREWERY			
EXISTING FOUL AND SURFACE WATER DRAINAGE LAYOUT SHEET 1 OF 3			
Client: DARTMOUTH CAPITAL ADVISORS LIMITED			

Pickfords Wharf Clink Street London SE1 9DG
 1 020 7929 7868
 mail@watermangroup.com www.watermangroup.com

PRELIMINARY				
Designed by	Checked by	DO	Project No	WIE10667
Drawn by	DO	Date	OCTOBER 2016	Computer File No
Scales @ A1	1:500	WIE10667-3A20001.dwg		
Work to figured dimensions only				
Author	Zone	Category	Number	Revision
WIE	SA	92	0001	A01

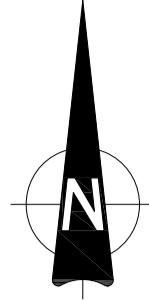

Revisions	Date	Drawn	LC



Revisions	Date	Drawn	LC

Client: GERALD EVE LLP

Project Title: LAND SURVEY

Project Title: STAG BREWERY, MORTLAKE

Scale: A09 1:200 Checked: CPU

Drawn: No. 915213-2 Job No. 915213

Client: GERALD EVE LLP

Project Title: LAND SURVEY

Project Title: STAG BREWERY, MORTLAKE

Scale: A09 1:200 Checked: CPU

Drawn: No. 915213-2 Job No. 915213

Client: GERALD EVE LLP

Project Title: LAND SURVEY

Project Title: STAG BREWERY, MORTLAKE

Scale: A09 1:200 Checked: CPU

Drawn: No. 915213-2 Job No. 915213

Client: GERALD EVE LLP

Project Title: LAND SURVEY

Project Title: STAG BREWERY, MORTLAKE

Scale: A09 1:200 Checked: CPU

Drawn: No. 915213-2 Job No. 915213

Client: GERALD EVE LLP

Project Title: LAND SURVEY

Project Title: STAG BREWERY, MORTLAKE

Scale: A09 1:200 Checked: CPU

Drawn: No. 915213-2 Job No. 915213

Client: GERALD EVE LLP

Project Title: LAND SURVEY

Project Title: STAG BREWERY, MORTLAKE

Scale: A09 1:200 Checked: CPU

Drawn: No. 915213-2 Job No. 915213

Client: GERALD EVE LLP

Project Title: LAND SURVEY

Project Title: STAG BREWERY, MORTLAKE

Scale: A09 1:200 Checked: CPU

Drawn: No. 915213-2 Job No. 915213

Client: GERALD EVE LLP

Project Title: LAND SURVEY

Project Title: STAG BREWERY, MORTLAKE

Scale: A09 1:200 Checked: CPU

Drawn: No. 915213-2 Job No. 915213

Client: GERALD EVE LLP

Project Title: LAND SURVEY

Project Title: STAG BREWERY, MORTLAKE

Scale: A09 1:200 Checked: CPU

Drawn: No. 915213-2 Job No. 915213

Client: GERALD EVE LLP

Project Title: LAND SURVEY

Project Title: STAG BREWERY, MORTLAKE

Scale: A09 1:200 Checked: CPU

Drawn: No. 915213-2 Job No. 915213

Client: GERALD EVE LLP

Project Title: LAND SURVEY

Project Title: STAG BREWERY, MORTLAKE

Scale: A09 1:200 Checked: CPU


Drawn: No. 915213-2 Job No. 915213

Client: GERALD EVE LLP

Project Title: LAND SURVEY

Project Title: STAG BREWERY, MORTLAKE


Scale: A09 1:200 Checked: CPU

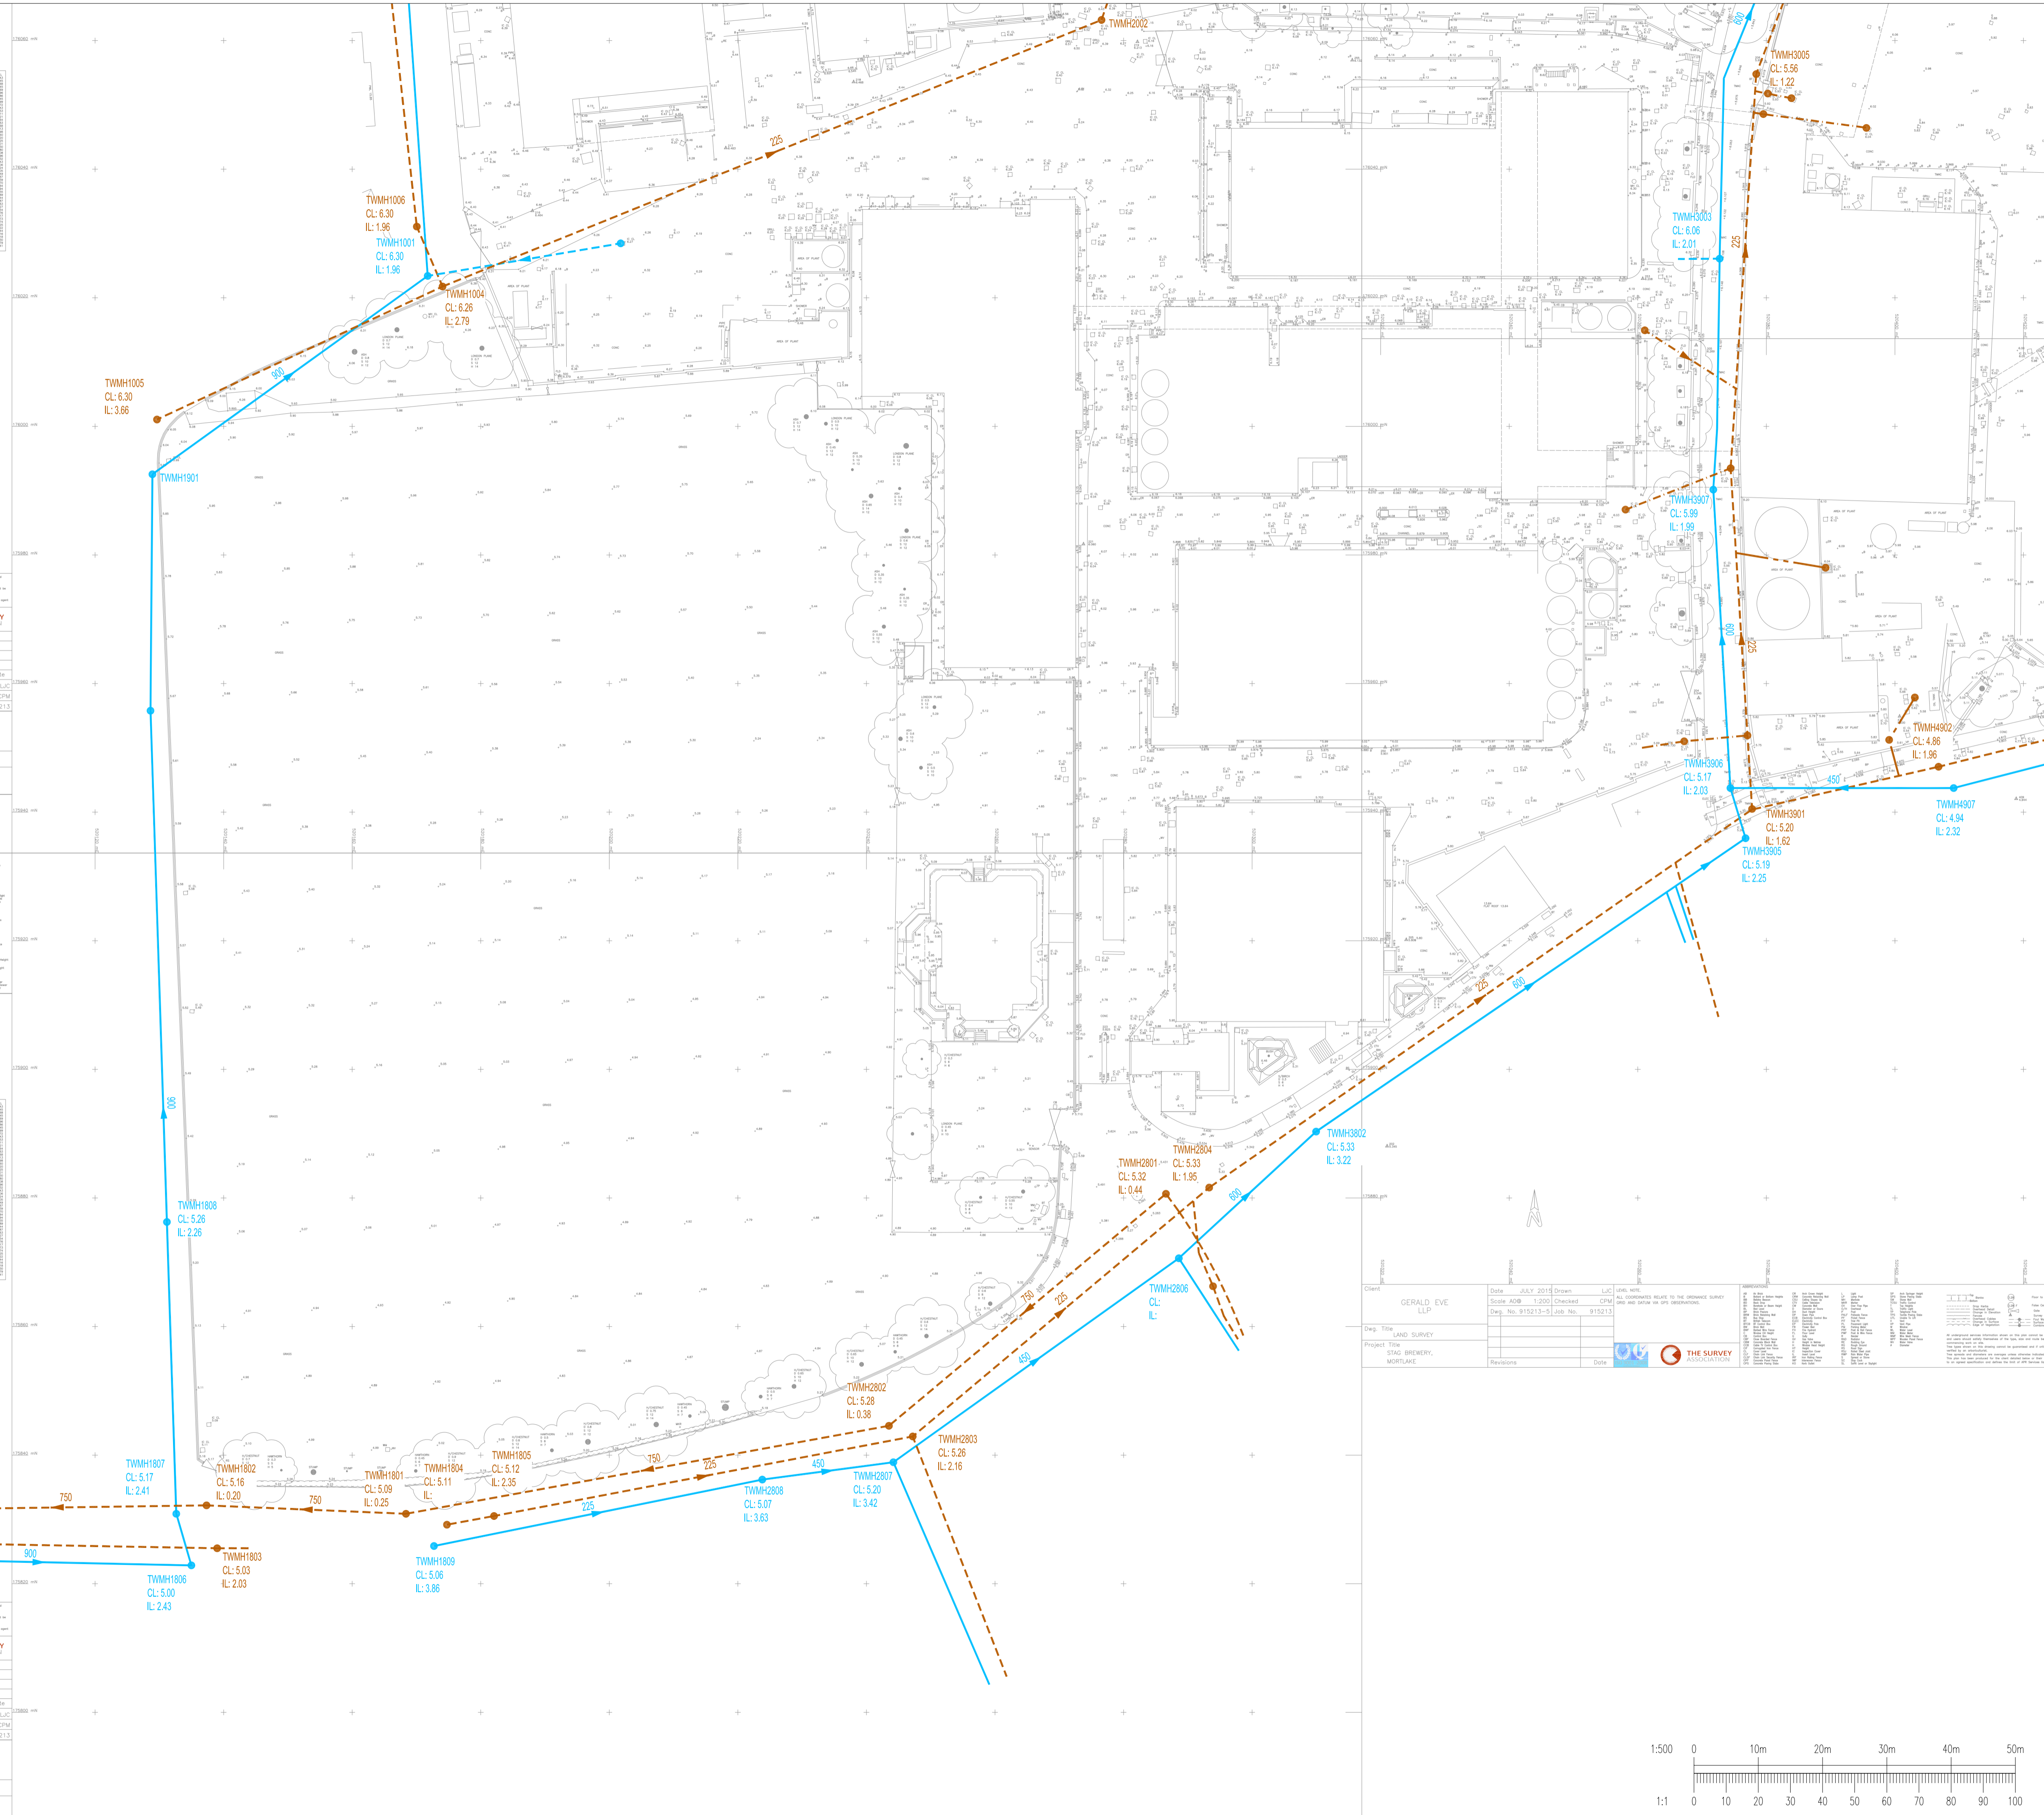

LEGEND

- EXISTING PRIVATE SURFACE WATER SEWER
- EXISTING PRIVATE FOUL SEWER
- EXISTING PRIVATE COMBINED SEWER
- EXISTING PUBLIC SURFACE WATER SEWER
- EXISTING PUBLIC FOUL SEWER
- EXISTING PUBLIC COMBINED SEWER
- EXISTING PUBLIC RISING MAIN

NOTES
 1) EXISTING DRAINAGE LAYOUT BASED ON THAMES WATER SEWER RECORDS AND PENBORN TECHNICAL SERVICES DRAWING (REF: P97907031).

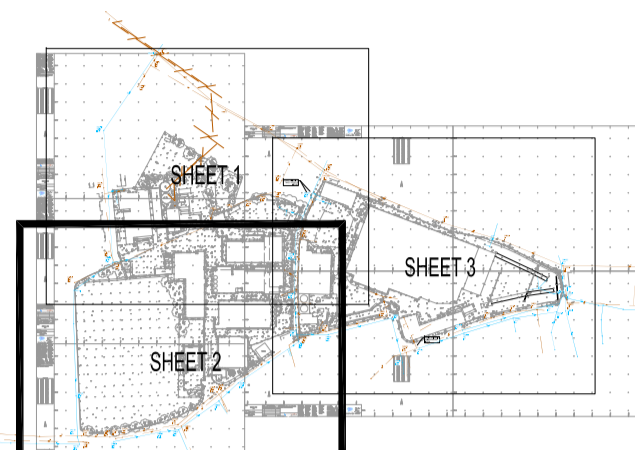

Revisions	Date	Drawn	LC

Client: GERALD EVE LLP

Project Title: LAND SURVEY

Project Title: STAG BREWERY, MORTLAKE

Scale: A09 1:200 Checked: CPU

Drawn: No. 915213-5 Job No. 915213

Client: GERALD EVE LLP

Project Title: LAND SURVEY

Project Title: STAG BREWERY, MORTLAKE

Scale: A09 1:200 Checked: CPU

Drawn: No. 915213-5 Job No. 915213

Client: GERALD EVE LLP

Project Title: LAND SURVEY

Project Title: STAG BREWERY, MORTLAKE

Scale: A09 1:200 Checked: CPU

Drawn: No. 915213-5 Job No. 915213

Client: GERALD EVE LLP

Project Title: LAND SURVEY

Project Title: STAG BREWERY, MORTLAKE

Scale: A09 1:200 Checked: CPU

Drawn: No. 915213-5 Job No. 915213

Client: GERALD EVE LLP

Project Title: LAND SURVEY

Project Title: STAG BREWERY, MORTLAKE

Scale: A09 1:200 Checked: CPU

Drawn: No. 915213-5 Job No. 915213

Rev	Date	Description	By
A01	20.10.16	PRELIMINARY ISSUE	DO

Project: **STAG BREWERY**

Title: **EXISTING FOUL AND SURFACE WATER DRAINAGE LAYOUT SHEET 2 OF 3**

Client: **DARTMOUTH CAPITAL ADVISORS LIMITED**




Drawing Status: **PRELIMINARY**


Designed by: - Checked by: DO Project No: **WIE10667**

Drawn by: DO Date: **OCTOBER 2016** Computer File No: **WIE10667CSA20002.dwg**

Scales @ A1: work to figured dimensions only **1:500**

Publisher	Zone	Category	Number	Revision
WIE	SA	92	0002	A01

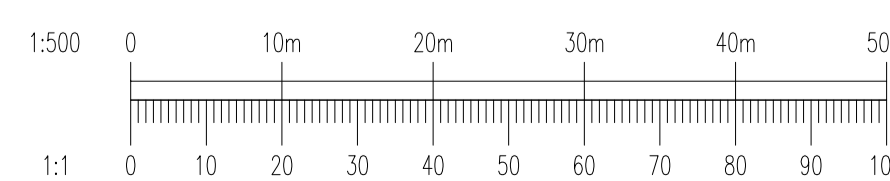


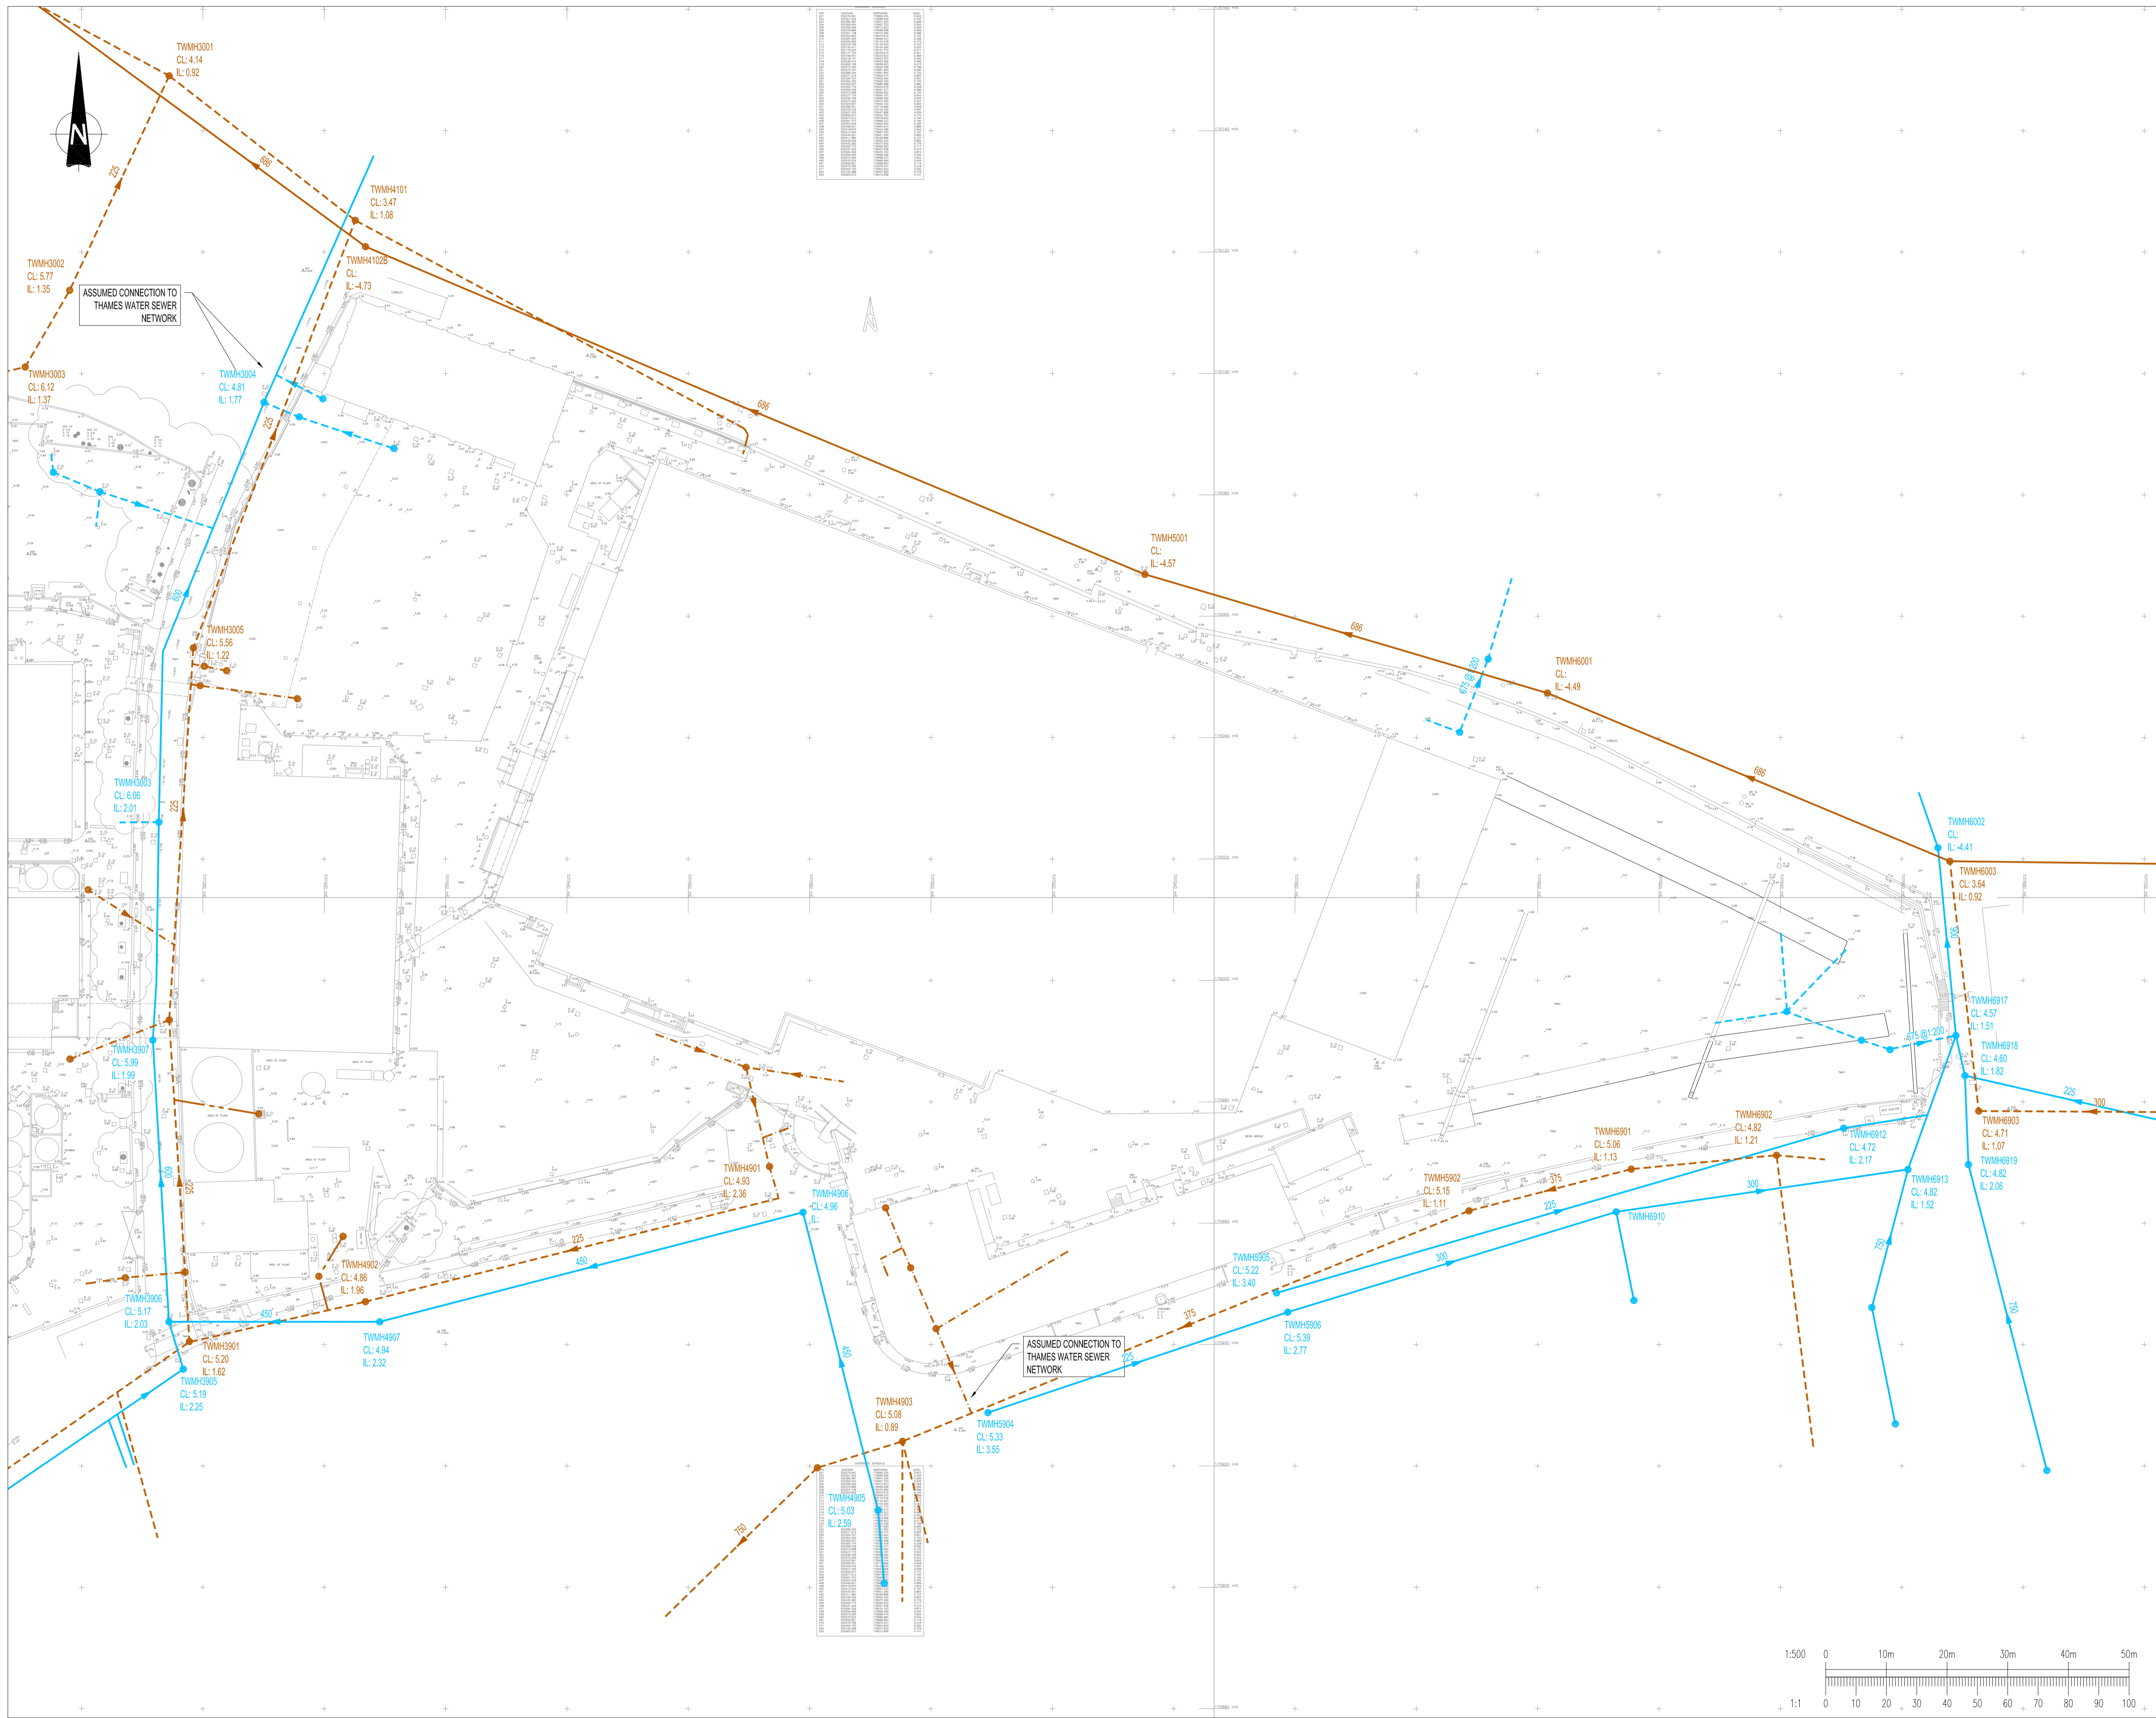

LEGEND

- EXISTING PRIVATE SURFACE WATER SEWER
- EXISTING PRIVATE FOUL SEWER
- EXISTING PRIVATE COMBINED SEWER
- EXISTING PUBLIC SURFACE WATER SEWER
- EXISTING PUBLIC FOUL SEWER
- EXISTING PUBLIC COMBINED SEWER
- EXISTING PUBLIC RISING MAIN

NOTES
 1) EXISTING DRAINAGE LAYOUT BASED ON THAMES WATER SEWER RECORDS AND PENBORN TECHNICAL SERVICES DRAWING (REF: P979/07/31).

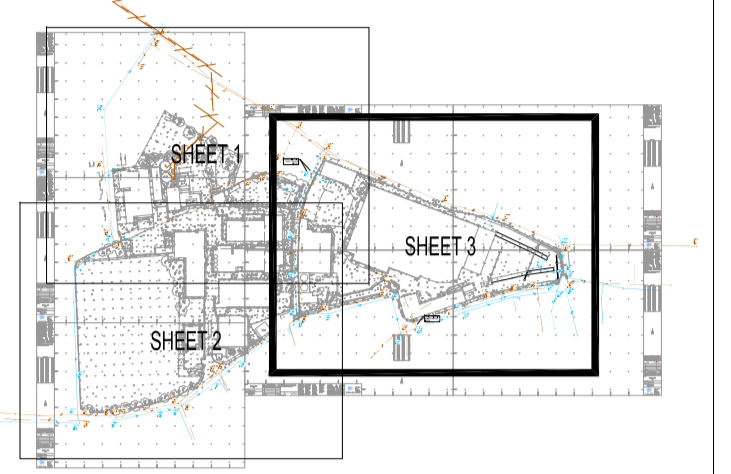

Rev	Date	Description	By
A03	21.11.16	INVERT/COVER LEVELS ADDED	DO
A02	24.10.16	VIEWPORT AMENDED	DO
A01	20.10.16	PRELIMINARY ISSUE	DO

Amendments	
Project	STAG BREWERY
Title	EXISTING FOUL AND SURFACE WATER DRAINAGE LAYOUT SHEET 3 OF 3
Client	DARTMOUTH CAPITAL ADVISORS LIMITED

Pickfords Wharf Clink Street London SE1 9DG
 t 020 7928 7888
 mail@watermangroup.com www.watermangroup.com

Drawing Status		PRELIMINARY	
Designed by	Checked by	DO	Project No
Drawn by	DO	Date	OCTOBER 2016
Scales @ A1		1:500	Computer File No
work to figured dimensions only		1:500	WIE10667CSA280003.dwg
Publisher	Zone	Category	Number
WIE	SA	92	0003
			Revision
			A03

