



PROPOSED BASEMENT FLOOR  
1:100 ①

 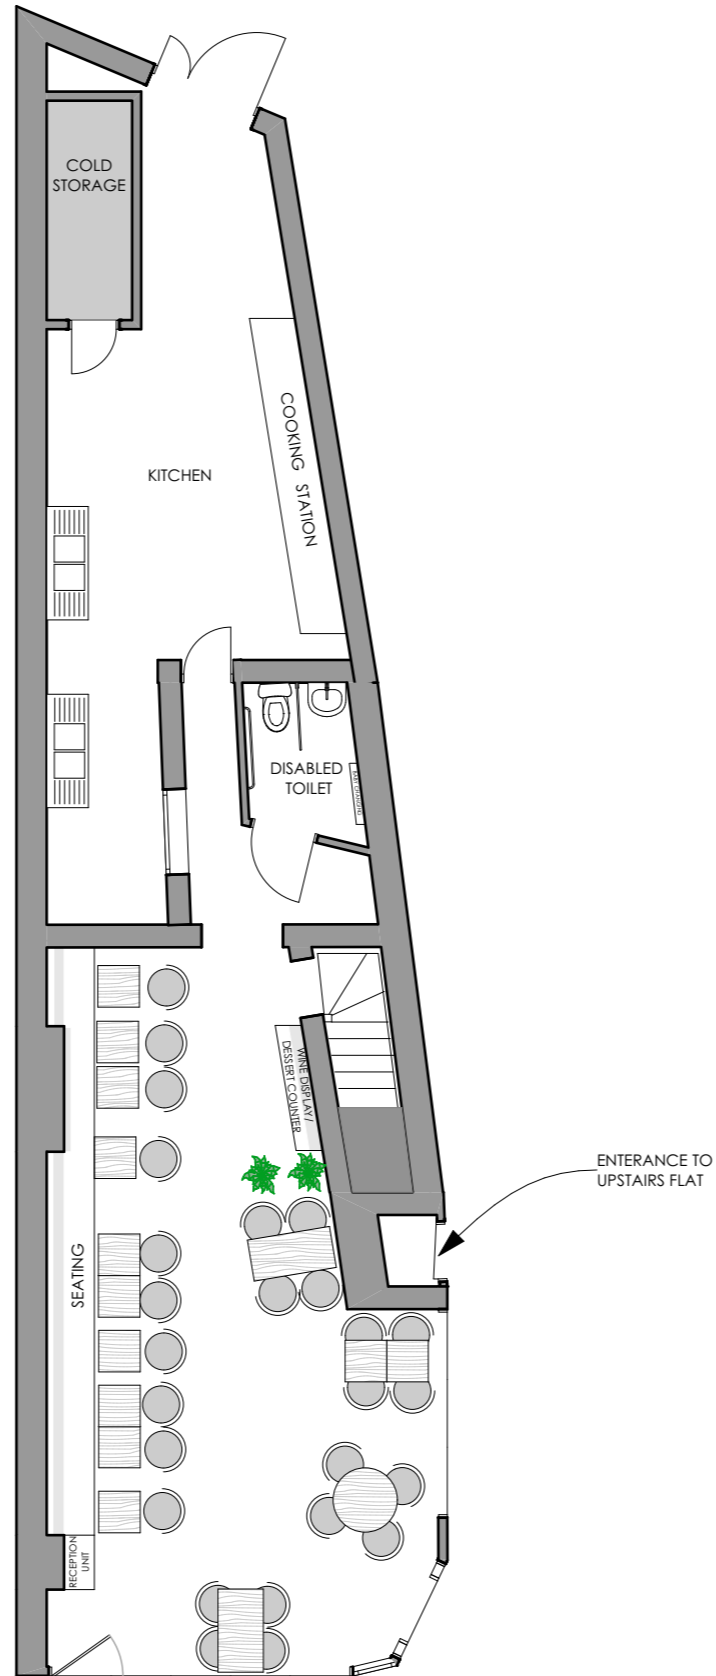


PROPOSED GROUND FLOOR  
1:100 ②

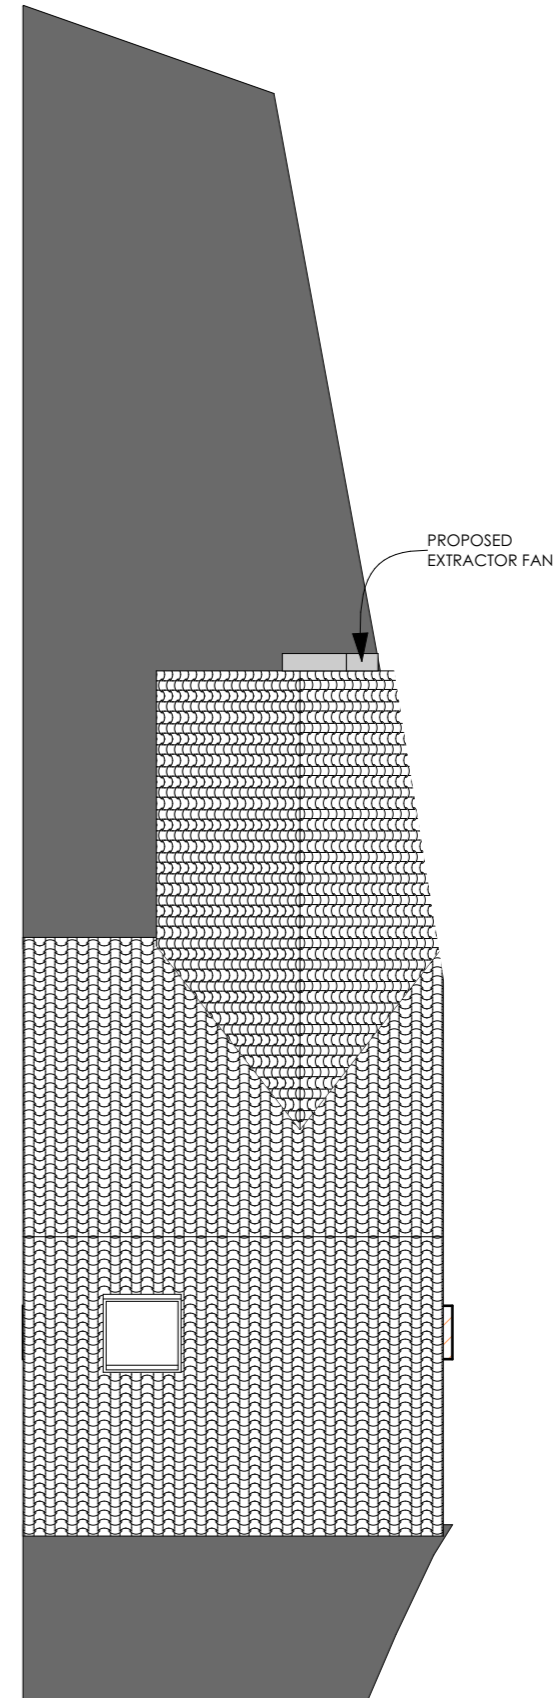

PROPOSED ROOF  
1:100 ③

# PROPOSED FLOOR PLANS



Site Address: 1 The Broadway,  
London SW13 0NY

**PROPOSED EXTRACTOR FAN AND  
DUCTING**

Client: Mr Devendar Manly Singh

3 cm ACTUAL

IF THE ABOVE DIMENSION DOES NOT  
MEASURE THREE CENTIMETERS  
(3 cm) EXACTLY, THIS DRAWING WILL  
HAVE BEEN ENLARGED OR REDUCED,  
AFFECTING ALL LABELED SCALES.

BY	REVISIONS	DATE

Date:	08/04/2021
Scale:	1:100
Drawn By:	R.S
Job No:	0344
Sheet Size:	A3
Revision:	

**E.05**

Plotted On: 08/04/2021

© COPYRIGHT CREATIVE ARCH



Inspire  
Design  
Build

www.creativearch.co.uk

020 8226 6663

PROPOSED FLOOR PLANS