




REVISION DETAILS		DATE	DRAWN BY
P 1	ISSUE FOR PLANNING	17.01.20	DMA
P 2	STAGE 3 ISSUE POST PLANNING	14.02.20	DMA
P 3	REVISED PLANNING DRAWINGS	28.02.20	DMA
P 4	PLANNING ISSUE	16.03.21	DMA

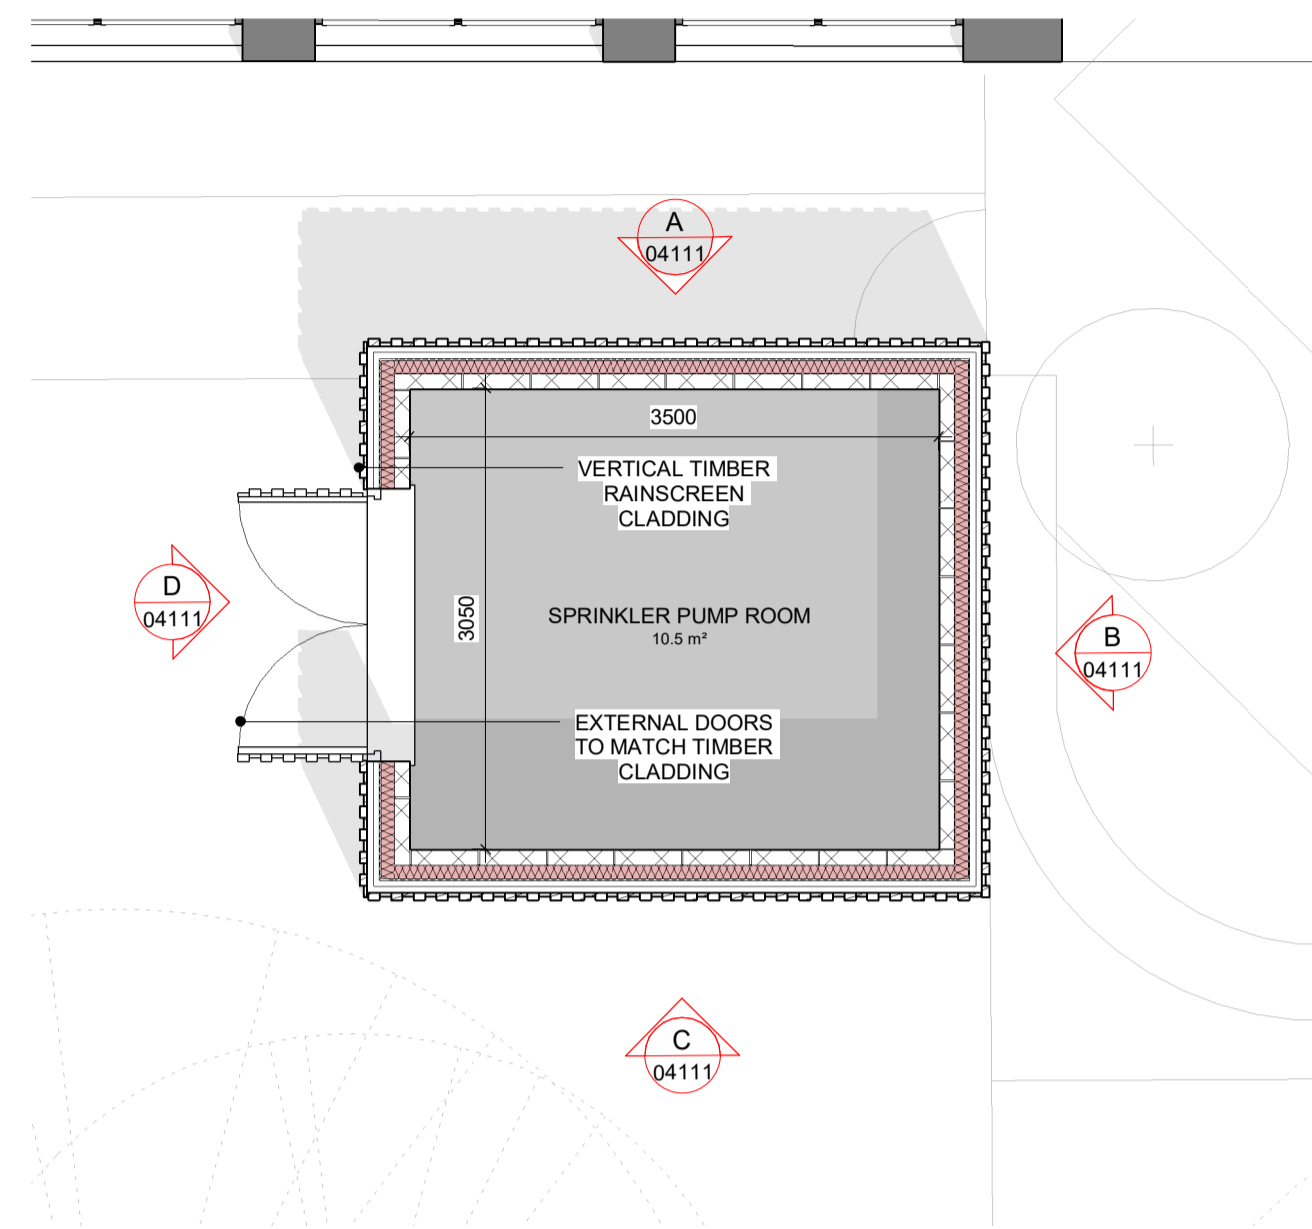


1 SPRINKLER TANK PUMP ROOM - GROUND FLOOR PLAN 1:50

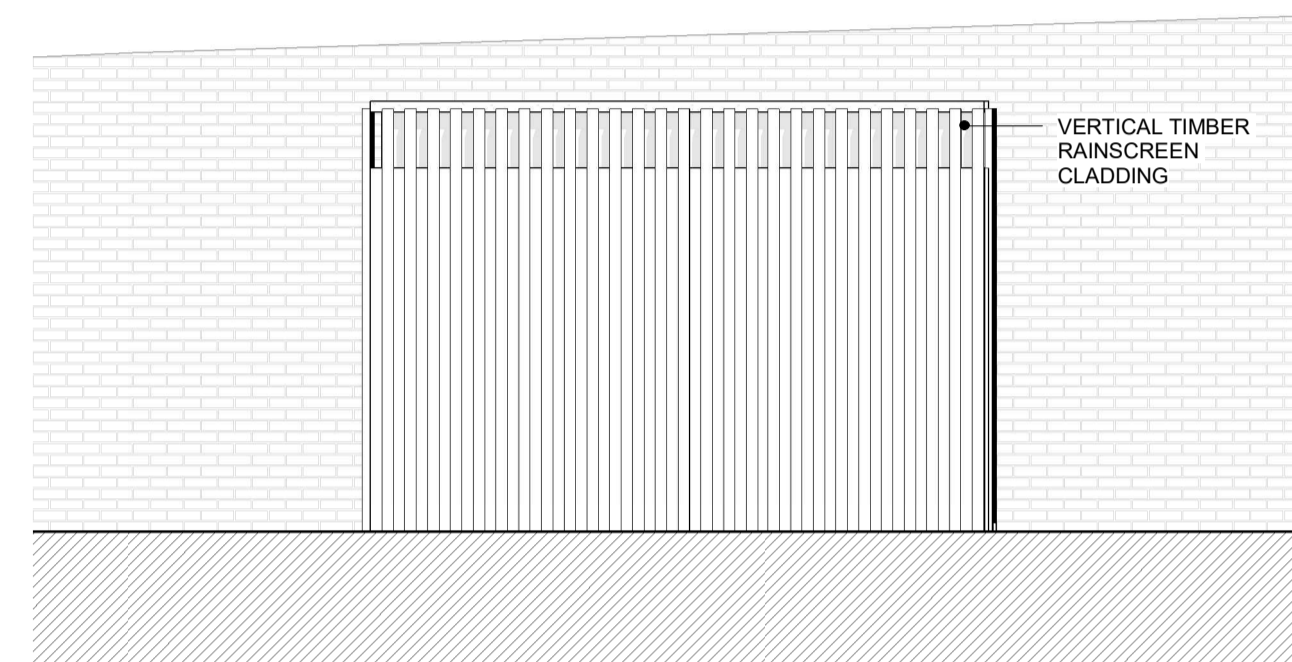


A SPRINKLER TANK PUMP ROOM - NORTH ELEVATION 1:50

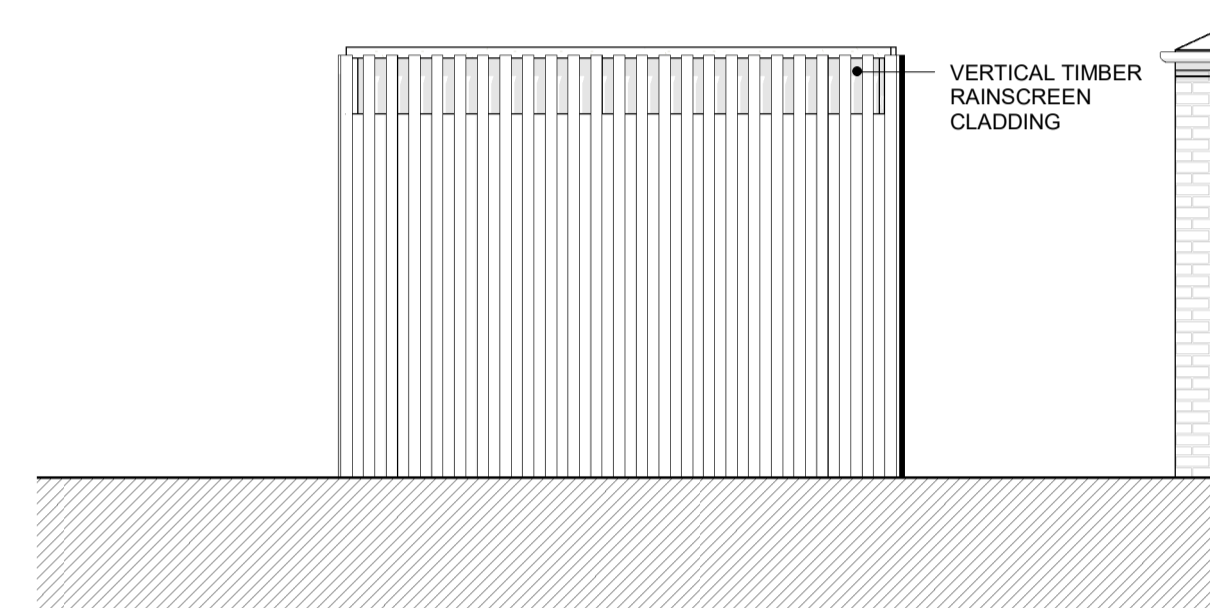


B SPRINKLER TANK PUMP ROOM - EAST ELEVATION 1:50

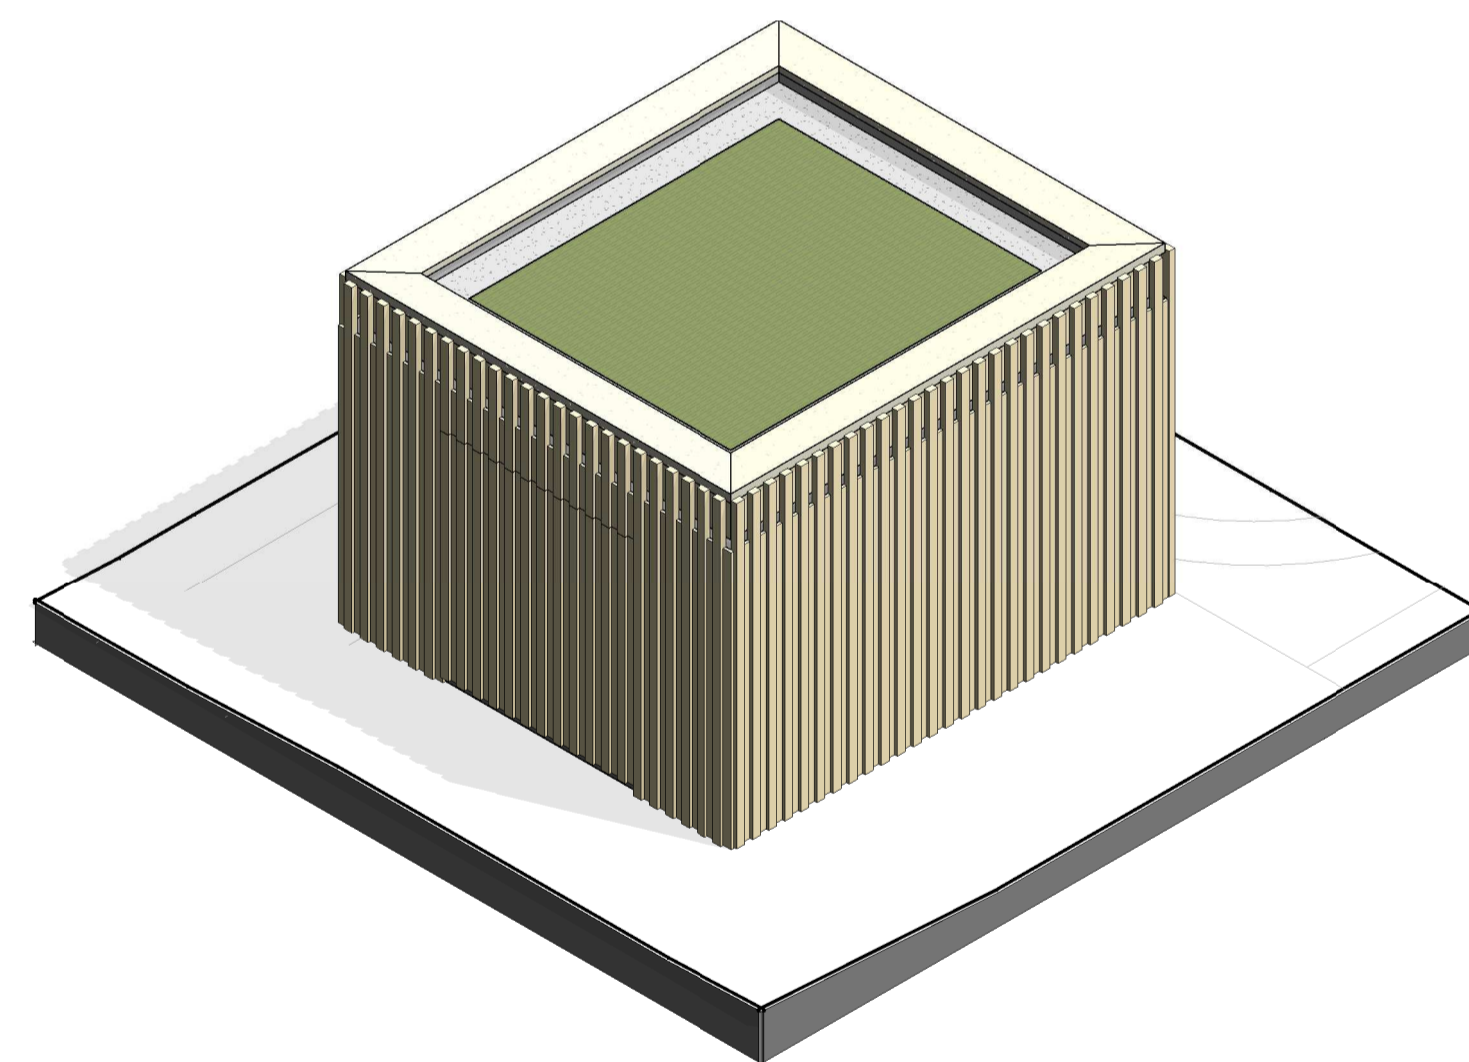

3D SPRINKLER TANK PUMP ROOM AXONOMETRIC

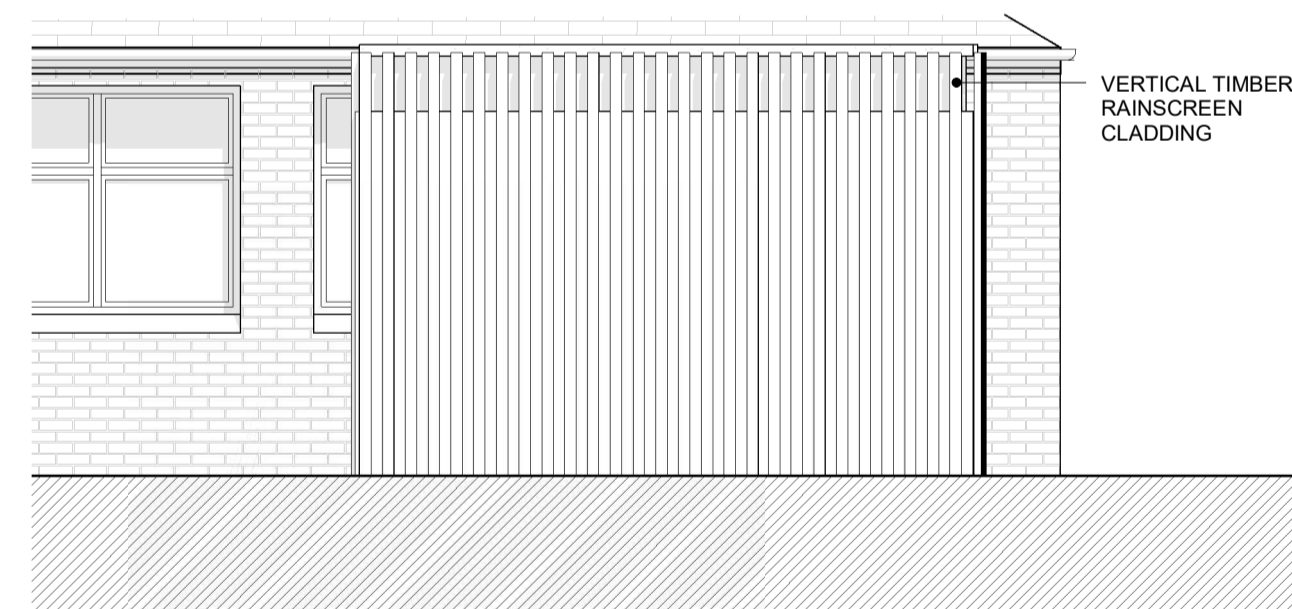

C SPRINKLER TANK PUMP ROOM - SOUTH ELEVATION 1:50

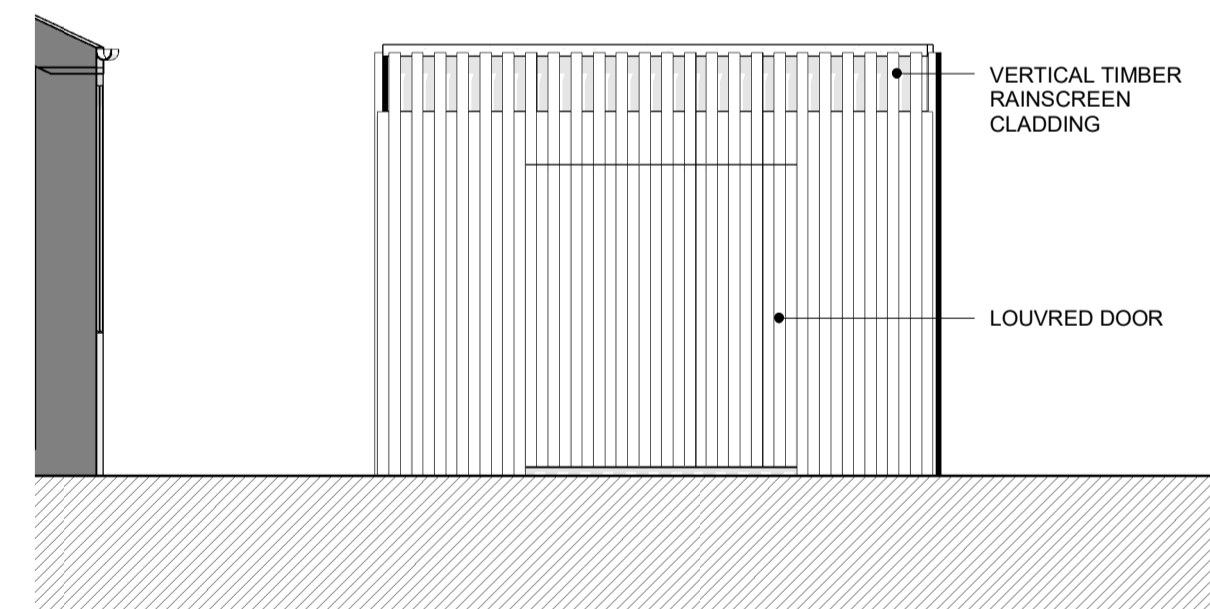


D SPRINKLER TANK PUMP ROOM - WEST ELEVATION 1:50



KEY RESIDUAL RISK

KEY PLAN

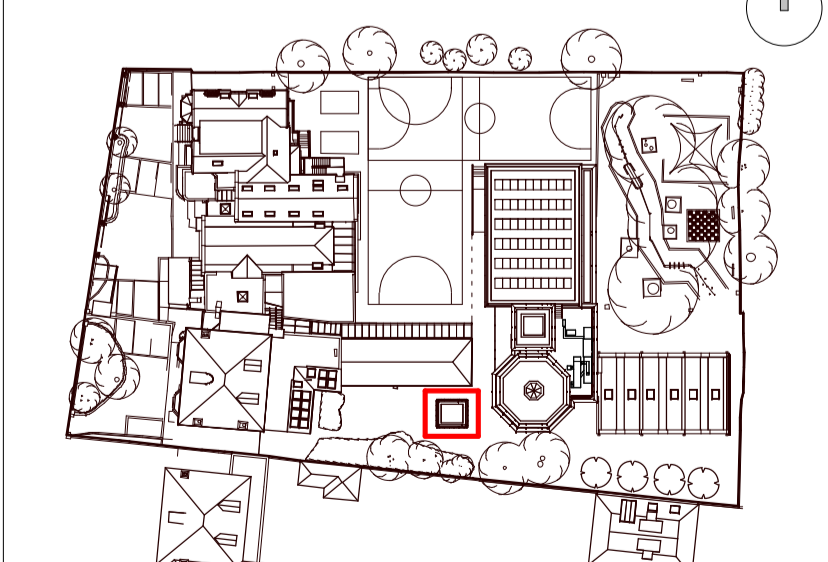

ORIGINATOR DMA		TITLE SPRINKLER TANK PUMP ROOM ELEVATIONS	
PROJECT KING'S HOUSE SCHOOL 68 KING'S ROAD RICHMOND TW10 6ES	PURPOSE OF ISSUE FOR INFORMATION	STATUS S2	REVISION: P4
JOB NO. 515	SCALE 1:50 @A1	DRAWN MF	CHECKED APPROVED TE DMA
PROJECT KHS	ORIGINATOR DMA	VOLUME XX	LEVEL TYPE ROLE DOC NO ZZ DR A 04111