




Location Plan

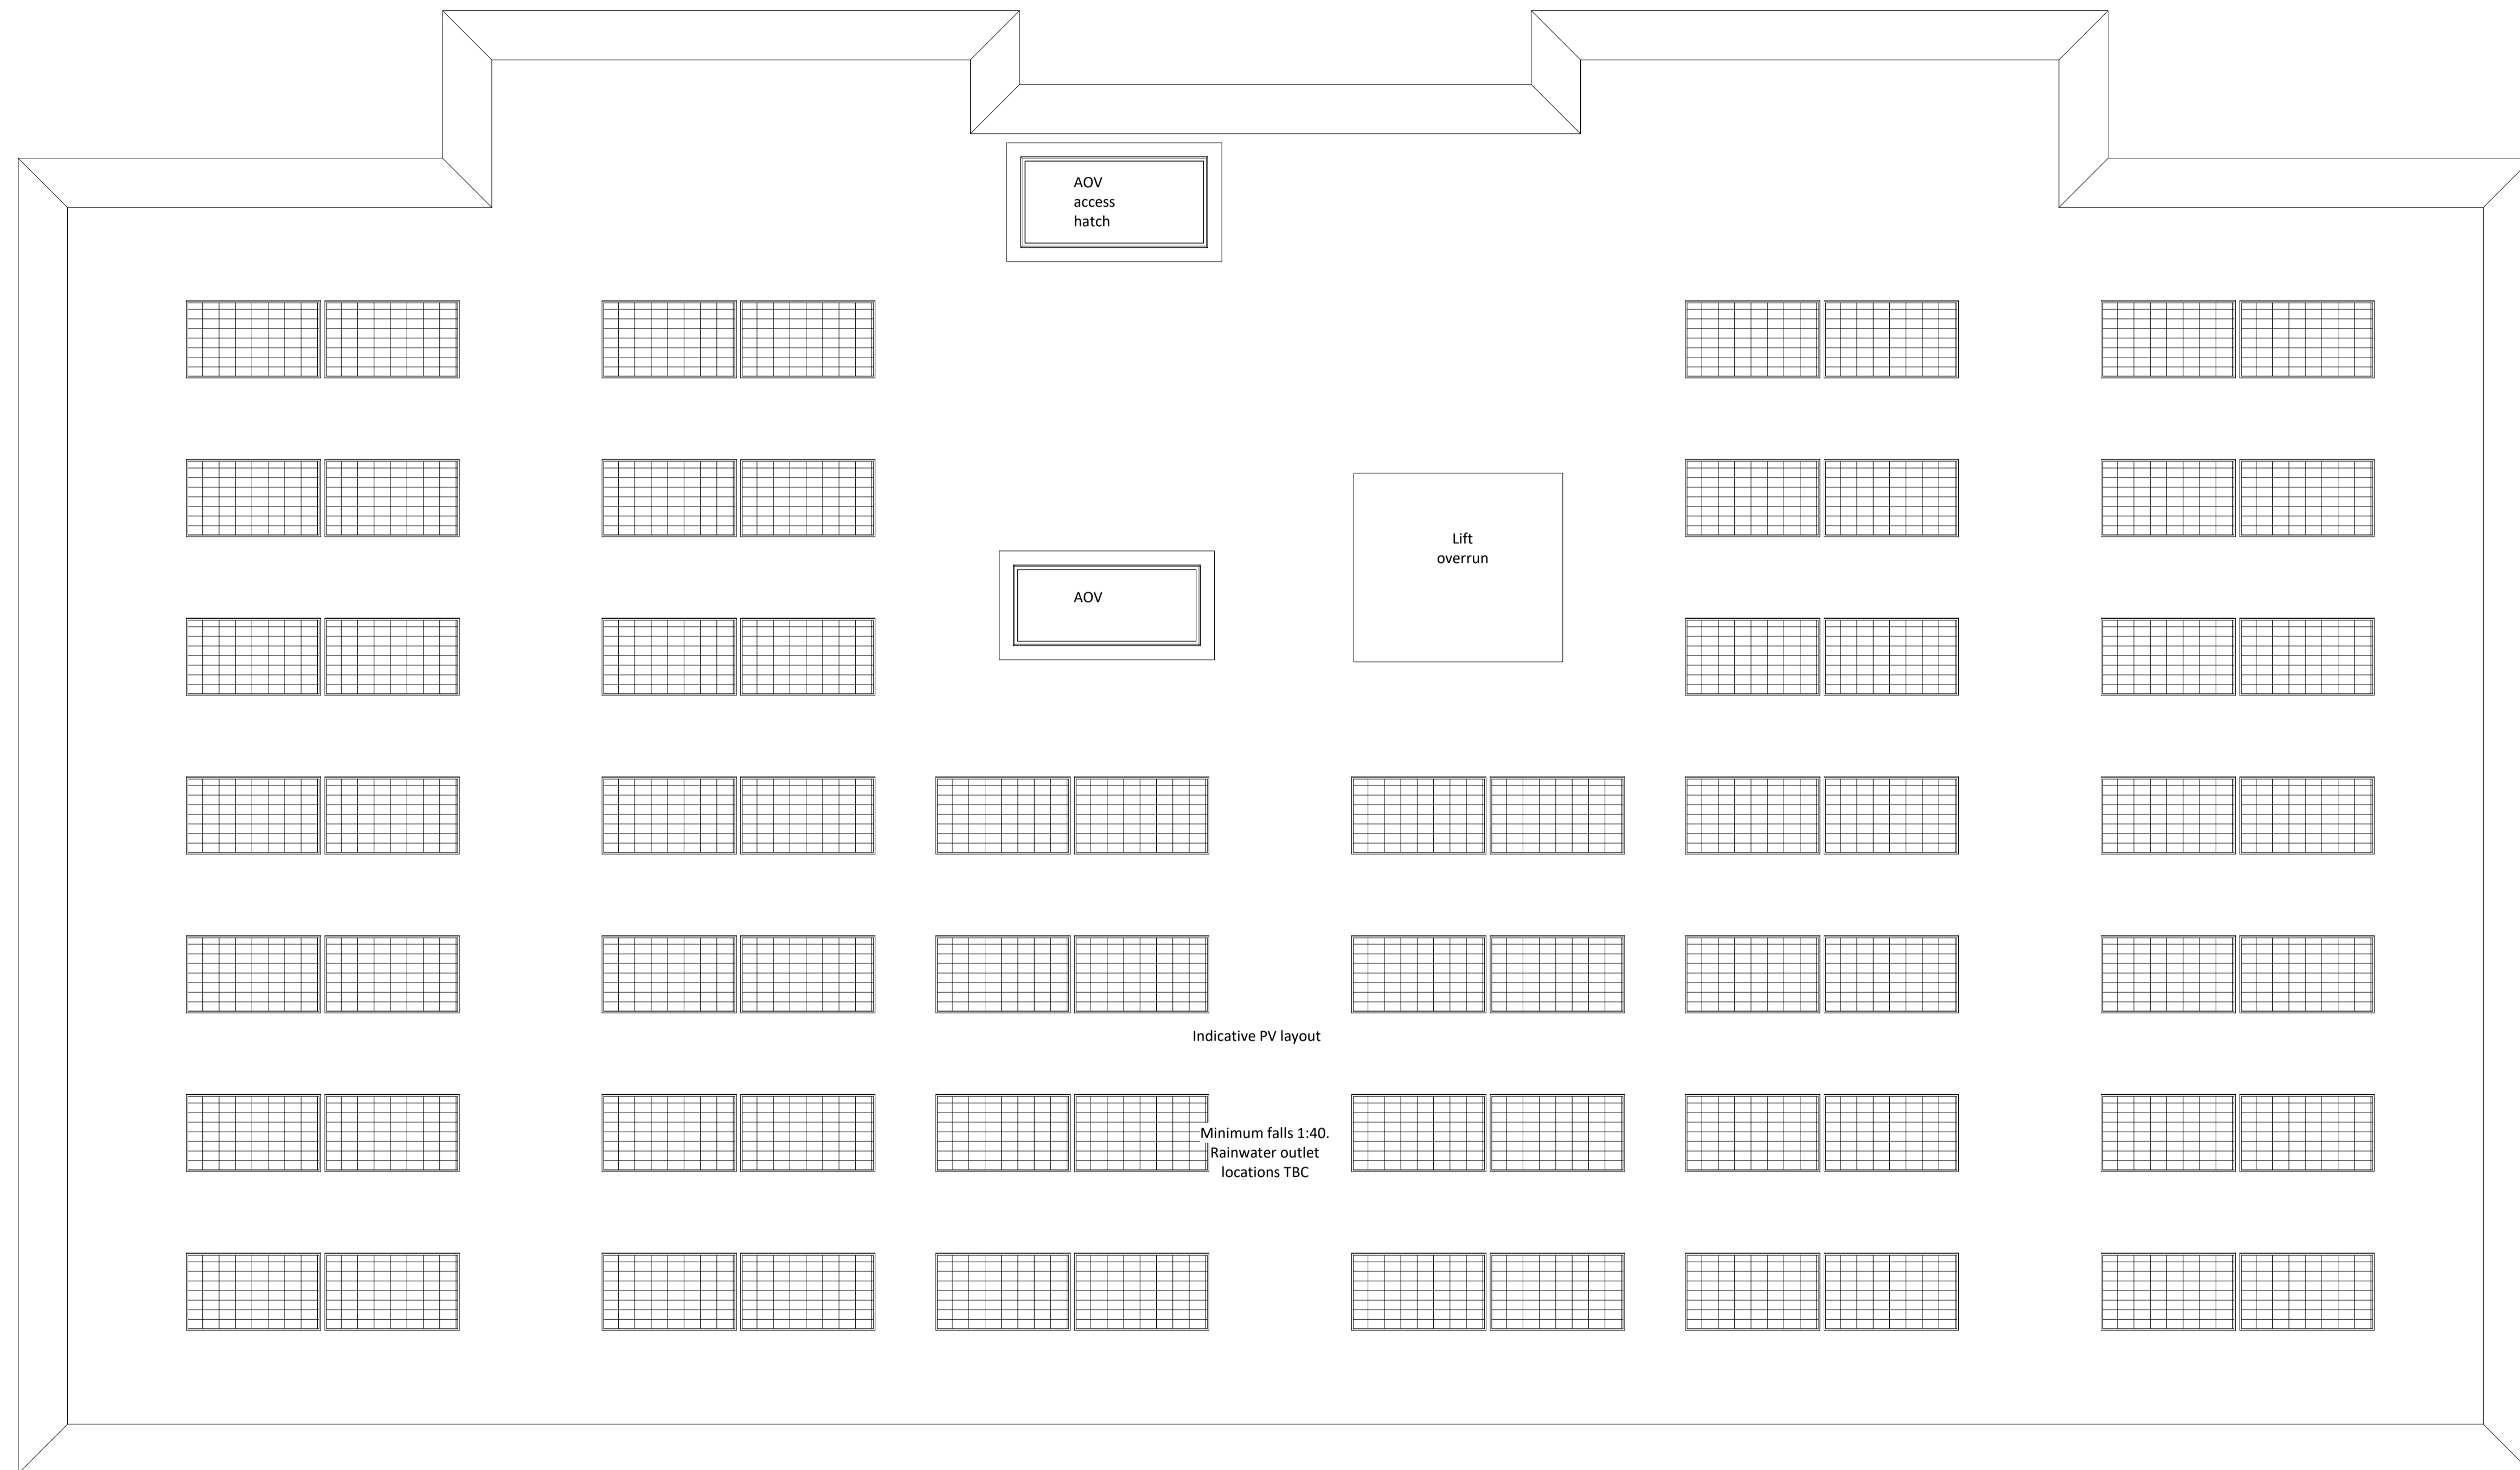

Indicative PV layout

Minimum falls 1:40.
Rainwater outlet
locations TBC

Notes:
Do not scale. All dimensions are in millimetres unless otherwise stated. This drawing should be read in conjunction with all relevant project information and contract documentation. All dimensions to be checked prior to fabrication and or commencement of works. All works to comply with all relevant legal standards, building regulations and warranty provider requirements. Report any discrepancies, if in doubt ask.

Rev	Status	Date	Description	Drn	Chkd
CD1	A3	26.04.22	Planning Issue	JB	CD

Client Name:		Hill Residential	
Project Name:		Ham Close Regeneration	
Drawing Name:		Block D - Roof Plan	
Drawing Number:		HCR-BPTW-B04-04-DR-A-1044	
Project No:	RIBA Stage:	Drawn By:	Scale:
21-090	03	OP	1:50 @ A1

PLANNING ISSUE

40 Norman Road,
Greenwich, London
SE10 9GX
t 020 8293 5175
bptw.co.uk

