
 


LIGHTING LAYOUT
MEZZ FLOOR

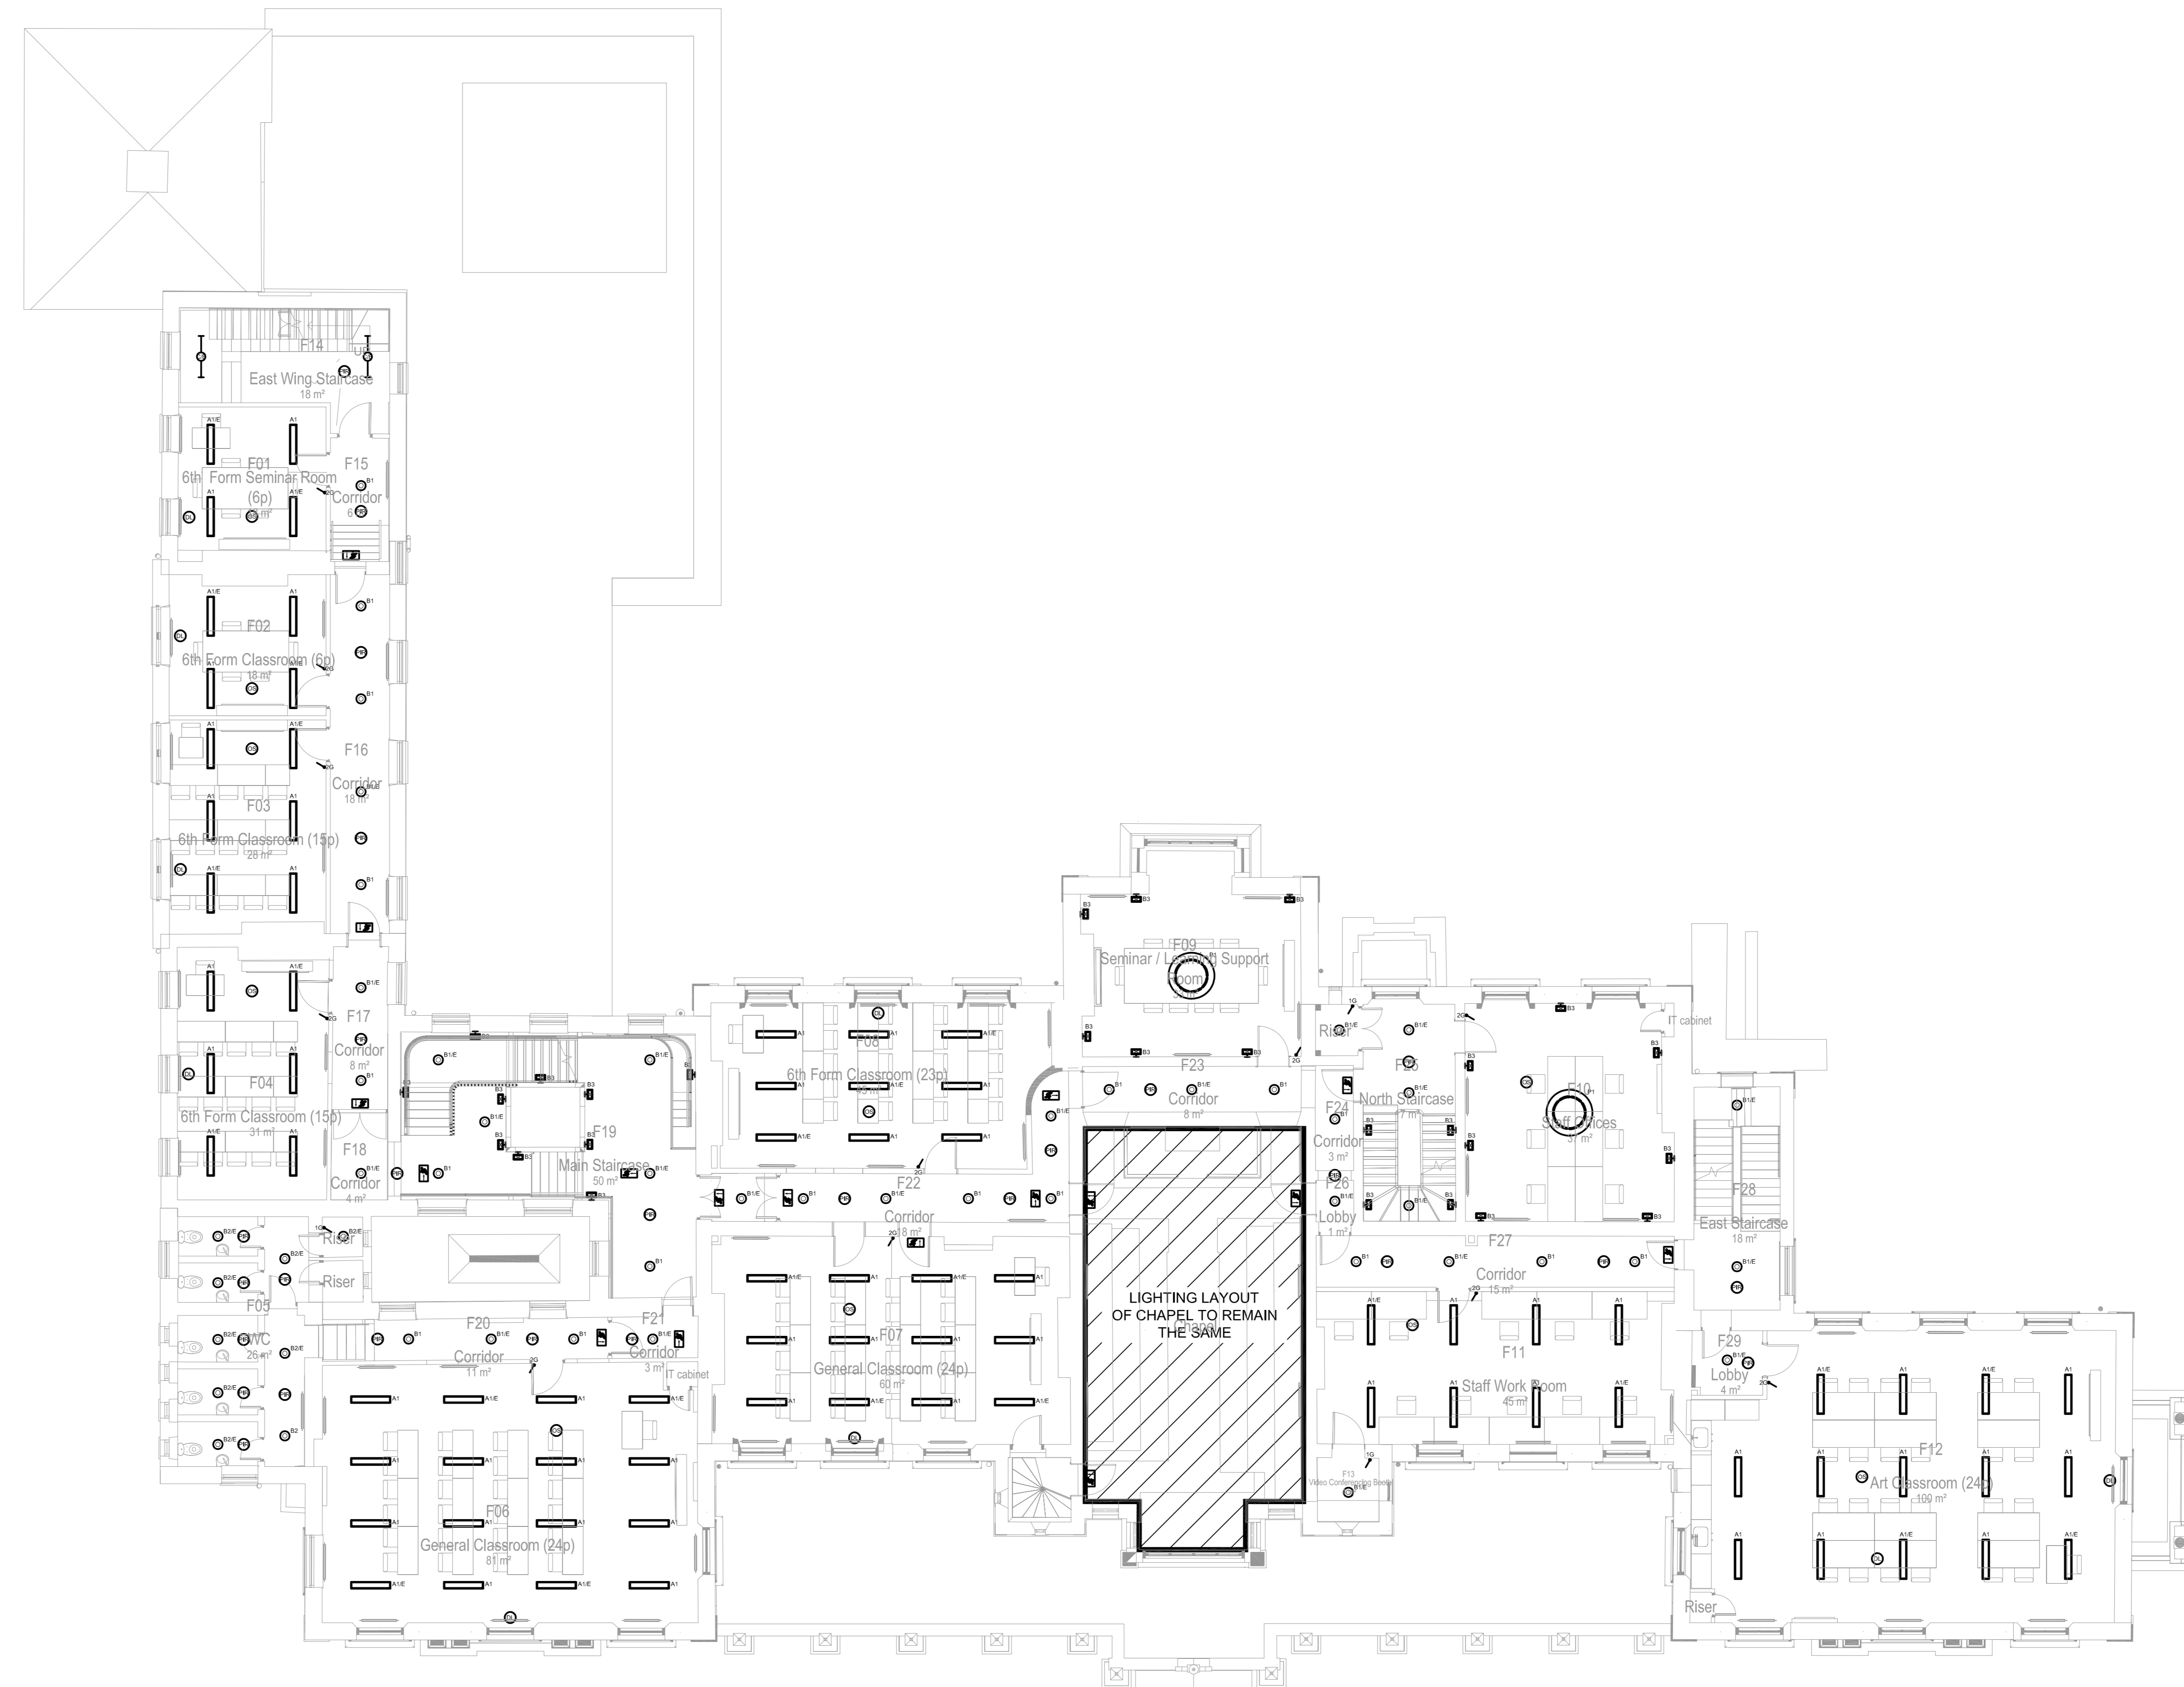

LIGHTING LAYOUT
FIRST FLOOR



STANDARD NOTES

- DO NOT SCALE FROM THIS DRAWING. CONFIRM ALL DIMENSIONS AND STRUCTURAL INFORMATION ON SITE. IF IN DOUBT ASK BEFORE ACTING.
- THIS DRAWING IS TO BE READ IN CONJUNCTION WITH THE APPROPRIATE WB SHIELDS REPORT AND SCHEDULES.

NOTES

- THE ELECTRICAL INSTALLATION SHALL COMPLY WITH BS7671:2018 18TH EDITION.
- THE ARCHITECTURAL BACKGROUND SHOWN IS ONLY FOR REFERENCE. THE CONTRACTOR SHALL REFER TO THE ARCHITECT'S PACKAGE FOR FULL AND FINAL DESIGN OF ALL ARCHITECTURAL ELEMENTS.
- LIGHTING LAYOUT SHOWS DESIGN INTENT ONLY. FINAL QUANTITIES TO BE FINALISED IN STAGE 3

LEGEND

- A1 SURFACE MOUNTED LED PANEL
- A2 SURFACE MOUNTED LED PANEL
- B1 CEILING RECESSED DOWNLIGHT
- B2 CEILING RECESSED DOWNLIGHT
- B3 WALL MOUNTED RECTANGULAR ARCHITECTURAL LUMINAIRE
- B4 CEILING MOUNTED CIRCULAR ARCHITECTURAL LUMINAIRE
- B5 CEILING MOUNTED CIRCULAR ARCHITECTURAL LUMINAIRE
- B6 FEATURE WALL LIGHTING
- C1 CEILING MOUNTED SINGLE LINEAR LUMINAIRE
- C2 WALL MOUNTED SINGLE LINEAR LUMINAIRE
- D1E OUTDOOR IP66 SURFACE MOUNTED LUMINAIRE
- P1 HALO PENDANT
- P2 PENDANT AT CAFE COUNTER
- F1 BALL SHAPED PENDANT
- F2 HIGH BAY
- G1 TRACK LIGHT
- L1 LINEAR LED STRIP
- E DENOTES EMERGENCY LIGHTING
- E1 EMERGENCY EXIT SIGN
- E2 RECESSED NON-MAINTAINED EMERGENCY LUMINAIRE
- PIR PIR SWITCH
- DL DAYLIGHT SENSOR
- OS OCCUPANCY SENSOR
- 2G WALL MOUNTED SWITCH
- 6A PCR / ISOLATION POINT
- LCP LIGHTING CONTROL PANEL
- K LIGHTING CONTROL KEY SWITCH

P3	22/05/22	WC	FOR PLANNING	VS	AG
P2	14/05/22	WC	FOR PLANNING	VS	AG
P1	05/05/22	WC	DRAFT FOR PLANNING	VS	AG
REV	DATE	BY	DESCRIPTION	CHK/APP	

DRAWING STATUS: FOR PLANNING

WB SHIELDS

10 CHANCEL STREET, LONDON, SE1 0UX
TEL: +44 (0)203 764 0801
WWW.WBSHIELDS.COM

WB Shields Ltd is a Limited Company Registered in England and Wales No. 09489732. Registered Office: 20-22 Westbrook Road, London, N1 0JU.

PROJECT: KNELLER HALL FOR PLANNING

TITLE: MAIN BUILDING ELECTRICAL LIGHTING LAYOUT - FIRST FLOOR & MEZZANINE

DESIGNER: WC CHECKED: VS

SCALE: 1:100 @ A0 DRAWN: WC

DRAWING NO: P2389_63_L1_10 REV: P3