



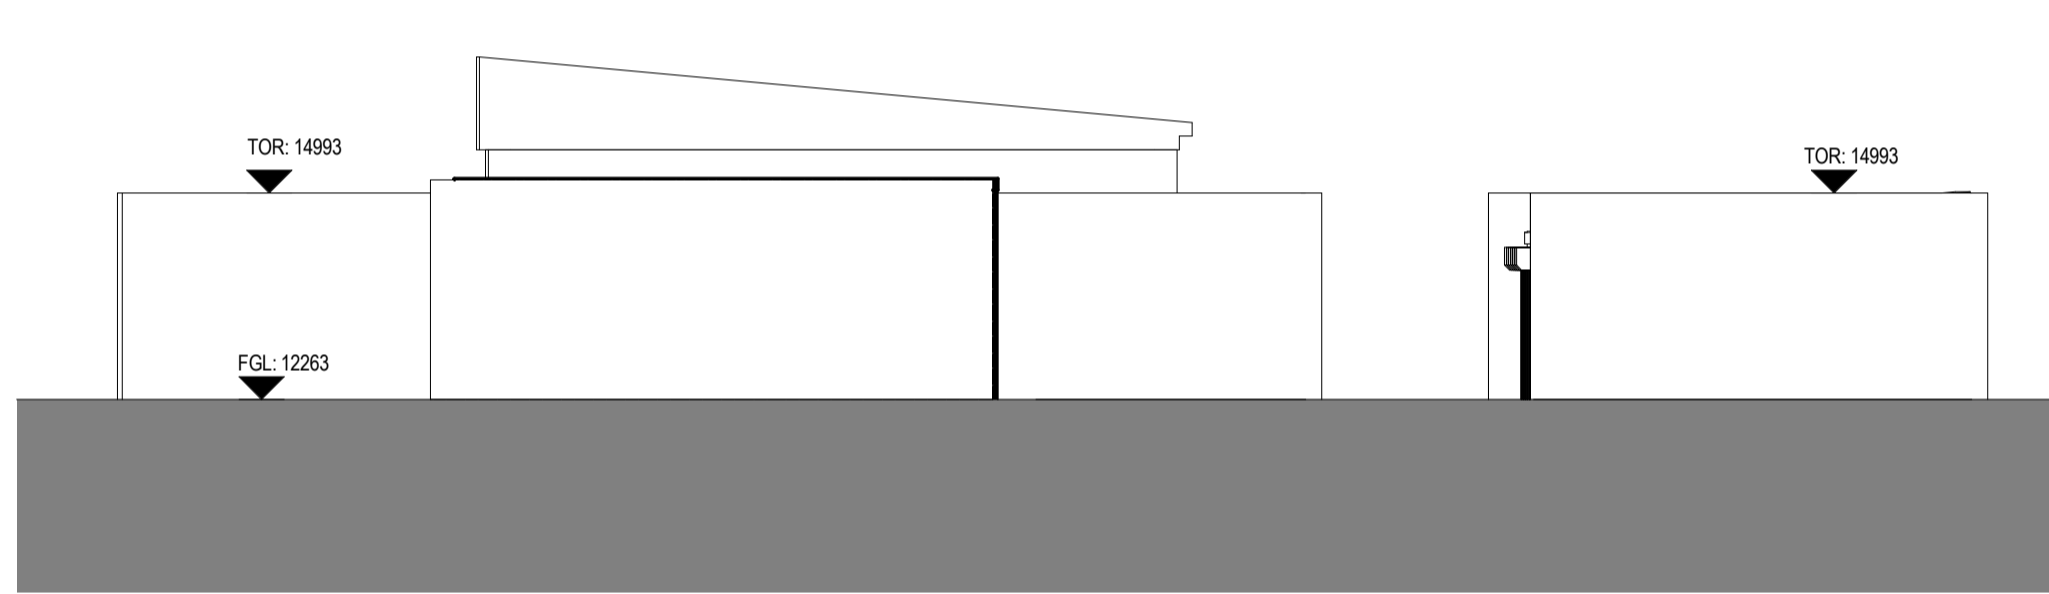



1 EXISTING SOUTH ELEVATION
1 : 100

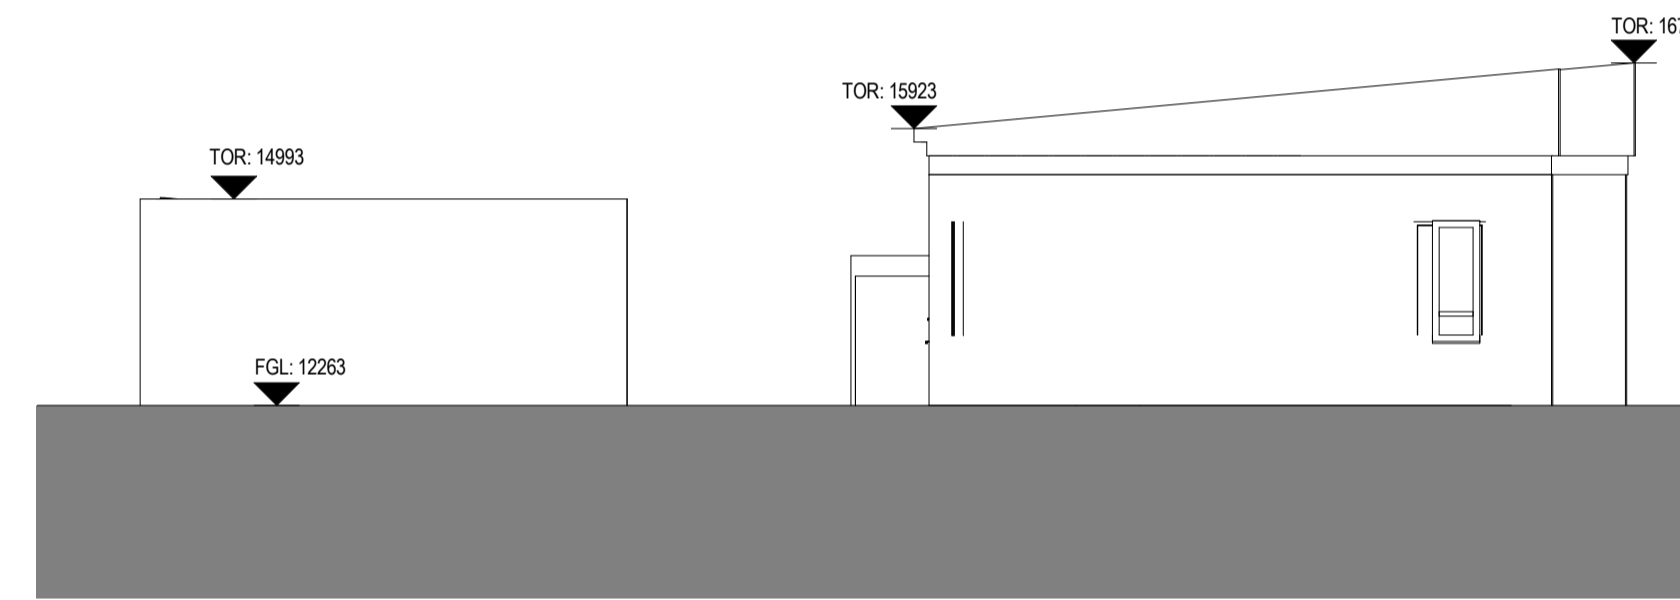

2 EXISTING EAST ELEVATION
1 : 100



4 EXISTING WEST ELEVATION
1 : 100

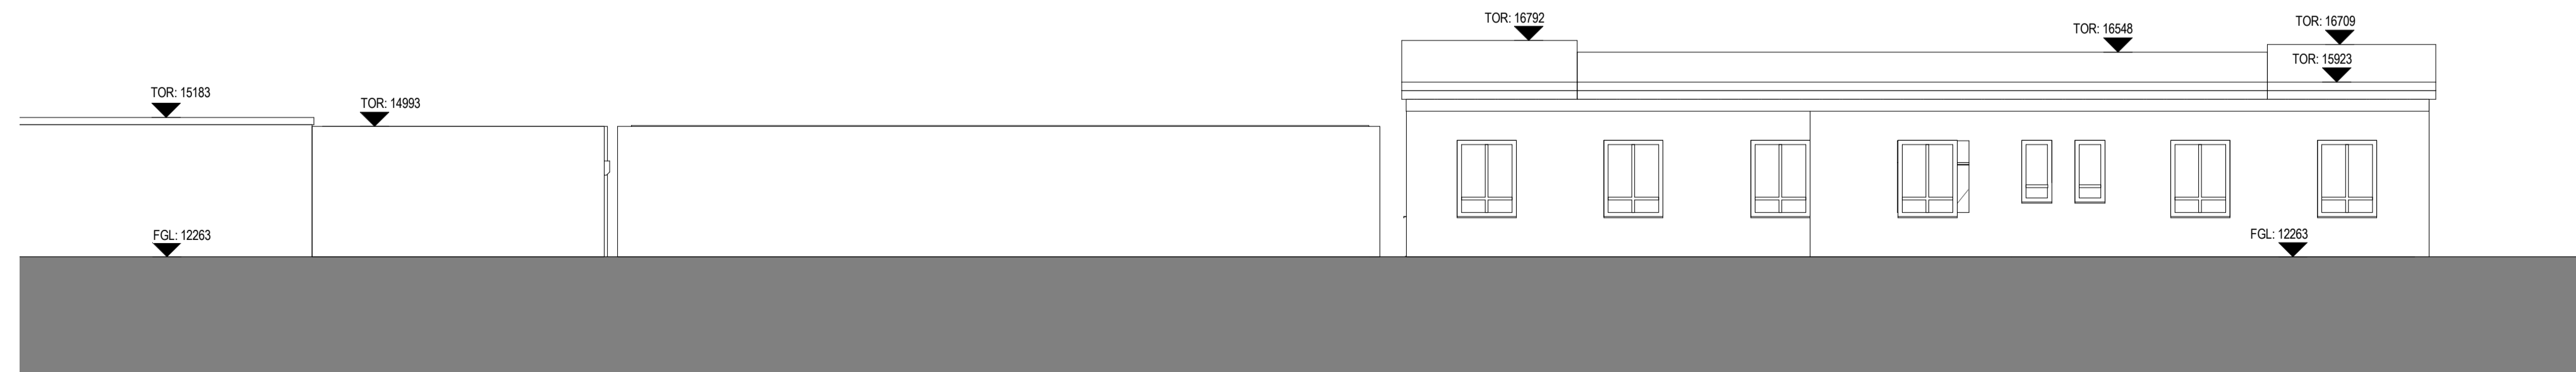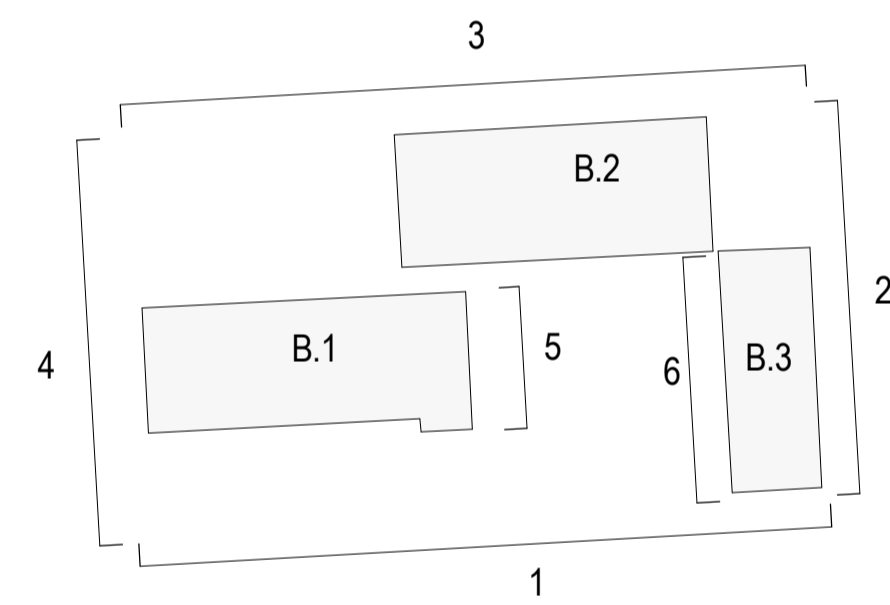

3 EXISTING NORTH ELEVATION
1 : 100

PLANNING

0 5 m			
REVISION	DATE	DESCRIPTION	ARCHITECT PARTNER
S2 P 1	21/09/22	PLANNING SUBMISSION	ADP

CHECK ALL DIMENSIONS AND VERIFY ON SITE. REPORT ANY ERRORS OR OMISSIONS

adp The Fire Station
150 Waterloo Road
London
SE1 8SB
T +44 (0) 20 7089 1720
E london@adp-architecture.com
www.adp-architecture.com

JOB TITLE:
**KNELLER HALL SCHOOL
ENERGY CENTRE**

DRAWING TITLE:
EXISTING ELEVATIONS

SCALE: 1 : 100	DRAWING SHEET SIZE: A1
JOB CODE: 001506	DRAWING NUMBER: ADP-07-XX-DR- A-1200
REVISION: S2 P 1	