


1 ROOF PLAN PLANNING
1 : 100

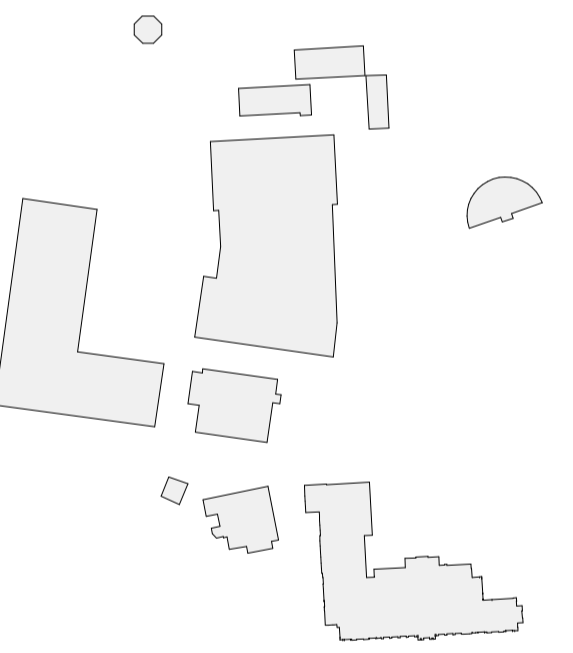

Location Plan

PLANNING

0 5 m

REVISION	DATE	DESCRIPTION	ARCHITECT	PARTNER
S2 P 1	21.09.22	PLANNING SUBMISSION		ADP

CHK ALL DIMENSIONS AND VERIFY ON SITE. REPORT ANY ERRORS OR OMISSIONS

adp The Fire Station
130 Waterloo Road
London
SE1 8SB
T +44 (0) 20 7089 1720
E london@adp-architecture.com
www.adp-architecture.com

JOB TITLE:
**KNELLER HALL
SPORTS PAVILION**

DRAWING TITLE:
PROPOSED ROOF PLAN - PLANNING

SCALE: 1 : 100	DRAWING SHEET SIZE: A1
JOB CODE: 001506	DRAWING NUMBER: ADP-06-R1-DR- A-1005
REVISION: S2 P 1	