

THIS DRAWING HAS BEEN DEVELOPED FROM THE FOLLOWING DESIGN DRAWINGS

THIS DRAWING REFERS TO THE FOLLOWING XREF FILES  
XB\_S4.DWG

NOTES  
1 THIS DRAWING TO BE READ IN CONJUNCTION WITH THE PROJECT SPECIFIC M&E SPECIFICATIONS, THE PROJECT SPECIFIC DESIGNERS RISK ASSESSMENTS

LEGEND

- X1 THORLOX 'STARBEAM' 3W 4000K LED LUMINAIRE / LW ROADWAY LIGHT DISTRIBUTION MOUNTED ON LM COLUMN
- X2 THORLOX 'STARBEAM' 3W 4000K LED LUMINAIRE / LW AREA LIGHT DISTRIBUTION MOUNTED ON LM COLUMN
- ▼ B1 EXTRA LIGHTING AVAILTY EXTERIOR LED / LW WALL MOUNTED LUMINAIRE
- A1 EXTERNAL LIGHTING COLUMN / LW WINDSOR PHAROLA, DARK SIKES 26W




X1 & X2



B1



A1

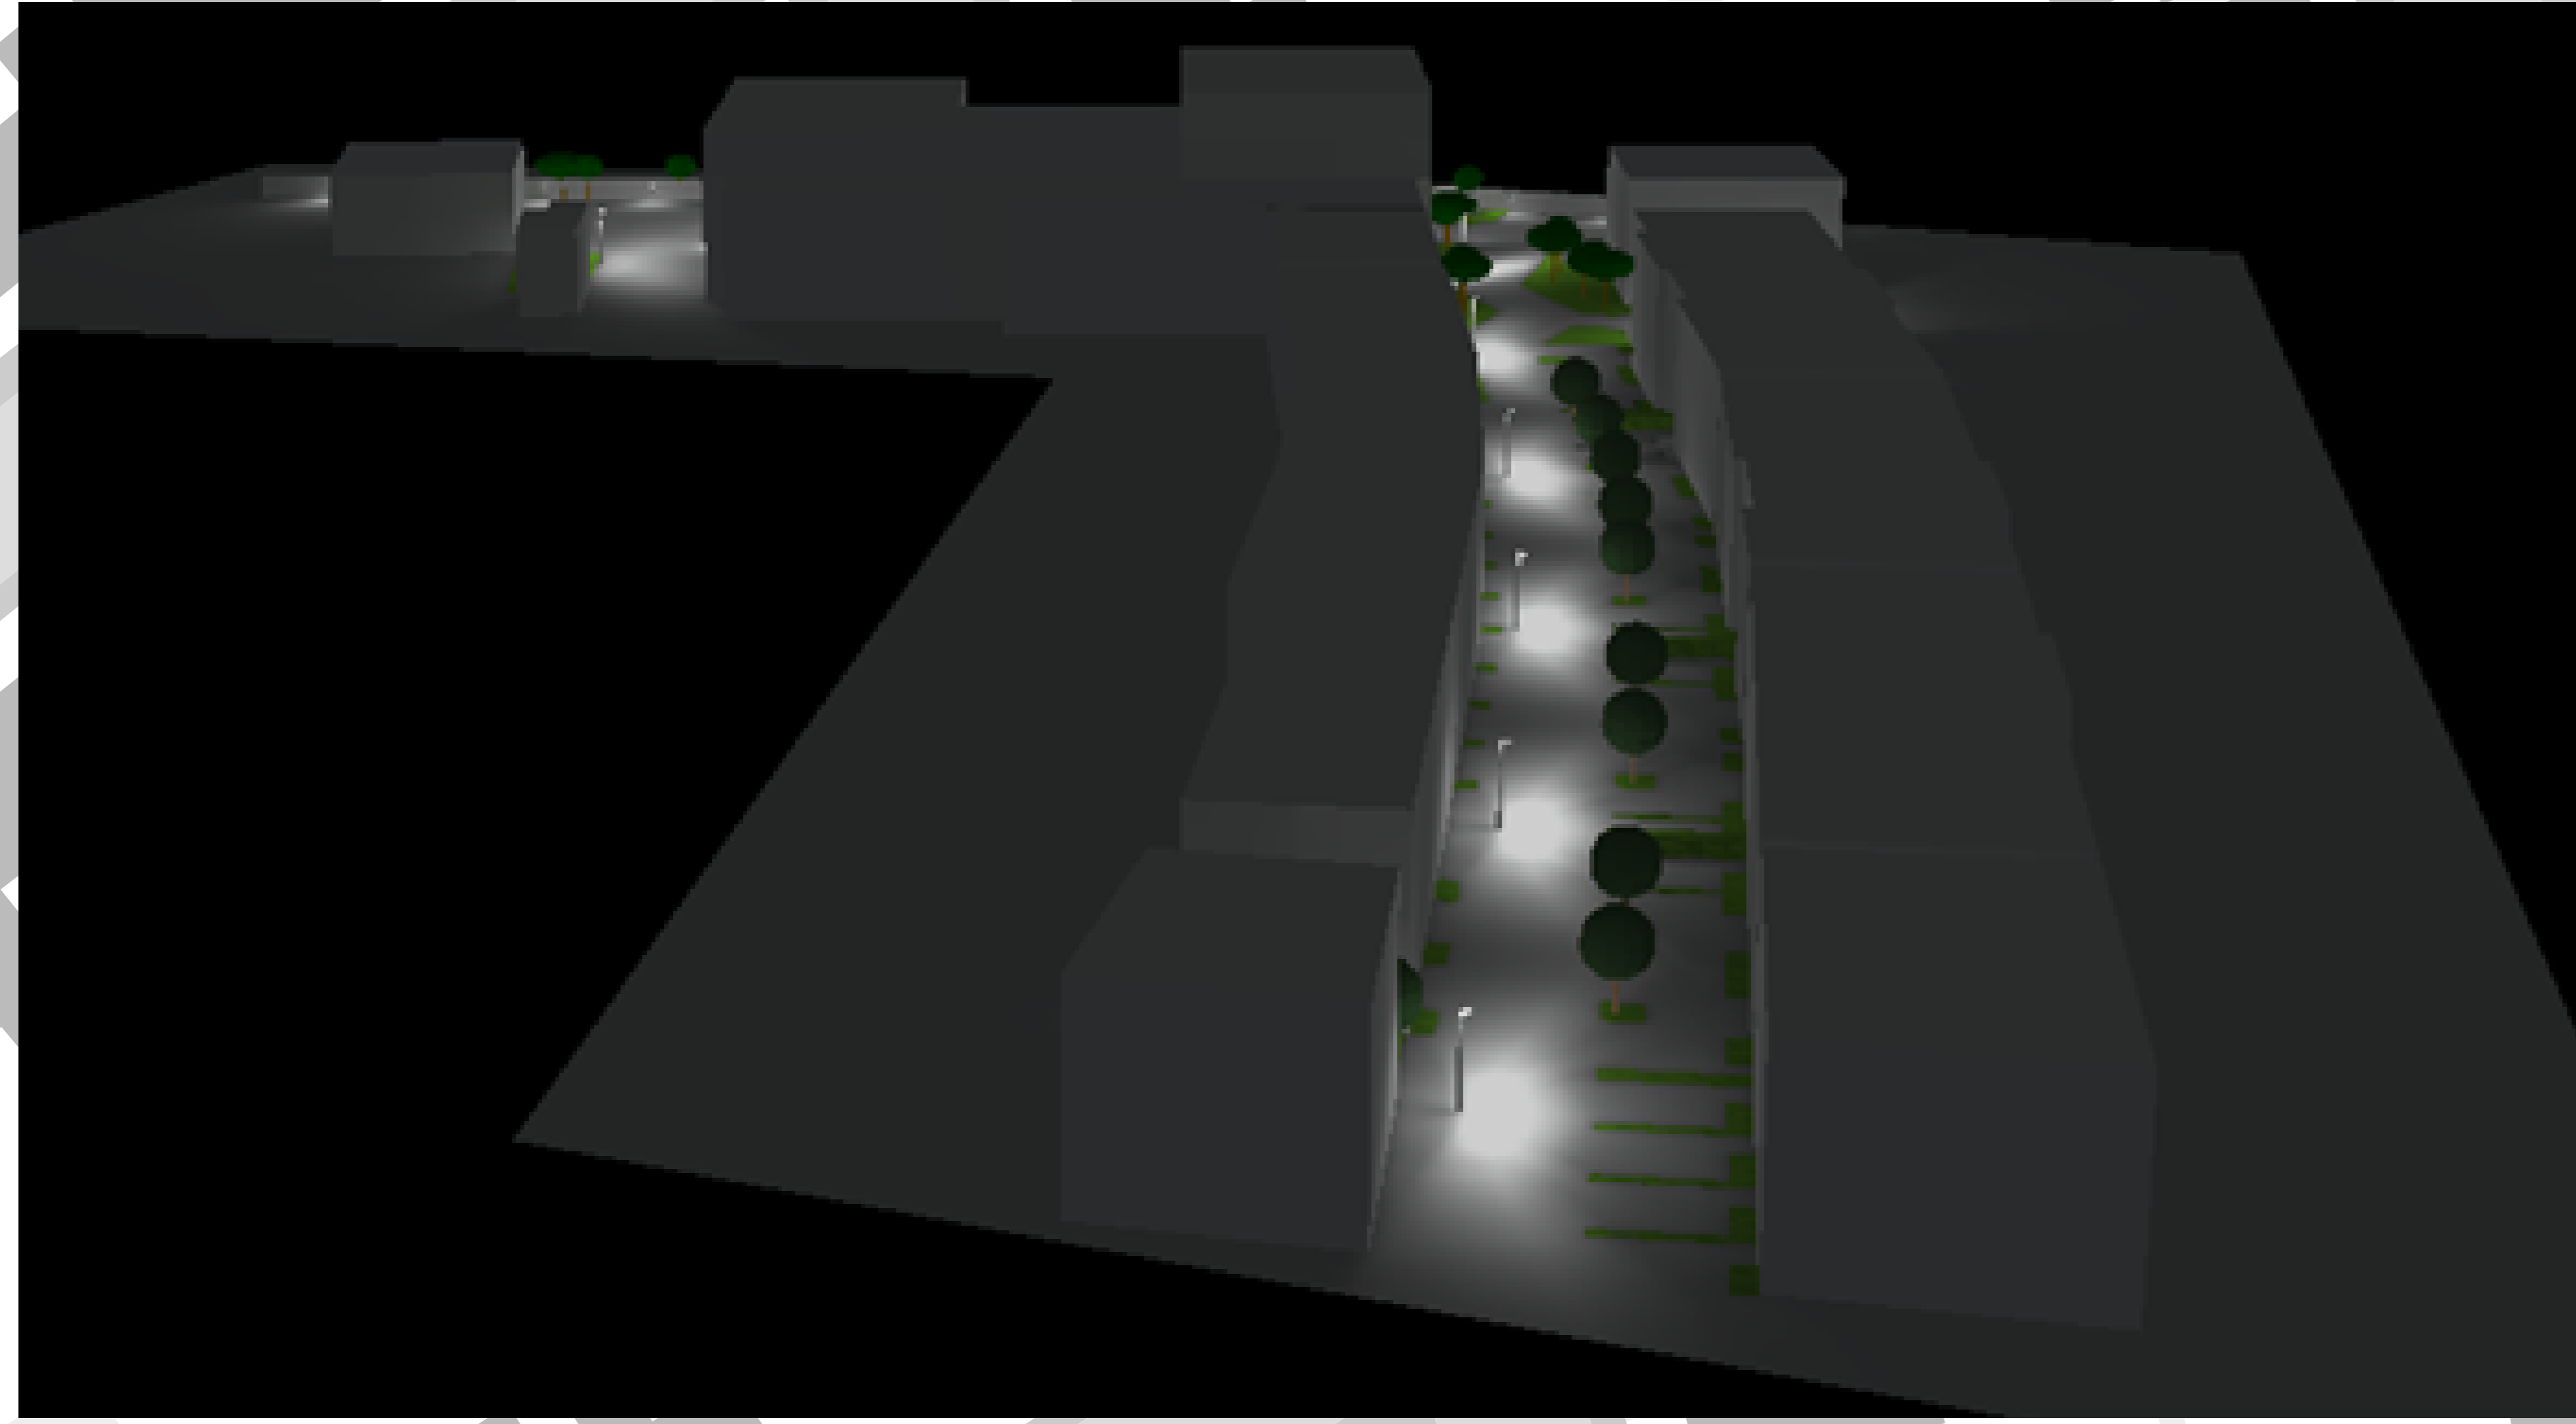

02	29/11/22	JA	FOR PLANNING	JC
01	31/01/19	JA	FOR PLANNING	JC
REV	DATE	BY	DESCRIPTION	CHK/APP

**desco**  
desco (design & consultancy) ltd  
AMP House, 6th Floor  
Dringwall Road  
East Croydon, CR0 2LX  
Tel: 0208 6865583  
E-Mail: drawings@desco.uk.com

DRAWING STATUS	PLANNING	SCALE	1:250	NO	A0
----------------	----------	-------	-------	----	----

PROJECT  
LONDON SQUARE

ARCHITECT  
ASSAEL

CLIENT  
GREGGS BAKERY SITE  
TWICKENHAM

SERVICE  
ELECTRICAL SERVICES  
EXTERNAL LIGHTING LAYOUT  
RESIDENTIAL LED SCHEME

DRAWING NUMBER	1823-S-63-LAY-01	NO	02
----------------	------------------	----	----