

- ⊕ MAINS WIRED INTERLINKED SMOKE DETECTOR
- ⊗ MAINS WIRED INTERLINKED HEAT DETECTOR

A	SIDE ELEVATION REDUCED	MAY 2023
	REVISED	




0 0.5 1.0 2.0 3.0 M
SCALE (M)

REDMOND IVIE ARCHITECTS
 THE BARLEY MOW CENTRE
 10 EARLEY MOW PASSAGE
 LONDON W4 4PH
 tel 020 8742 1775 / 020 8996 1686
 e-mail info@redmondvie.com
 www.redmondvie.com

EXTENSIONS TO 129 STAINES ROAD TWICKENHAM	
PROPOSED GROUND FLOOR PLAN FIRE STRATEGY	
SCALE: 1:50 @ A3	DATE: SEPT. 2022
DRAWN: RCE	1187/010

DO NOT SCALE FOR CONSTRUCTION
 VERIFY ALL DIMENSIONS ON SITE

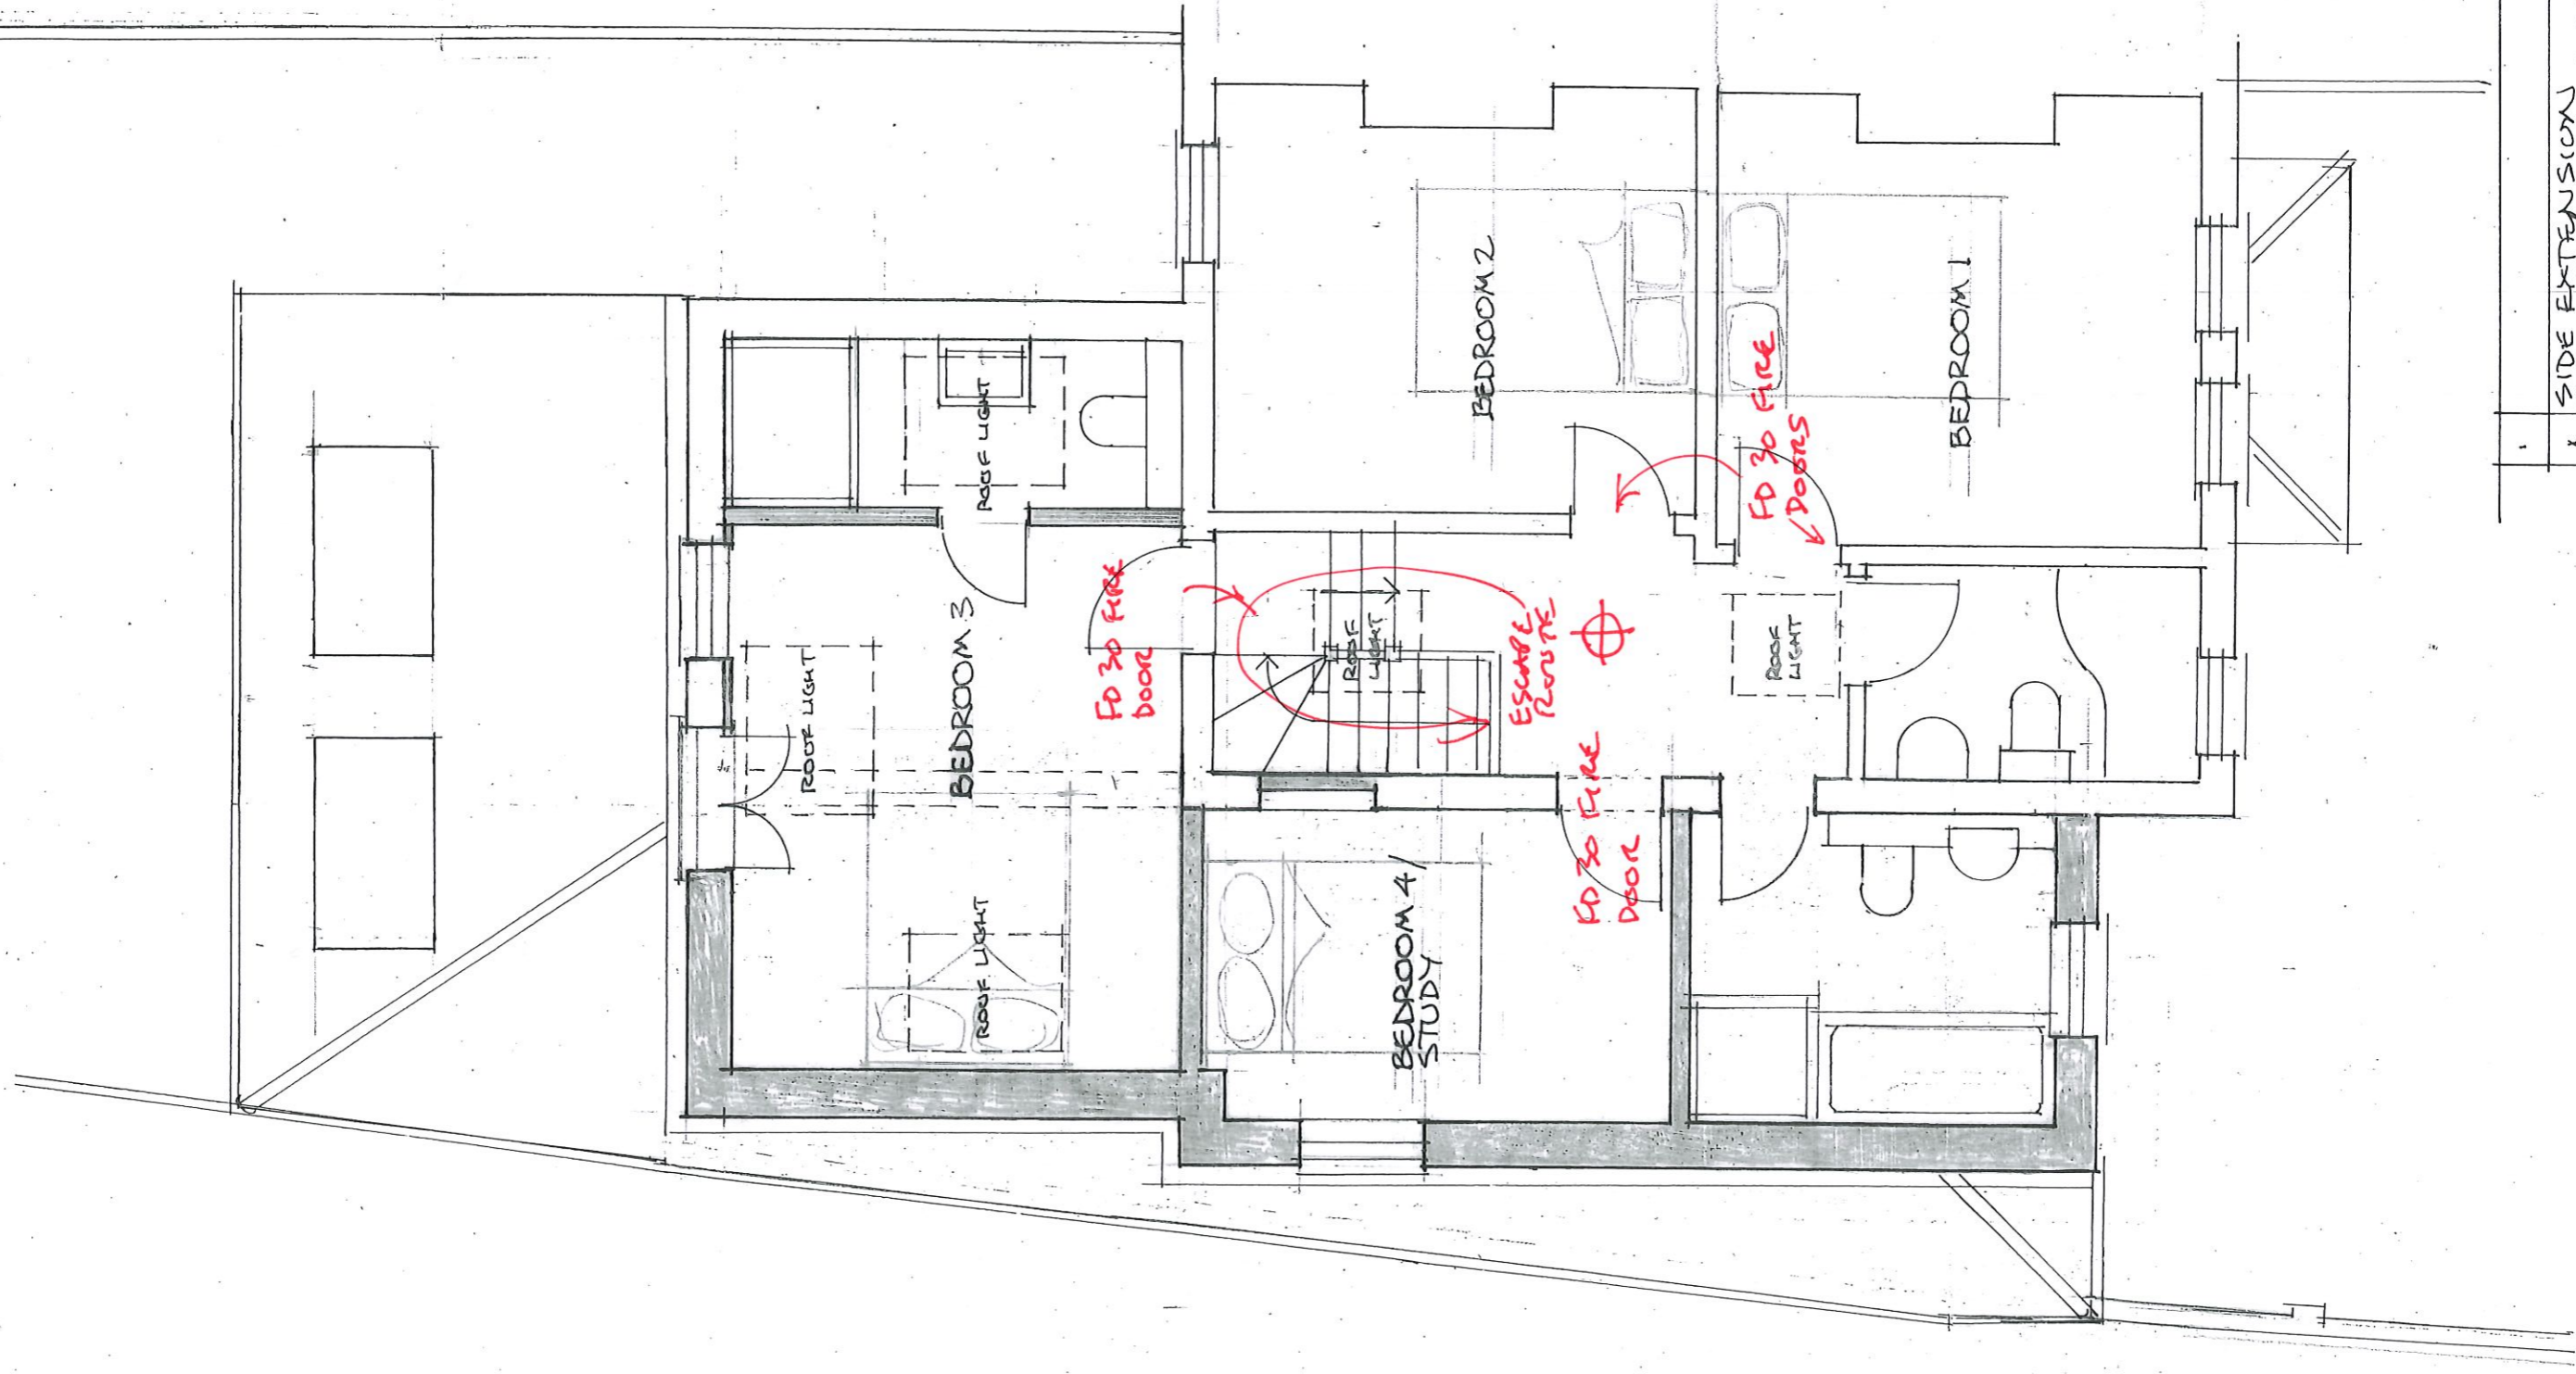

0 0.5 1.0 2.0 3.0 M.
SCALE (M.)

REDMOND IVIE ARCHITECTS
 THE BARLEY MOW CENTRE
 10 BARLEY MOW PASSAGE
 LONDON W4 4PH
 tel 020 8742 1775 / 020 8996 1686
 e-mail info@redmondjvie.com
 www.redmondjvie.com

**EXTENSIONS TO
 129 STAINES ROAD
 TWICKENHAM**

**PROPOSED FIRST
 FLOOR PLAN** FIRE STRATEGY

SCALE: 1:50 @ A3
 DATE: SEPT. 2022
 DRAWN: RCI
 1137/080

NO.	REVISIONS	DATE
A	SIDE EXTENSIONS REDUCED	MAY 2023

DO NOT SCALE FOR CONSTRUCTION
 VERIFY ALL DIMENSIONS ON SITE