


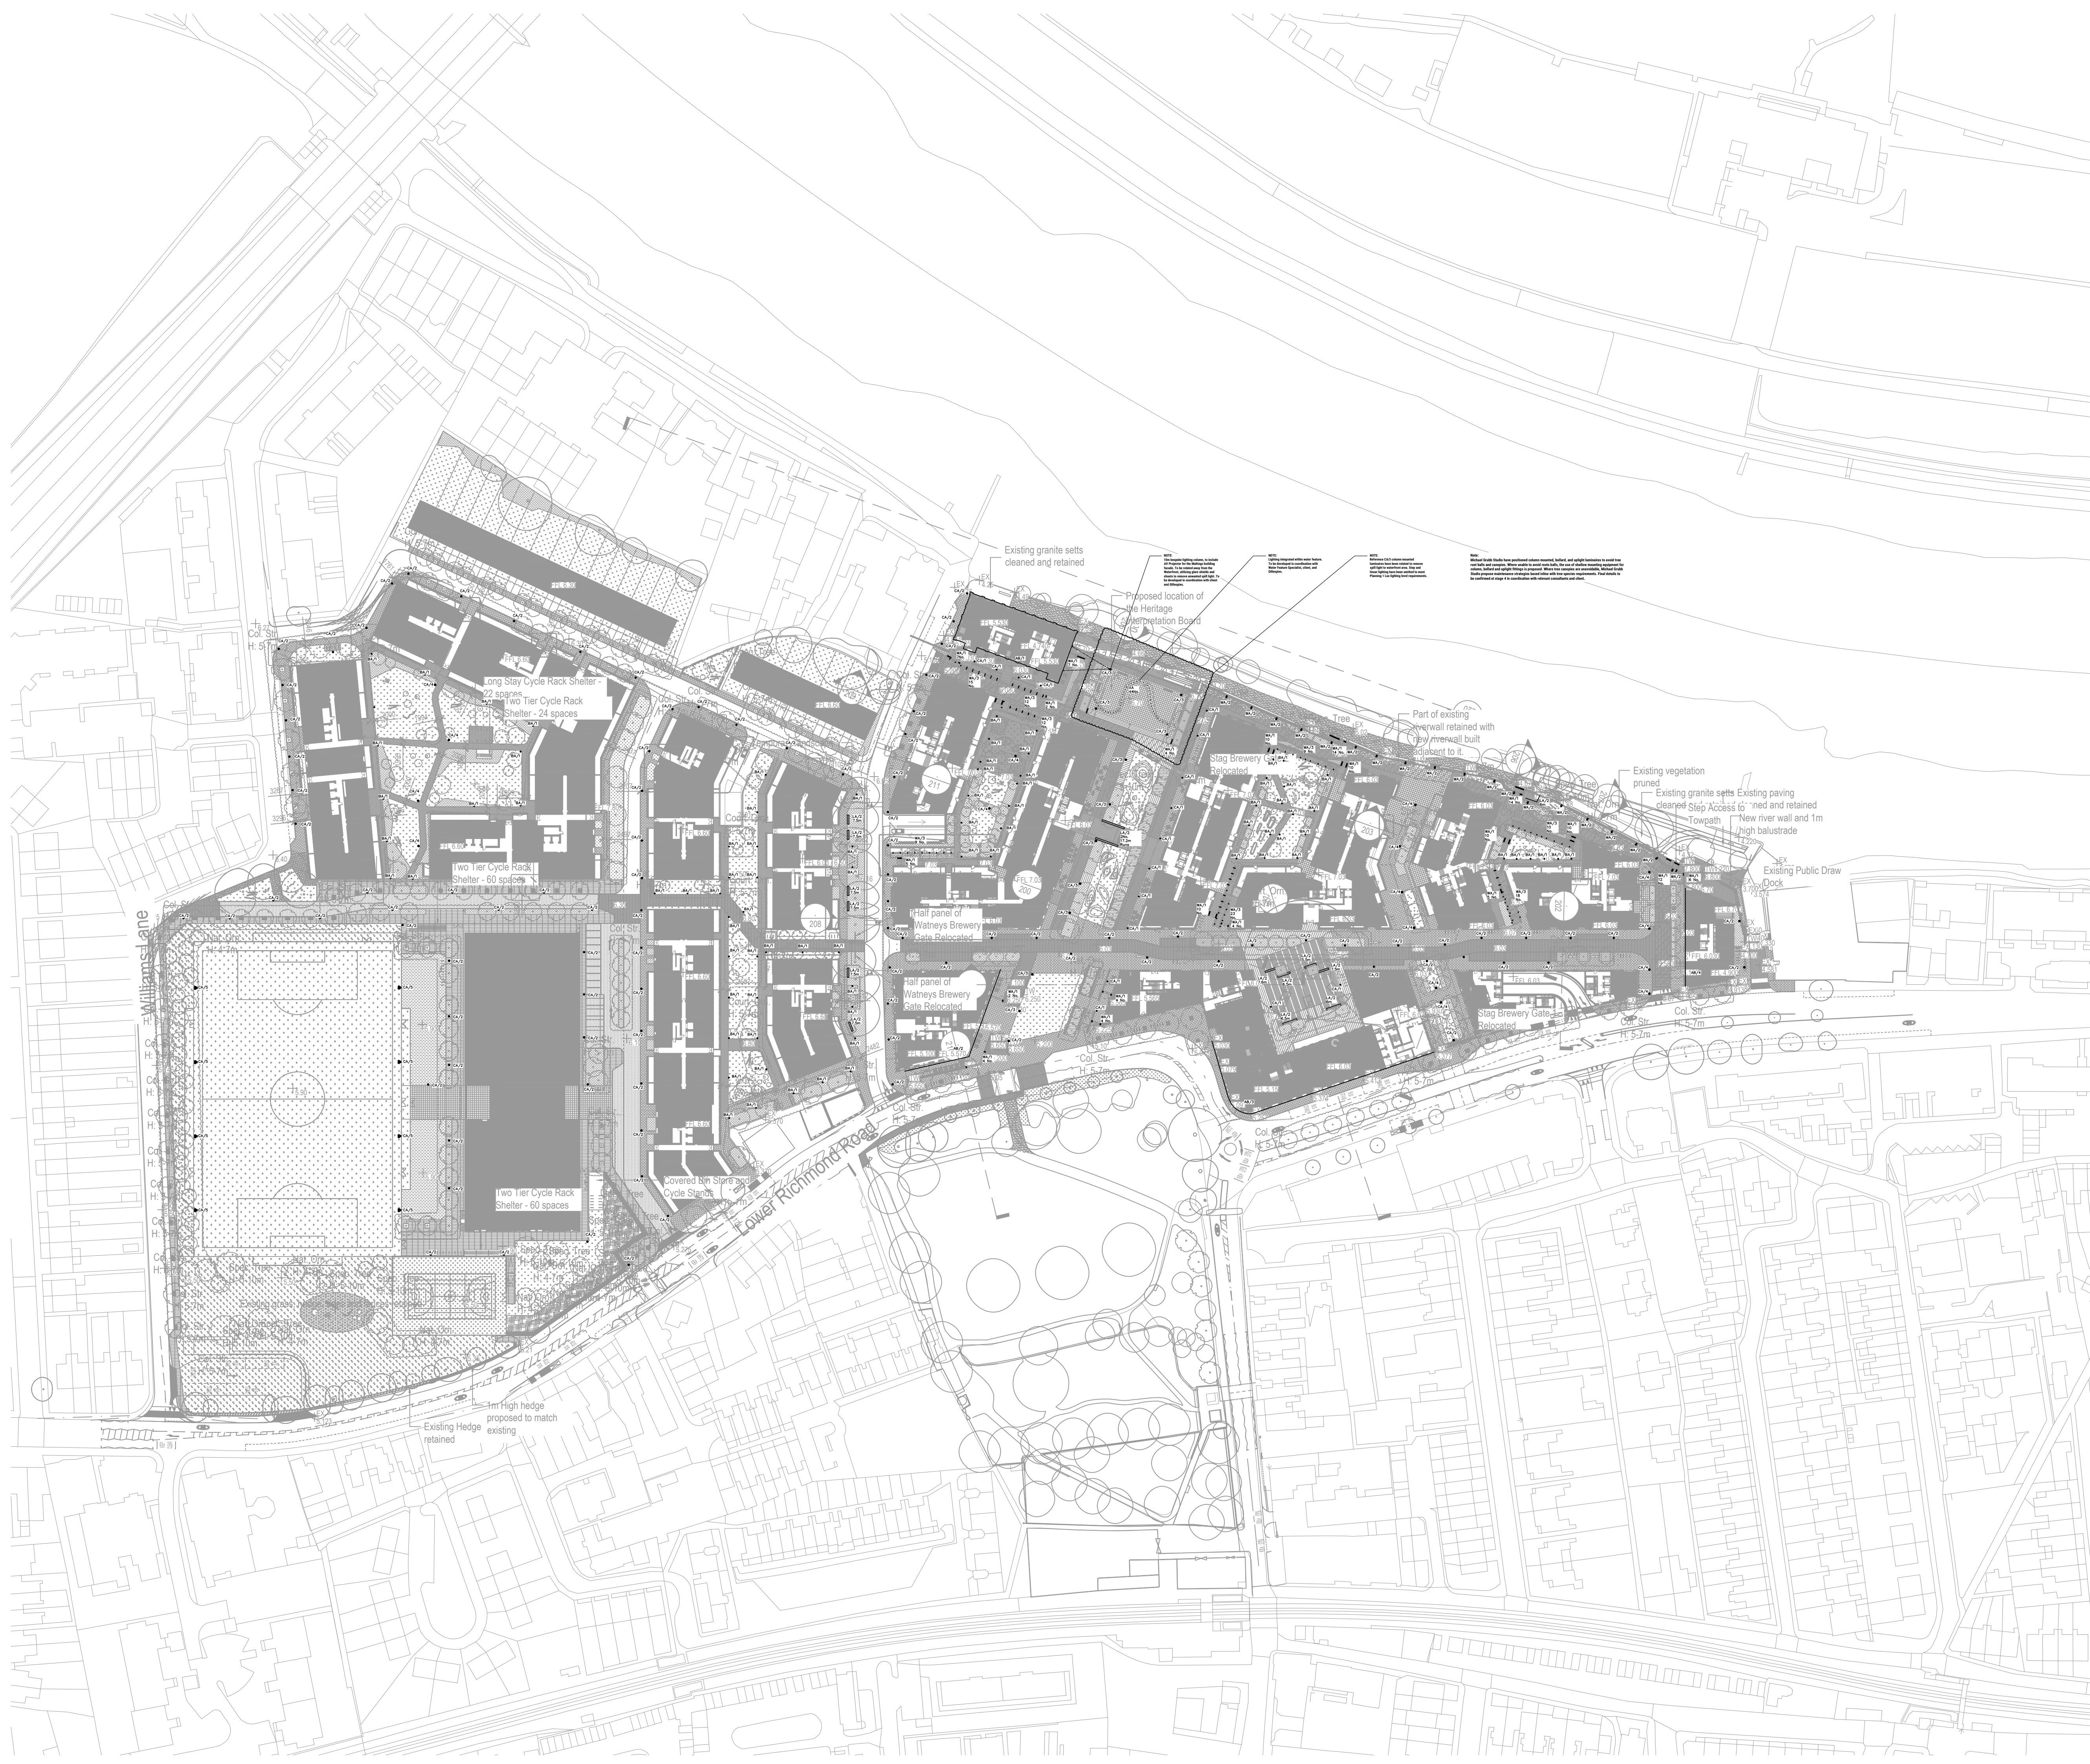

Project of drawing

Information Only

Drawing information:

1. Do not scale from this drawing.

2. This drawing should be read in conjunction with the current set of luminaire specification sheets.

3. Exact luminaire locations will be confirmed prior to the commencement of works on site.

4. The number located within each reference represents the count of units only. This may not be the same as the actual wiring circuit.

5. If in doubt, AS/NZS

Key:

CA/1 - 4 metre high lighting column

CA/2 - 6 metre high lighting column

CA/3 - 10 metre bespoke lighting mast, with spotlights, gobo projectors, WIFI, CCTV and banners.

CA/4 - 6 metre bespoke lighting mast, with spotlights.

CA/5 - 15 metre high lighting column.

BA/1 - 1 metre tall bollard.

XA - Recessed inground uplights to water feature.

AB/1-4 - Architectural lighting.

LA/2 - Bench integrated linear lighting.

LA/3 - Recessed step seating linear lighting.

WA/1 - Recessed step luminaires.

WA/2 - Recessed wall luminaires.

WA/3 - Recessed Wall (Ramp) luminaires.

Site Ownership Boundary.

Site Planning Application Boundary.

School Application Boundary.

Area Revision.

Scale:

0 5 10 15

0 5 10 15

Revisions:

A - 14.07.2022

B - 19.07.2022

C - 20.07.2022

D - 27.01.2023

E - 25.10.2023

F - 31.10.2023

G - 07.11.2023

Project:

Stag Brewery

Drawing:

Full Site, Planning Lighting Arrangement

Client:

Resellon Properties Ltd

Scale:

1:1000 on A1

Drawn:

DR

Checked:

MG

Date:

7th November 2023

Drawing reference:

547-(005)-DR-EX-MP

Rev:

michael grubb studio

LIGHT. LIGHTING. ILLUMINATION.