


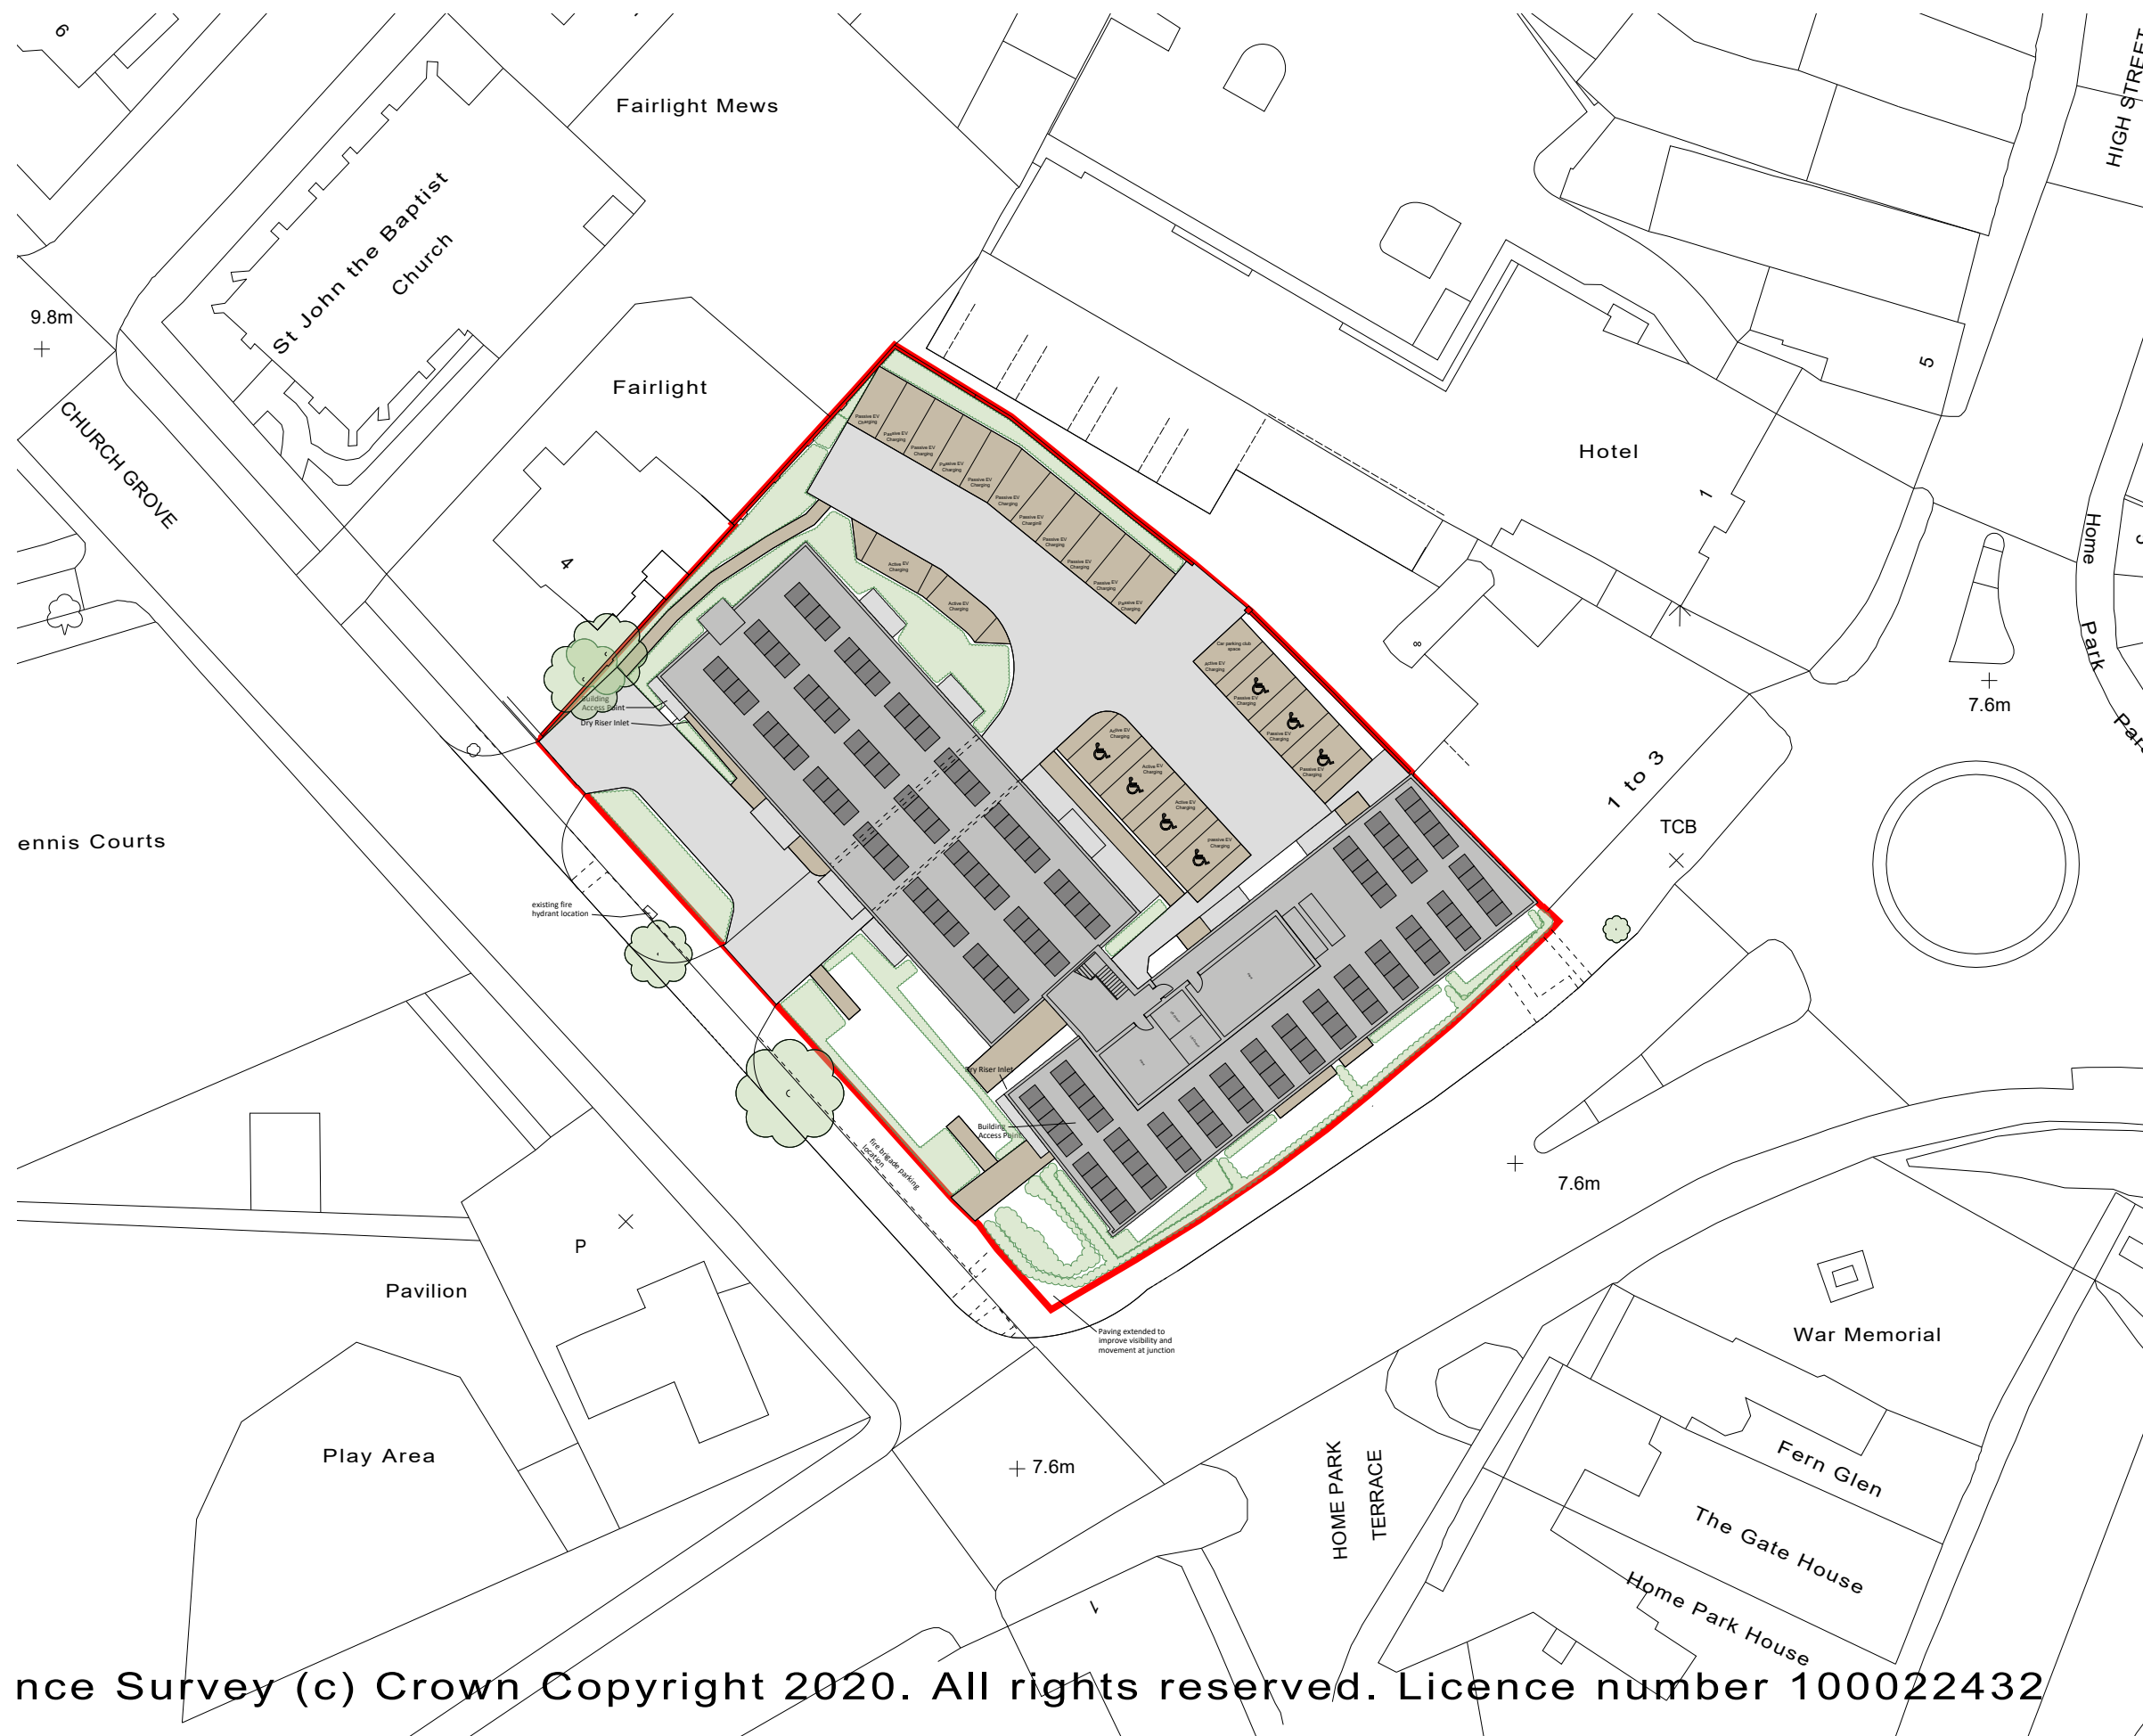

Rev	Date	Description

 


FLUENT
ARCHITECTURAL DESIGN SERVICES

69-71 WINDMILL ROAD, SUNBURY,
MIDDLESEX, TW16 7DT
TEL: 0800 0438838
E-MAIL: INFO@FLUENT-ADS.CO.UK
WEB: FLUENT-ADS.CO.UK

Kingston Bridge House
Church Grove, Hampton Wick

Proposed Site Plan



Scale 1:500 @ A3	Dwg No. FLU.1191.3.10
Date 07.10.20	Rev S
Drawn N.Millin	