



YEW HEDGE



SHRUBS



SMALL TREE



BRICK EDGED PERMEABLE RESIN BOUND GRAVEL




SEDUM ROOF



STEPPED PLANTERS



BLACK STAINED TIMBER

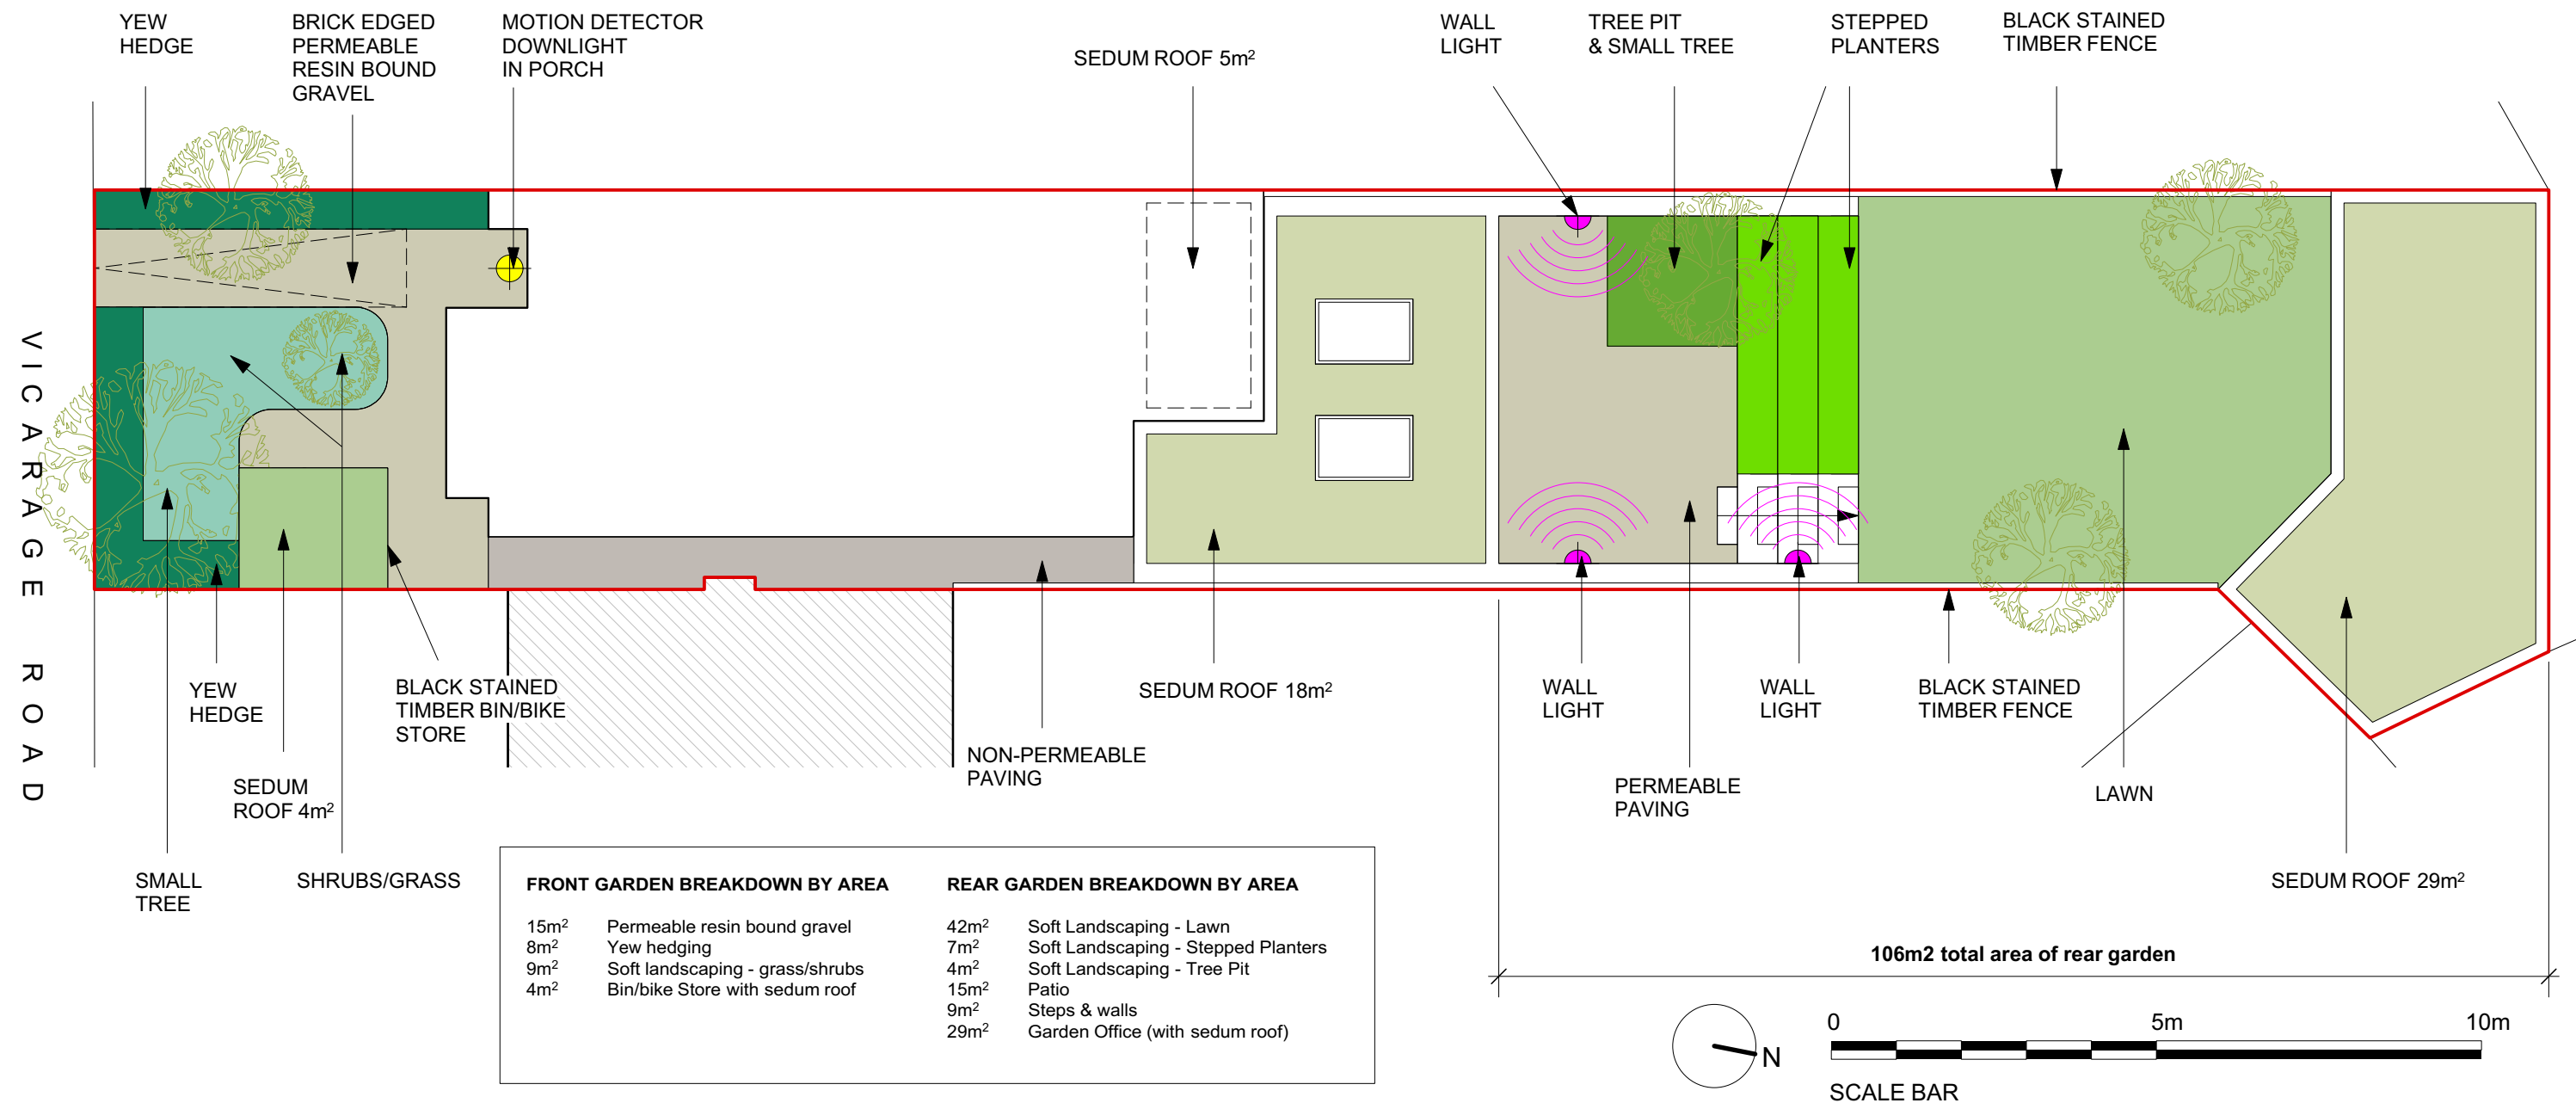

Revisions
25.10.22 - REV-A - Removal of fully glazed roof to lower ground floor projection. Green roof extended over flat roof of lower ground floor projection
01.11.23 - REV-B - Bike store relocated to front garden. Green roof to bin/bike store. Amended landscaping area breakdowns.

Copyright ADD/UK Limited
 No implied license exists. Do not scale this drawing. All dimensions to be checked on site by the contractor and such dimensions to be their responsibility. All work must comply with relevant British Standards and Building Regulations requirements. Drawing errors and omissions to be reported to the architect.

Scale 1:100 @ A3	Date October 2021
Drawn by SD	Checked by DW
Job Number 0075	Status PLANNING

Project LAND BETWEEN 18 & 20 VICARAGE ROAD, KT1 4ED
Drawing Proposed Landscape & Lighting Plan

add
 architecture development + design

Drawing No. & Revision
 0075_P15B