


GROUND FLOOR PLAN

 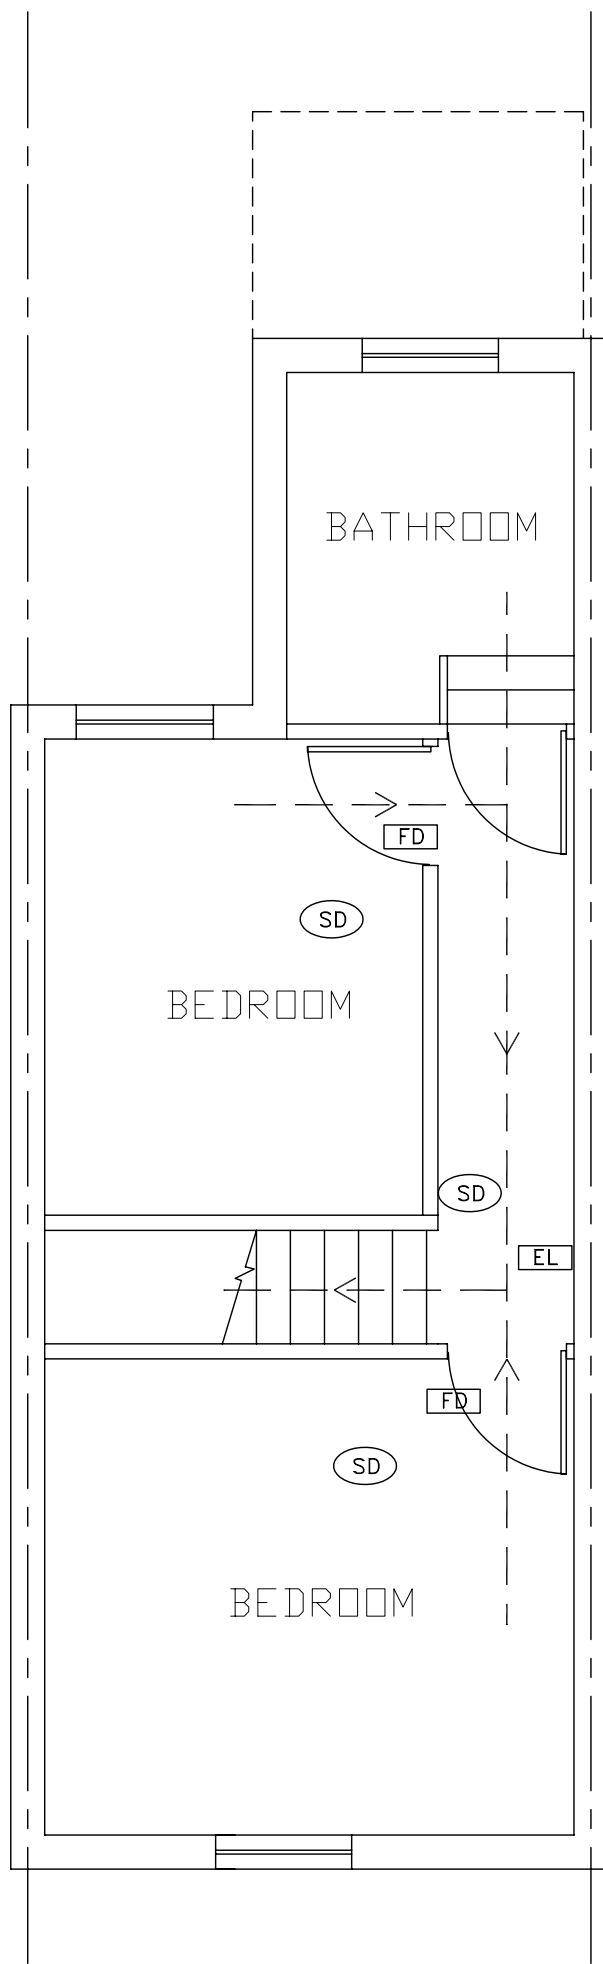


FIRST FLOOR PLAN

KEY

- SD SD- SMOKE DETECTOR
- HD HD- HEAT DETECTOR
- EL EL- EMERGENCY LIGHT
- FB FB- FIRE BLANKIT
- FD FD30- FIRE DOORS
- SS SS- SPRINKLER SYSTEM
- — — — — → ESCAPE ROUTE

REFER TO BLOCK PLAN DRAWING N^o 171/SR/15 FOR THE EVACUATION ASSEMBLY POINT



Project	PROPOSED SINGLE STOREY REAR EXTENSION AND FIRST FLOOR DORMER ABOVE THE BATHROOM 171 SANDYCOMBE ROAD RICHMOND MIDDLESEX TW9 2EN
Drawing Title	FLOOR PLANS WITH FIRE SAFETY FEATURES
Scale	1:50@A3
Date	JULY 2024
Drawing No.	171/SR/14