


Notes:
Do not scale from this drawing. Contractors shall be responsible for the checking of all stated dimensions, with any anomalies being identified to the originator prior to any construction or fabrication works commencing.

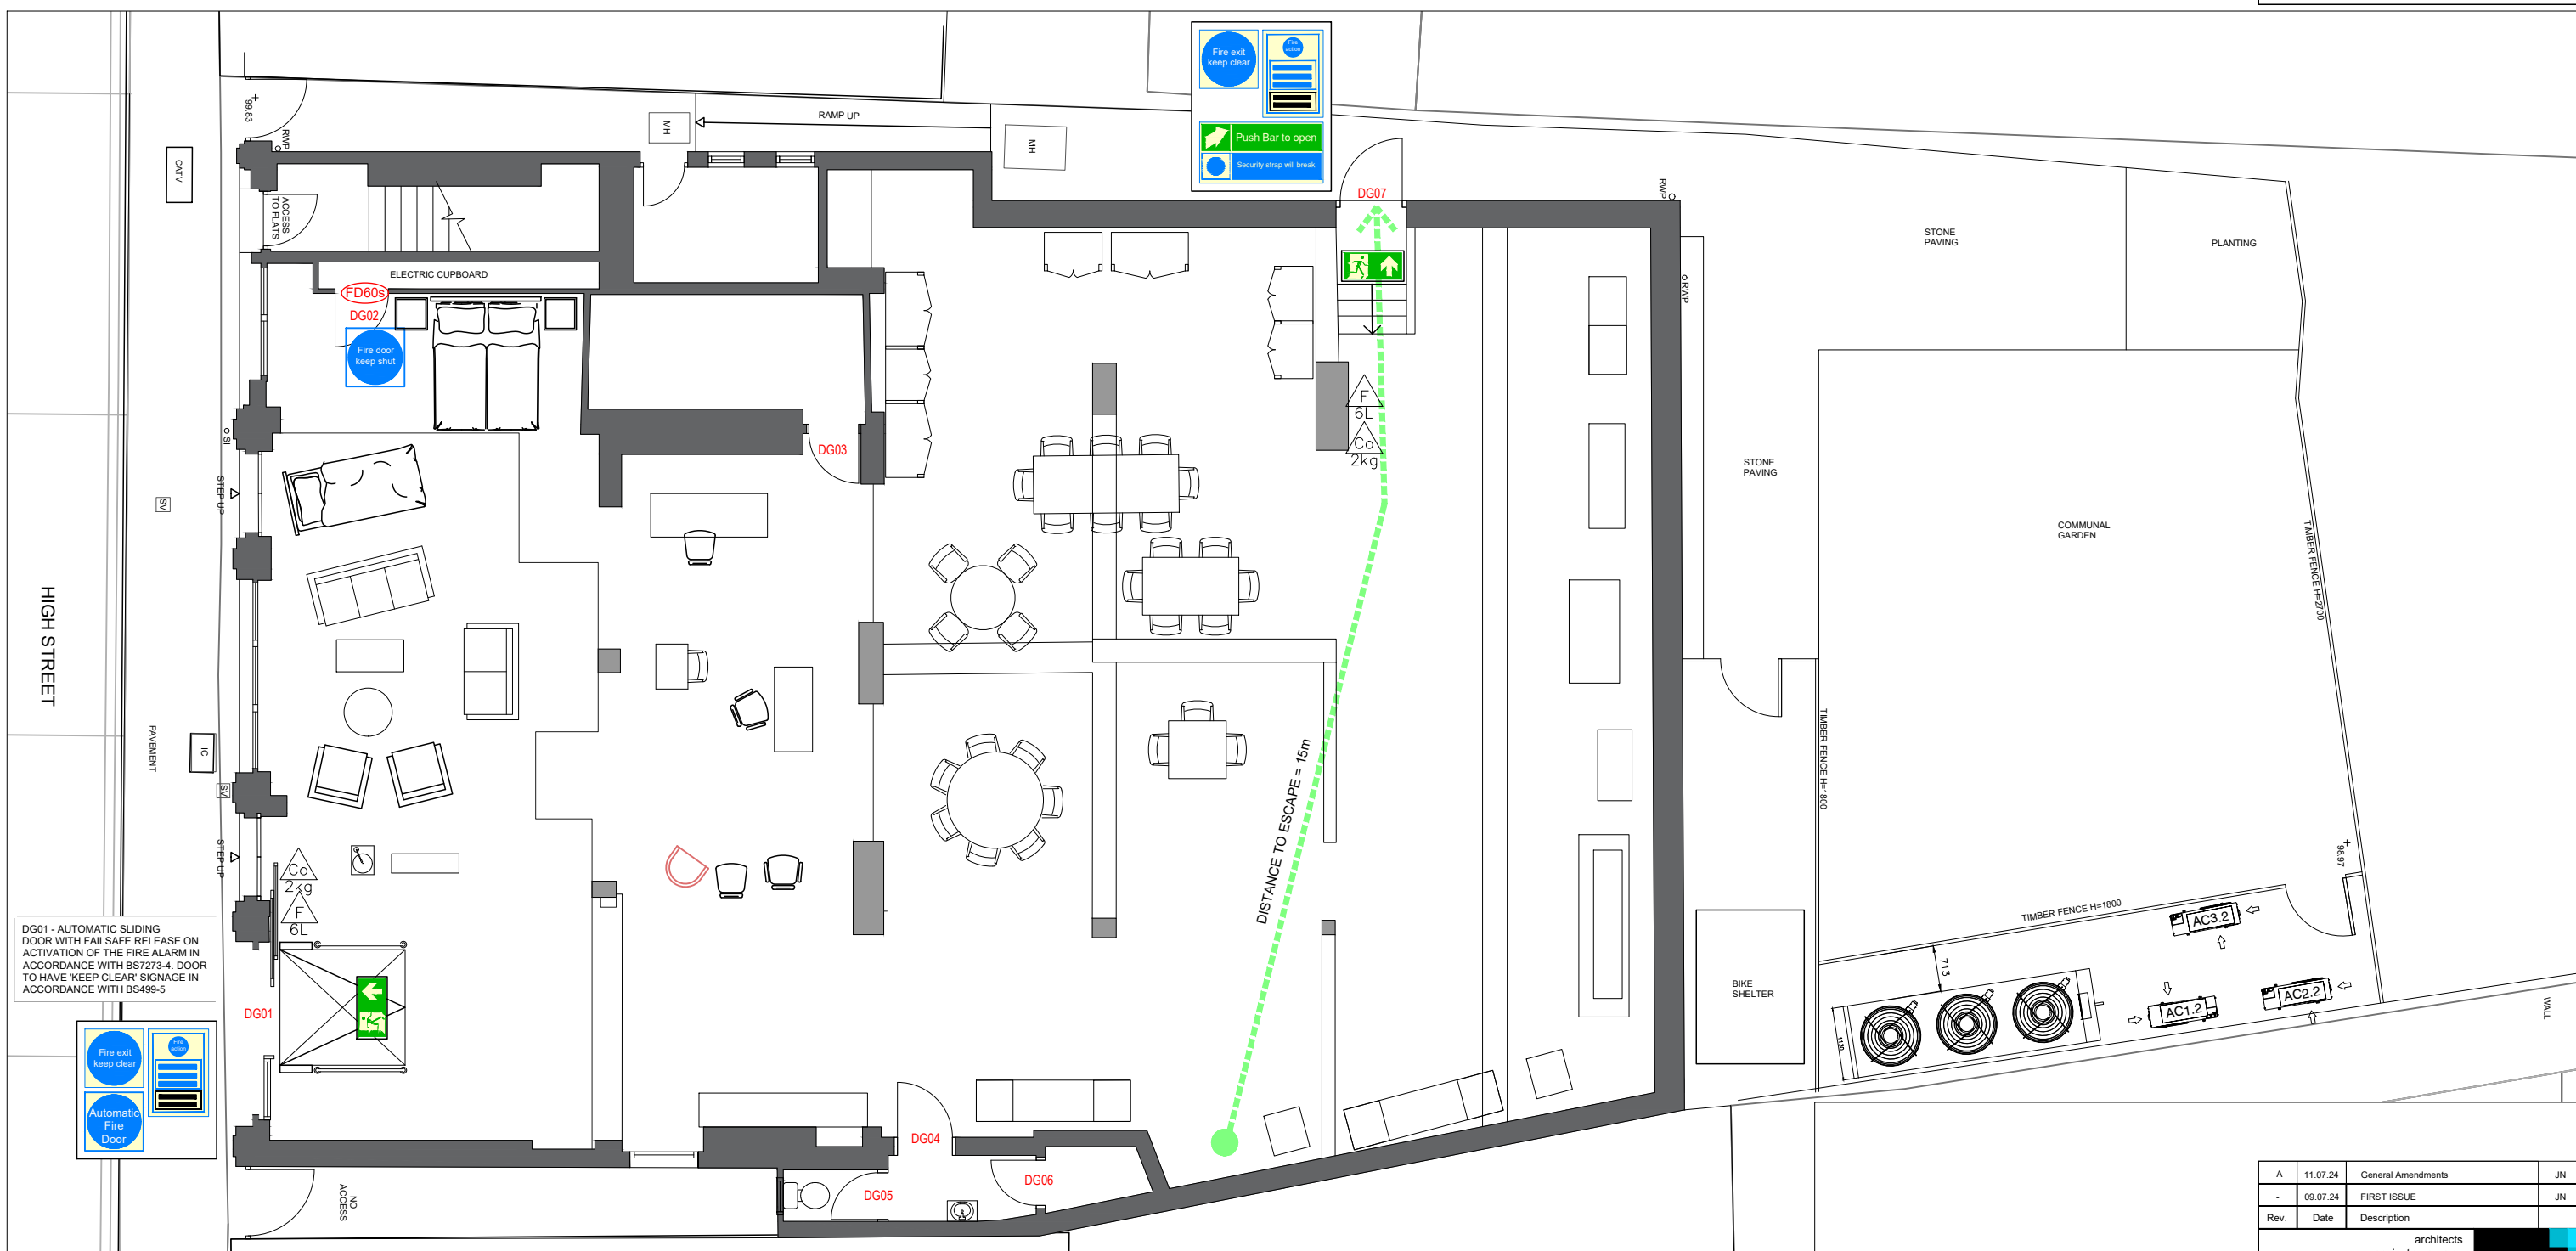

PROPOSED GROUND FLOOR FIRE STRATEGY (1:50@A1)

FIRE SIGNAGE LEGEND

	P50 Fluorine-Free B-Foam Extinguisher 6ltr		Fire Door Keep Shut.
	Extinguisher CO 2kg		Auto Fire Door
	Fire Blanket		Fire Door. Keep Locked Shut.
	Exit sign, arrow up.		Fire exit keep clear
	Exit sign, arrow left.		Fire exit keep clear
	Exit sign, arrow right.		Fire Action Notice

SS - single sided,
DS - double sided hanging

	Push to escape signage
	Security strap will break

PB DOOR PROVIDED WITH PANIC BOLTS
 QL QUICK RELEASE LOCKS
 SCSS SELF CLOSING DOORS FITTED WITH SMOKE SEALS ETC
 FI FIRE INSTRUCTION NOTICE
 MF MANAGEMENT FIRE INSTRUCTION NOTICE
 1 HOUR FIRE DOOR
 HALF HOUR FIRE DOOR
 ONE HOUR FIRE WALL
 TWO HOUR FIRE WALL
 FOUR HOUR FIRE WALL
 FIRE ESCAPE
 RED ROUTE THERMOPLASTIC PAINT ON TERRAZZO FLOOR
 DG** DOOR NUMBER

NOTES - GENERAL

A GROUP FIRE SERVICES APPROVED FIRE ACTION NOTICES TO BE PROVIDED ADJACENT TO EACH FIRE ALARM CALL POINT IN STAFF AREAS ONLY

B A GROUP FIRE SERVICES APPROVED CALL FIRE BRIGADE NOTICE TO BE LOCATED BY AN EXCHANGE TELEPHONE IN THE GENERAL OFFICE

C FIRE EXTINGUISHERS AND FIRE NOTICES TO BE OBTAINED TO CONFIRM BS9241 AND BS5306-10

D PHOTOLUMINESCENT EMERGENCY EXIT SIGNS EEC COMPLY WITH BS 5396, RUNNING MAN STYLE.

E FIRE SIGNAGE TO COMPLY WITH BS 5499 AND FIRE SIGNAGE SPECIFICATION

F L1 FIRE ALARM SYSTEM TO COMPLY WITH BS 5839

G PORTABLE FIRE FIGHTING EQUIPMENT TO COMPLY WITH BS 5306 AND BS5306-10

H SURFACE SPREAD OF FLAME: CIRCULATION AND ESCAPE ROUTE - CLASS 0 LESS THAN 30sqm - CLASS 3 OTHER AREAS GREATER 30sqm - CLASS 1

I ALL DOORS ACROSS ESCAPE ROUTES TO BE EASILY OPENABLE AT ALL MATERIAL TIMES WITHOUT THE USE OF A KEY OR WITHOUT HAVING TO MANIPULATE MORE THAN ONE DEVICE

J ALL FIRE DOORS TO BE FITTED WITH SMOKE SEALS

K ALL COMPARTMENT WALLS TO HAVE 'COMPARTMENT WALL' NOTICES FITTED

L ALL EMERGENCY LIGHTING, FIRE ALARM INSTALLATION AND RELATED DETAILS IN ACCORDANCE WITH ENGINEERS DETAILS.

SALES AREA

TOTAL OCCUPANCY-	90 PEOPLE BASED ON 4sqm PER PERSON (TOTAL AREA- 287 sqm)
MAXIMUM TRAVEL DISTANCE -	15m
MAXIMUM PERMITTED TRAVEL DISTANCE-	45.0m

OFFICE

TOTAL OCCUPANCY-	1 PERSON BASED ON 30sqm PER PERSON (TOTAL AREA - 8 sqm)
MAXIMUM TRAVEL DISTANCE -	17 m
MAXIMUM PERMITTED TRAVEL DISTANCE-	45.0m

STAFF TOILET AND STORE

TOTAL OCCUPANCY-	1 PERSON BASED ON 30sqm PER PERSON (TOTAL AREA - 5 sqm)
MAXIMUM TRAVEL DISTANCE -	15 m
MAXIMUM PERMITTED TRAVEL DISTANCE-	45.0m

Rev.	Date	Description	
A	11.07.24	General Amendments	JN
-	09.07.24	FIRST ISSUE	JN

architects
 project managers
 cost consultants
2nd Floor
 13 Swan Yard
 Islington, London
 N1 1SD
 tel: 0203 637 8980



Status **CONSTRUCTION**

PAINTED FURNITURE COMPANY

Project Title
**PAINTED FURNITURE COMPANY
 HAMPTON WICK
 59-61 HIGH STREET, KT1 4DG**

Drawing Title
**PROPOSED GROUND FLOOR
 FIRE STRATEGY
 SITE REF: -118165**

Project Number B-118165	Drawing Number 610	Revision A
----------------------------	-----------------------	---------------

Drawn JN	Checked VA	Scale 1:50@A1	Date 09.07.24
-------------	---------------	------------------	------------------

JLA Architects is a trading name of Company Ref OC315061 registered in England and Wales Registered Office: Euro House, 1394 High Road, London N20 9YZ. Any reproduction of all or any part of this drawing without formal consent of the copyright owner, Company Ref: OC315061, is prohibited. The content of this drawing is the property of the Company Ref OC315061.