

A 01 EXISTING GROUND FLOOR PLAN scale: 1:100



A 01 PROPOSED GROUND FLOOR PLAN scale: 1:100



A 01 PROPOSED VIEW scale:



A 01 PROPOSED VIEW scale:

LEGEND	
	Area less than 1.800 standing head height

KEY NOTES, FIRE SAFETY	
	Escape route
	Smoke detector
	Heat detector
	1/2 Half hour fire door
	Assembly Point




A 01 EXISTING FIRST FLOOR PLAN scale: 1:100



A 01 PROPOSED FIRST FLOOR PLAN scale: 1:100



A 01 PROPOSED SECOND FLOOR PLAN scale: 1:50

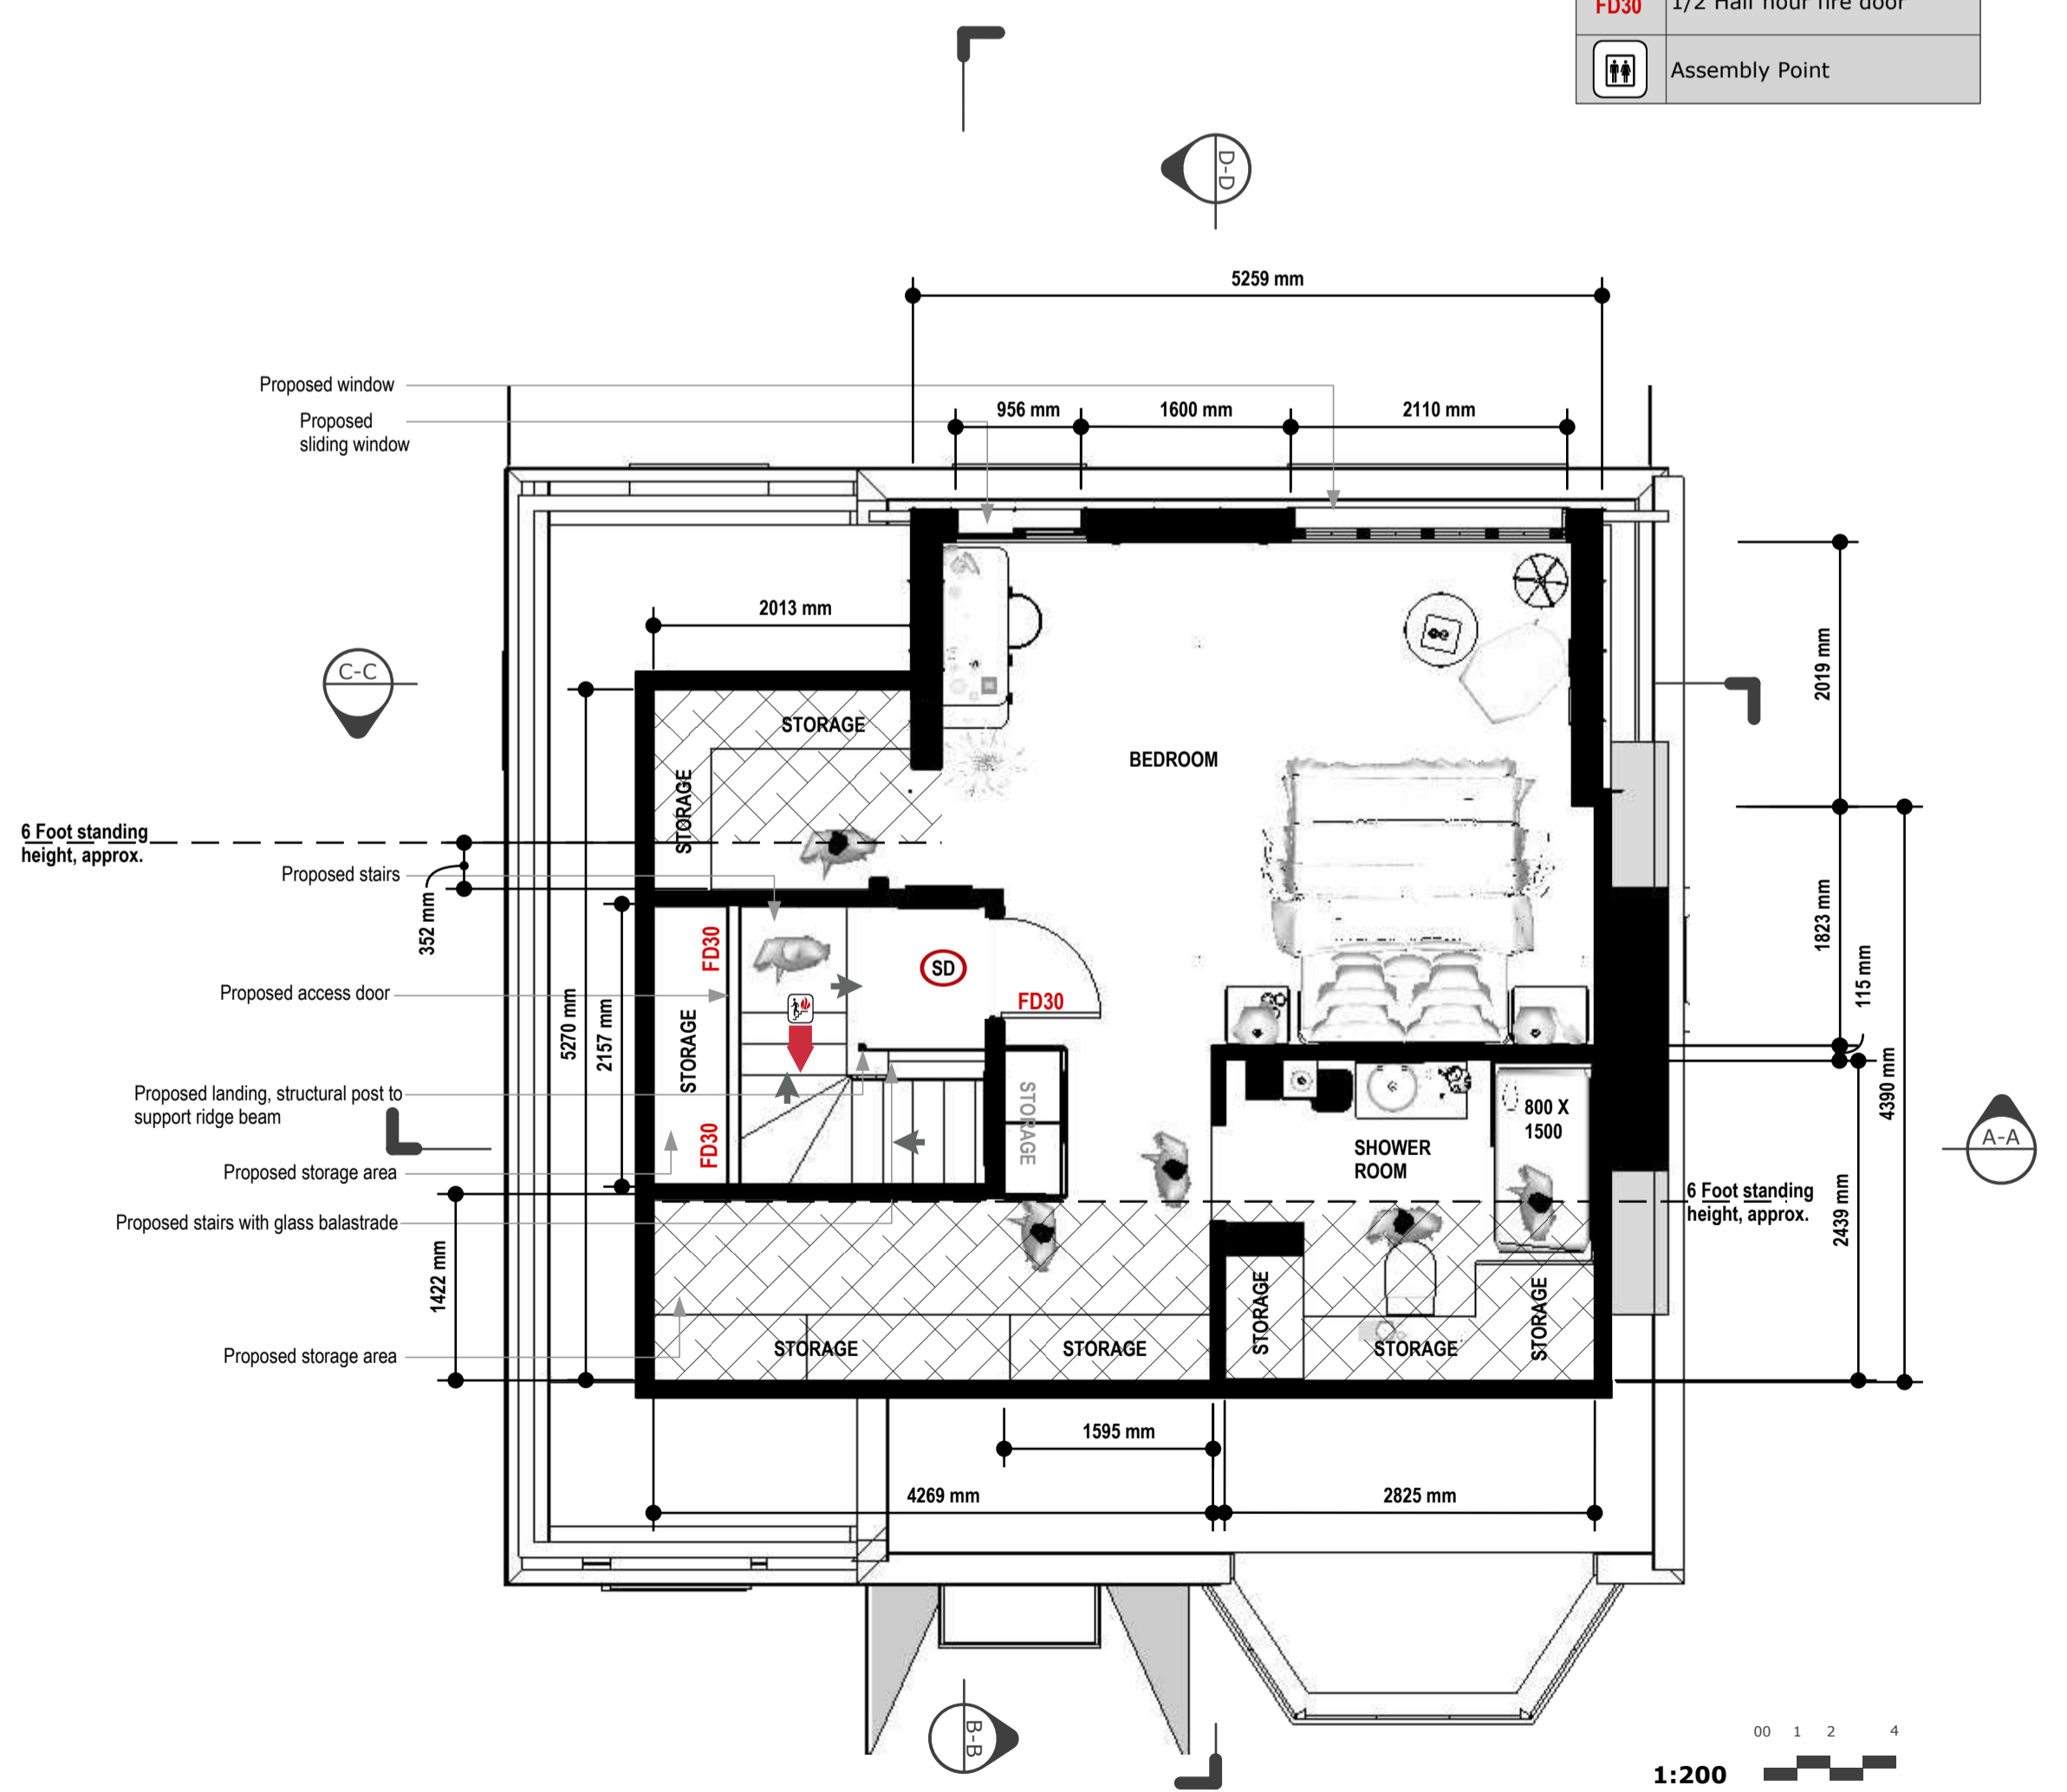

A 01 PROPOSED SECOND FLOOR PLAN scale: 1:50



COORDINATION	
	Preliminary Design
	Planning / LDC Submitted
	Planning / LDC Granted
	Building Upgrade
	Building Control Sing off
	Thames Water