



A 01 EXISTING GROUND FLOOR PLAN scale: 1:100



A 01 PROPOSED GROUND FLOOR PLAN scale: 1:100



A 01 PROPOSED VIEW scale:



A 01 PROPOSED VIEW scale:




A 01 EXISTING FIRST FLOOR PLAN scale: 1:100



A 01 PROPOSED FIRST FLOOR PLAN scale: 1:100



A 01 PROPOSED SECOND FLOOR PLAN scale: 1:50

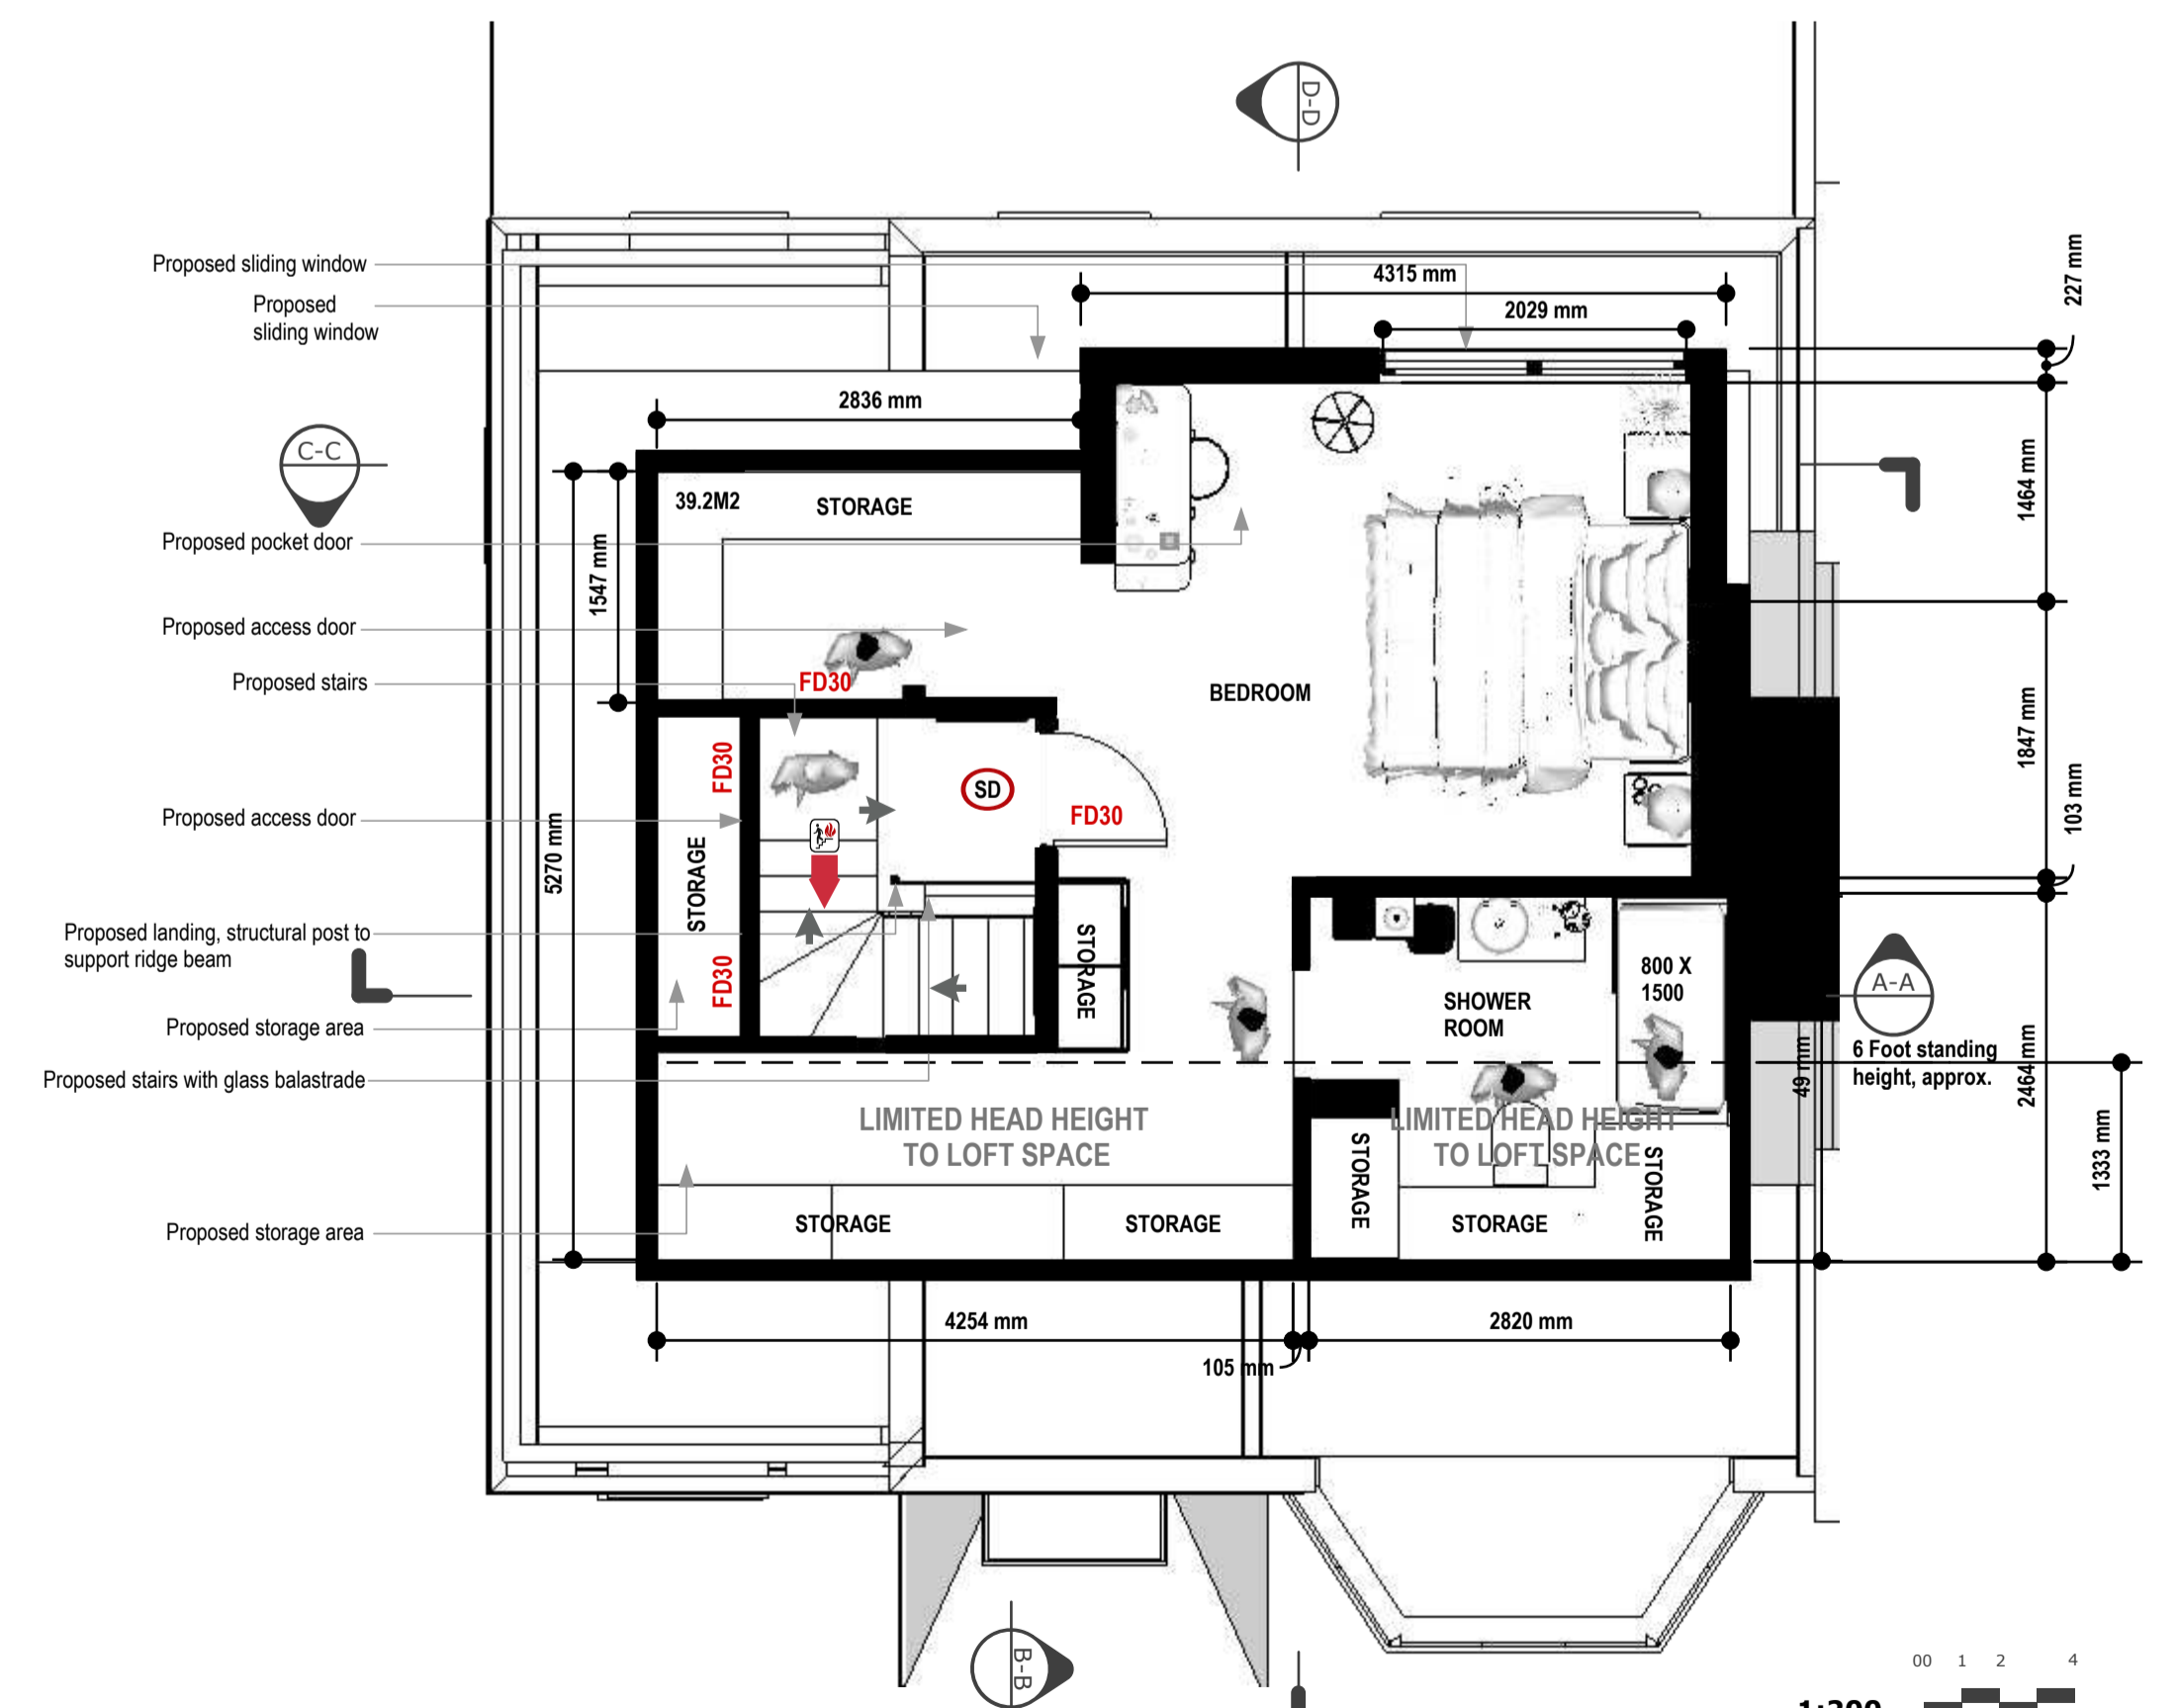

A 01 PROPOSED SECOND FLOOR PLAN scale: 1:50

KEY	NOTES, FIRE SAFETY
	Escape route
	Smoke detector
	Heat detector
	1/2 Half hour fire door
	Assembly Point

COORDINATION	
	Preliminary Design
	LDC Submitted
	Planning LDC Granted
	Building Upgrade
	Building Control Sign off
	Thames Water