


Pre- Existing CCTV Cameras	
Ref. I.D	Type
1	PTZ.Cam (Pan,Tilt & Zoom)
2	F.Cam (Fixed View Cam)
3	PTZ.Cam (Pan,Tilt & Zoom)
4	F.Cam (Fixed View Cam)
5	F.Cam (Fixed View Cam)
6	F.Cam (Fixed River View Cam)
7	F.Cam (Fixed River View Cam)

Cameras Installed in 2012	
Ref. I.D	Type
8	F.Cam (Fixed View Cam)
9	F.Cam (Fixed View Cam)
10	F.Cam (Fixed View Cam)

Proposed Additional Cameras	
Ref. I.D	Type
11	F.Cam (Fixed View Cam)
12	F.Cam (Fixed View Cam)

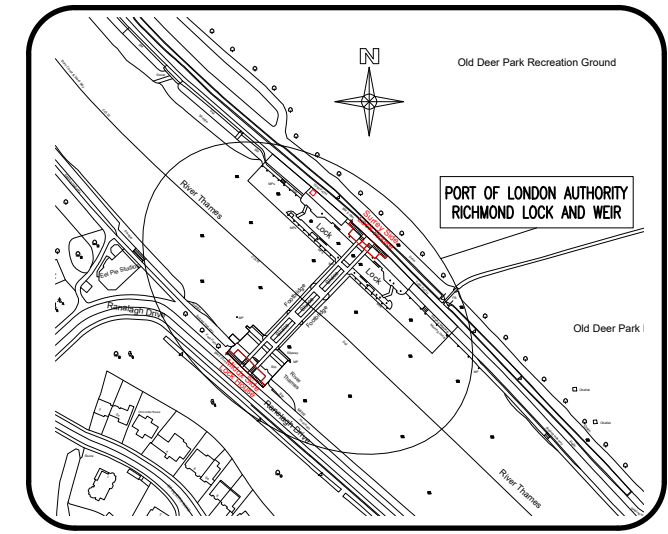

LOCATION PLAN
Scale 1:2500

Rev	Description	By	Date

PORT OF LONDON AUTHORITY

CIVIL ENGINEERING DEPARTMENT
 London River House
 Royal Pier Road
 Gravesend
 Kent DA12 2BG
 Telephone 01474 562250
 Facsimile 01474 562277
 E-Mail: CivEng@pla.co.uk
 Web site: www.pla.co.uk

Location
RICHMOND LOCK & WEIR
 RICHMOND
 SURREY

Drawing Title
FACILITY LOCATION
FACILITY SITE PLAN SHOWING
EXISTING & PROPOSED CCTV
LOCATIONS & COVERAGE

Date	Scale	Drawn	Engineer
Apr/2014	As Shown	LW	S.Strickland

Drawing Number
RLW/C/1024 - B