

FIRE KEY	
KEY	DESCRIPTION
FAIP	FIRE ALARM PANEL
H	HEAT DETECTOR HEAD
S	SMOKE DETECTOR HEAD
FE	ILLUMINATED RUNNING MAN
S	INTERNAL SOUNDER
SAB	EXTERNAL SOUNDER
SP	SPRINKLER HEAD


FIRE ALARM SYSTEM TO BE COMPLIANT WITH BS 5839-1:2017. ALARM SOUNDERS TO PROVIDE A MINIMUM OF 65DB IN ALL AREAS. FIRE SAFETY / EXIT SIGNAGE TO COMPLY WITH BS EN ISO 7010, BS5499-4 2013, BS5266-1:2016

CEILING KEY	
KEY	DESCRIPTION
L1	24W ALEDA ADJUSTABLE DOWNLIGHTER (HACEL)
L2	22W SOLEDO DOWNLIGHTER (HACEL)
L3	22W SOLEDO DOWNLIGHTER EM PACK (HACEL)
L4	SOLOS WALL LIGHT (HACEL)
L5	SOLOS WALL LIGHT EM PACK (HACEL)
L6	8W SOLEDO DOWNLIGHTER (HACEL)
L7	8W SOLEDO DOWNLIGHTER EM PACK (HACEL)
L8	SKYMOD WAFER GRID (HACEL)
L9	SKYMOD WAFER GRID EM PACK (HACEL)
SPK	SPEAKER
LB	LED BATONS
LP	LED PANELS

LIGHTING FINISH TO MATCH CEILING FINISH - PLEASE REFER TO STAMP FINISHES SCHEDULE

M+E KEY	
KEY	DESCRIPTION
CC	LARGE CEILING MOUNTED CASSETTE
SC	SMALL CEILING MOUNTED CASSETTE
WC	WALL MOUNTED CASSETTE

FINISH TO MATCH CEILING FINISH WHERE POSSIBLE - PLEASE REFER TO STAMP FINISHES SCHEDULE

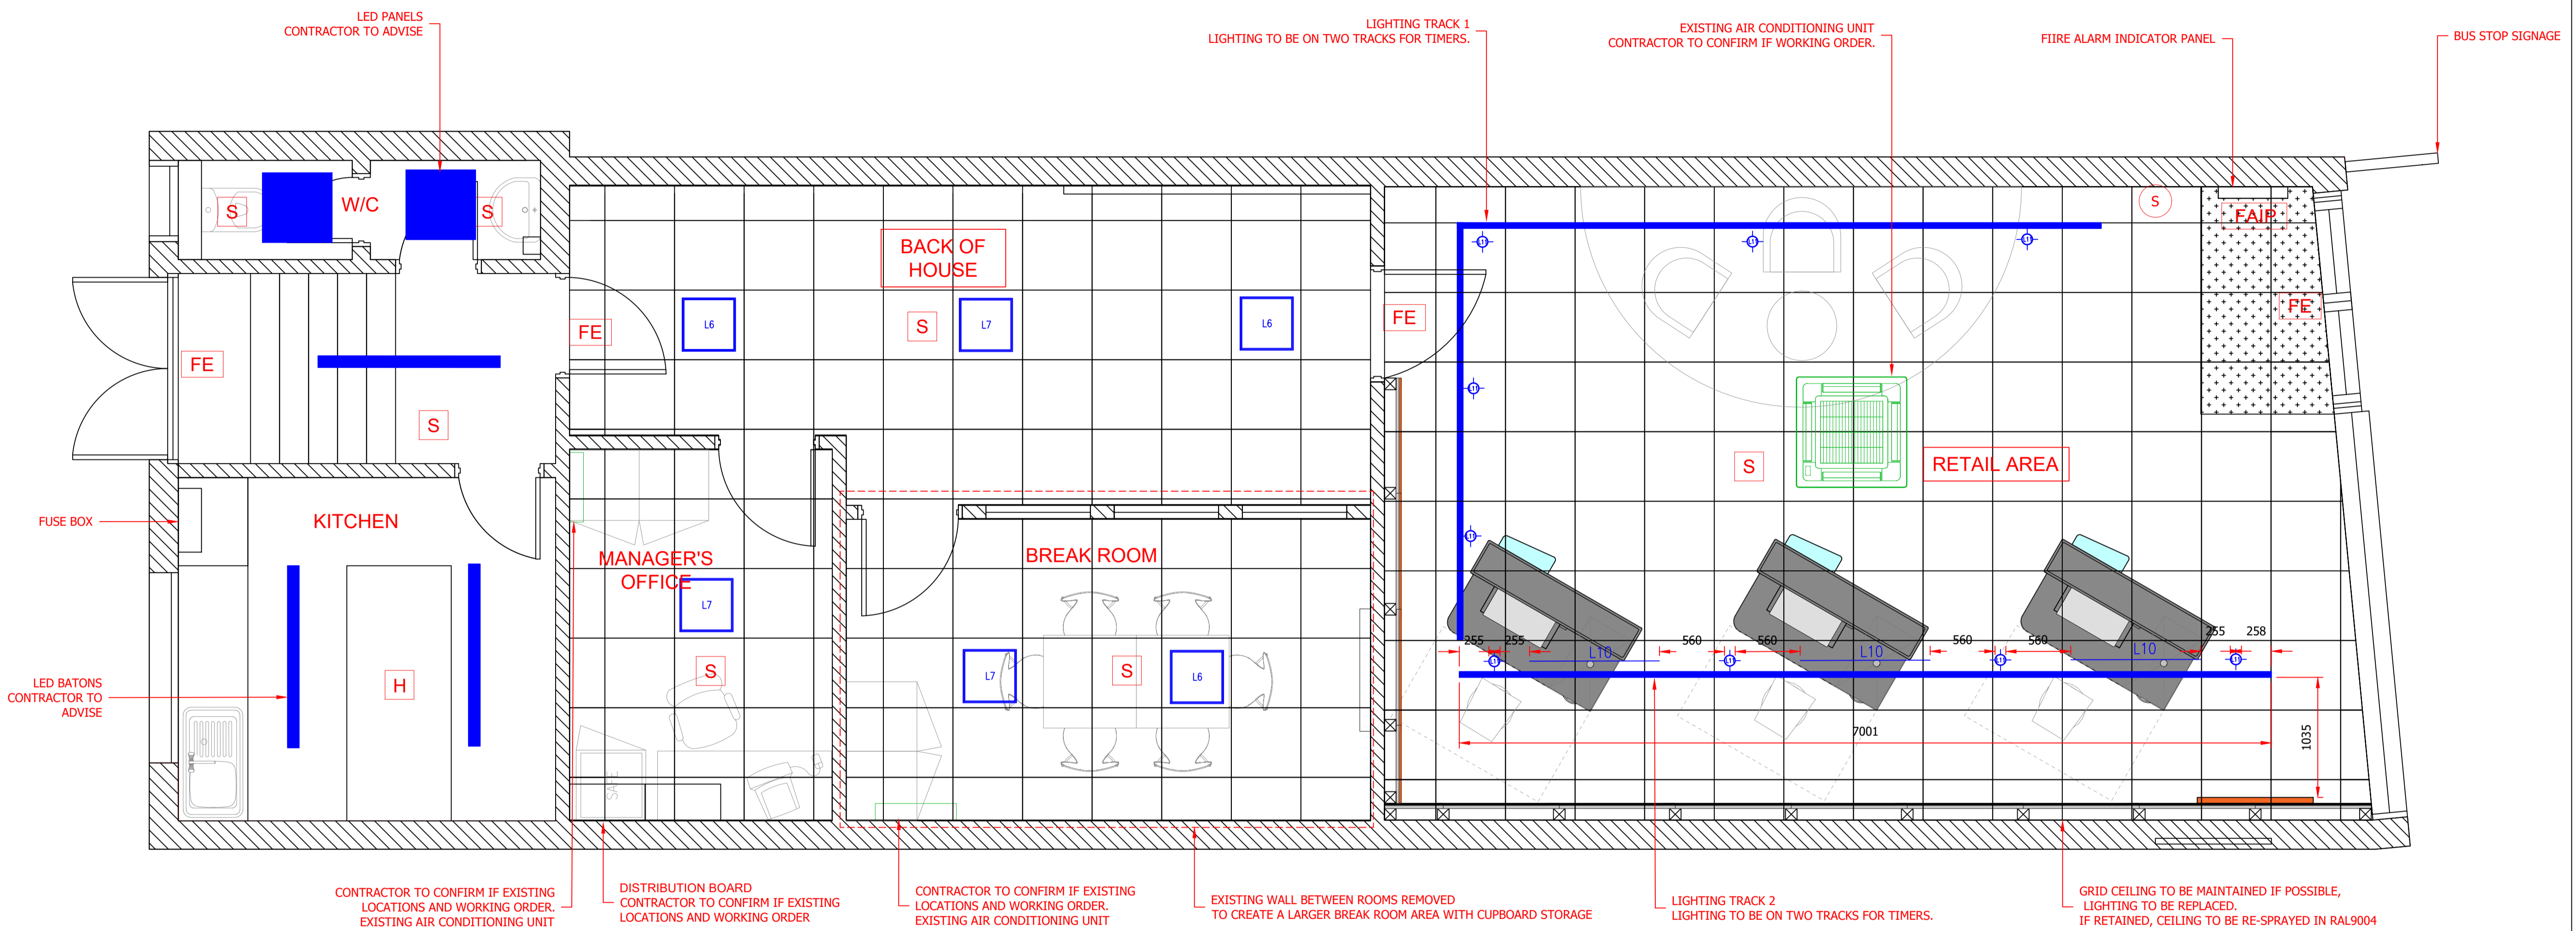

STAMP

123A BOROUGH HIGH STREET
LONDON
SE1 1NP
WWW.STAMPDESIGN.CO.UK

SixT

1 QUADRANT HOUSE, 25
THE QUADRANT
RICHMOND TW9 1DJ

TITLE	REFLECTED CEILING PLAN
SCALE	1:30 @ A1
DRAWN BY	DRAWING NO.
LB	STA.SIXT.RICHMOND.FEAS00

ISSUE RECORD		
A	FIRST ISSUE	26/11/24
B	SECOND ISSUE	05/12/24

PLEASE NOTE:

- PRINCIPLE CONTRACTOR TO ENSURE FIRE EXIT SIGNAGE ARE EDGE-LIT GLASS & THAT THE SIGN SERVING IN THE MAIN ENTRANCE DOORS SHOWS ONLY THE DIRECTION OF ESCAPE FROM THE UNIT INTO THE CAR PARK AND THE REVERSE SIDE OF THE SIGN, AS SEEN FROM THE CAR PARK, IS BLANK.
- EMERGENCY LIGHTS TO HAVE 3-HOUR BATTERY POWERED AND INTEGRAL TO NORMAL LIGHT FITTINGS. BULKHEAD EMERGENCY LIGHTS IN SALES AREA ARE NOT PERMITTED.
- PROVISION OF ESCAPE LIGHTING TO BS5266 - EMERGENCY LIGHTING, PART 1: 2005. LIGHT LEVELS TO BE DEMONSTRATED TO SITE TO AN OFFICER OF THIS AUTHORITY.
- LIGHTING AND ILLUMINATED SIGNAGE IN THE SHOP & SHOP FRONT IS ON A TIMER TO KEEP LIGHTS ON DURING THE FOLLOWING MINIMUM PERIOD: MONDAY - SUNDAY 7:00 - 22:00 HRS.

FOR DESIGN INTENT ONLY.

BUILDER AND / OR SUB-CONTRACTORS SHALL VERIFY ALL PROJECT DIMENSIONS BEFORE COMMENCING ON-SITE OR OFF-SITE FABRICATIONS FIGURED DIMENSIONS SHALL TAKE PRECEDENCE OVER SCALED DIMENSIONS. THIS DRAWING IS COPYRIGHT AND CANNOT BE REPRODUCED IN WHOLE OR IN PART OR BY ANY MEDIUM WITHOUT THE WRITTEN PERMISSION OF STAMP DESIGN. NO WARRANTY IS OFFERED OR IMPLIED ON THE CONTENT OF THESE DRAWINGS. CLIENT AND CONTRACTOR SHOULD SATISFY THEMSELVES THAT THE DESIGN INTENT AS INDICATED IS SUITABLE IN TERMS OF FUNCTION AND FEASIBILITY. GUIDANCE SHOULD BE SOUGHT FROM THE LANDLORDS RETAINED ARCHITECT, STRUCTURAL ENGINEERS AND PROJECT TEAM AS TO THE FEASIBILITY OF DESIGN INTENT CONTAINED HEREIN. THE LANDLORDS AGENTS WILL BE RESPONSIBLE IN ALL CASES FOR ENSURING ADEQUATE PROVISION OF DESIGN INFORMATION, AND SIGN OFF OF DESIGN INTENT HEREIN. NO STRUCTURAL DESIGN HAS TAKEN PLACE. SHOULD STRUCTURAL DESIGN BE REQUIRED, THIS MUST BE COMMISSIONED AND SIGNED OFF BY AN INDEPENDENT STRUCTURAL ENGINEER IN ALL CASES. NO GUIDANCE OR WARRANTY AS TO THE STRUCTURAL SUITABILITY OF ANY WORK CONTAINED HEREIN IS OFFERED OR IMPLIED. **IF IN DOUBT, ASK!**