

REV	DATE	DESCRIPTION




Collingwood adjustable wall spot light, 5.7w, 240v, w/white, LED, to have bronze finish



LuxR LED Micro recessed step light, Stainless steel, 1w, 350mA, 1 aperture



LuxR LED Micro recessed step light, Stainless steel, 1w, 350mA, 3 apertures


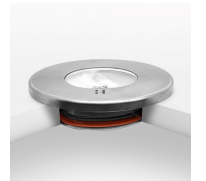


4 No. Hunza Pure LED Slim Precessed round uplighters with canister, s/steel, 2w, 700mA, w/white



L310 : LuxR modux 1 spike spot with glare guard

 Electrics box for light fixtures

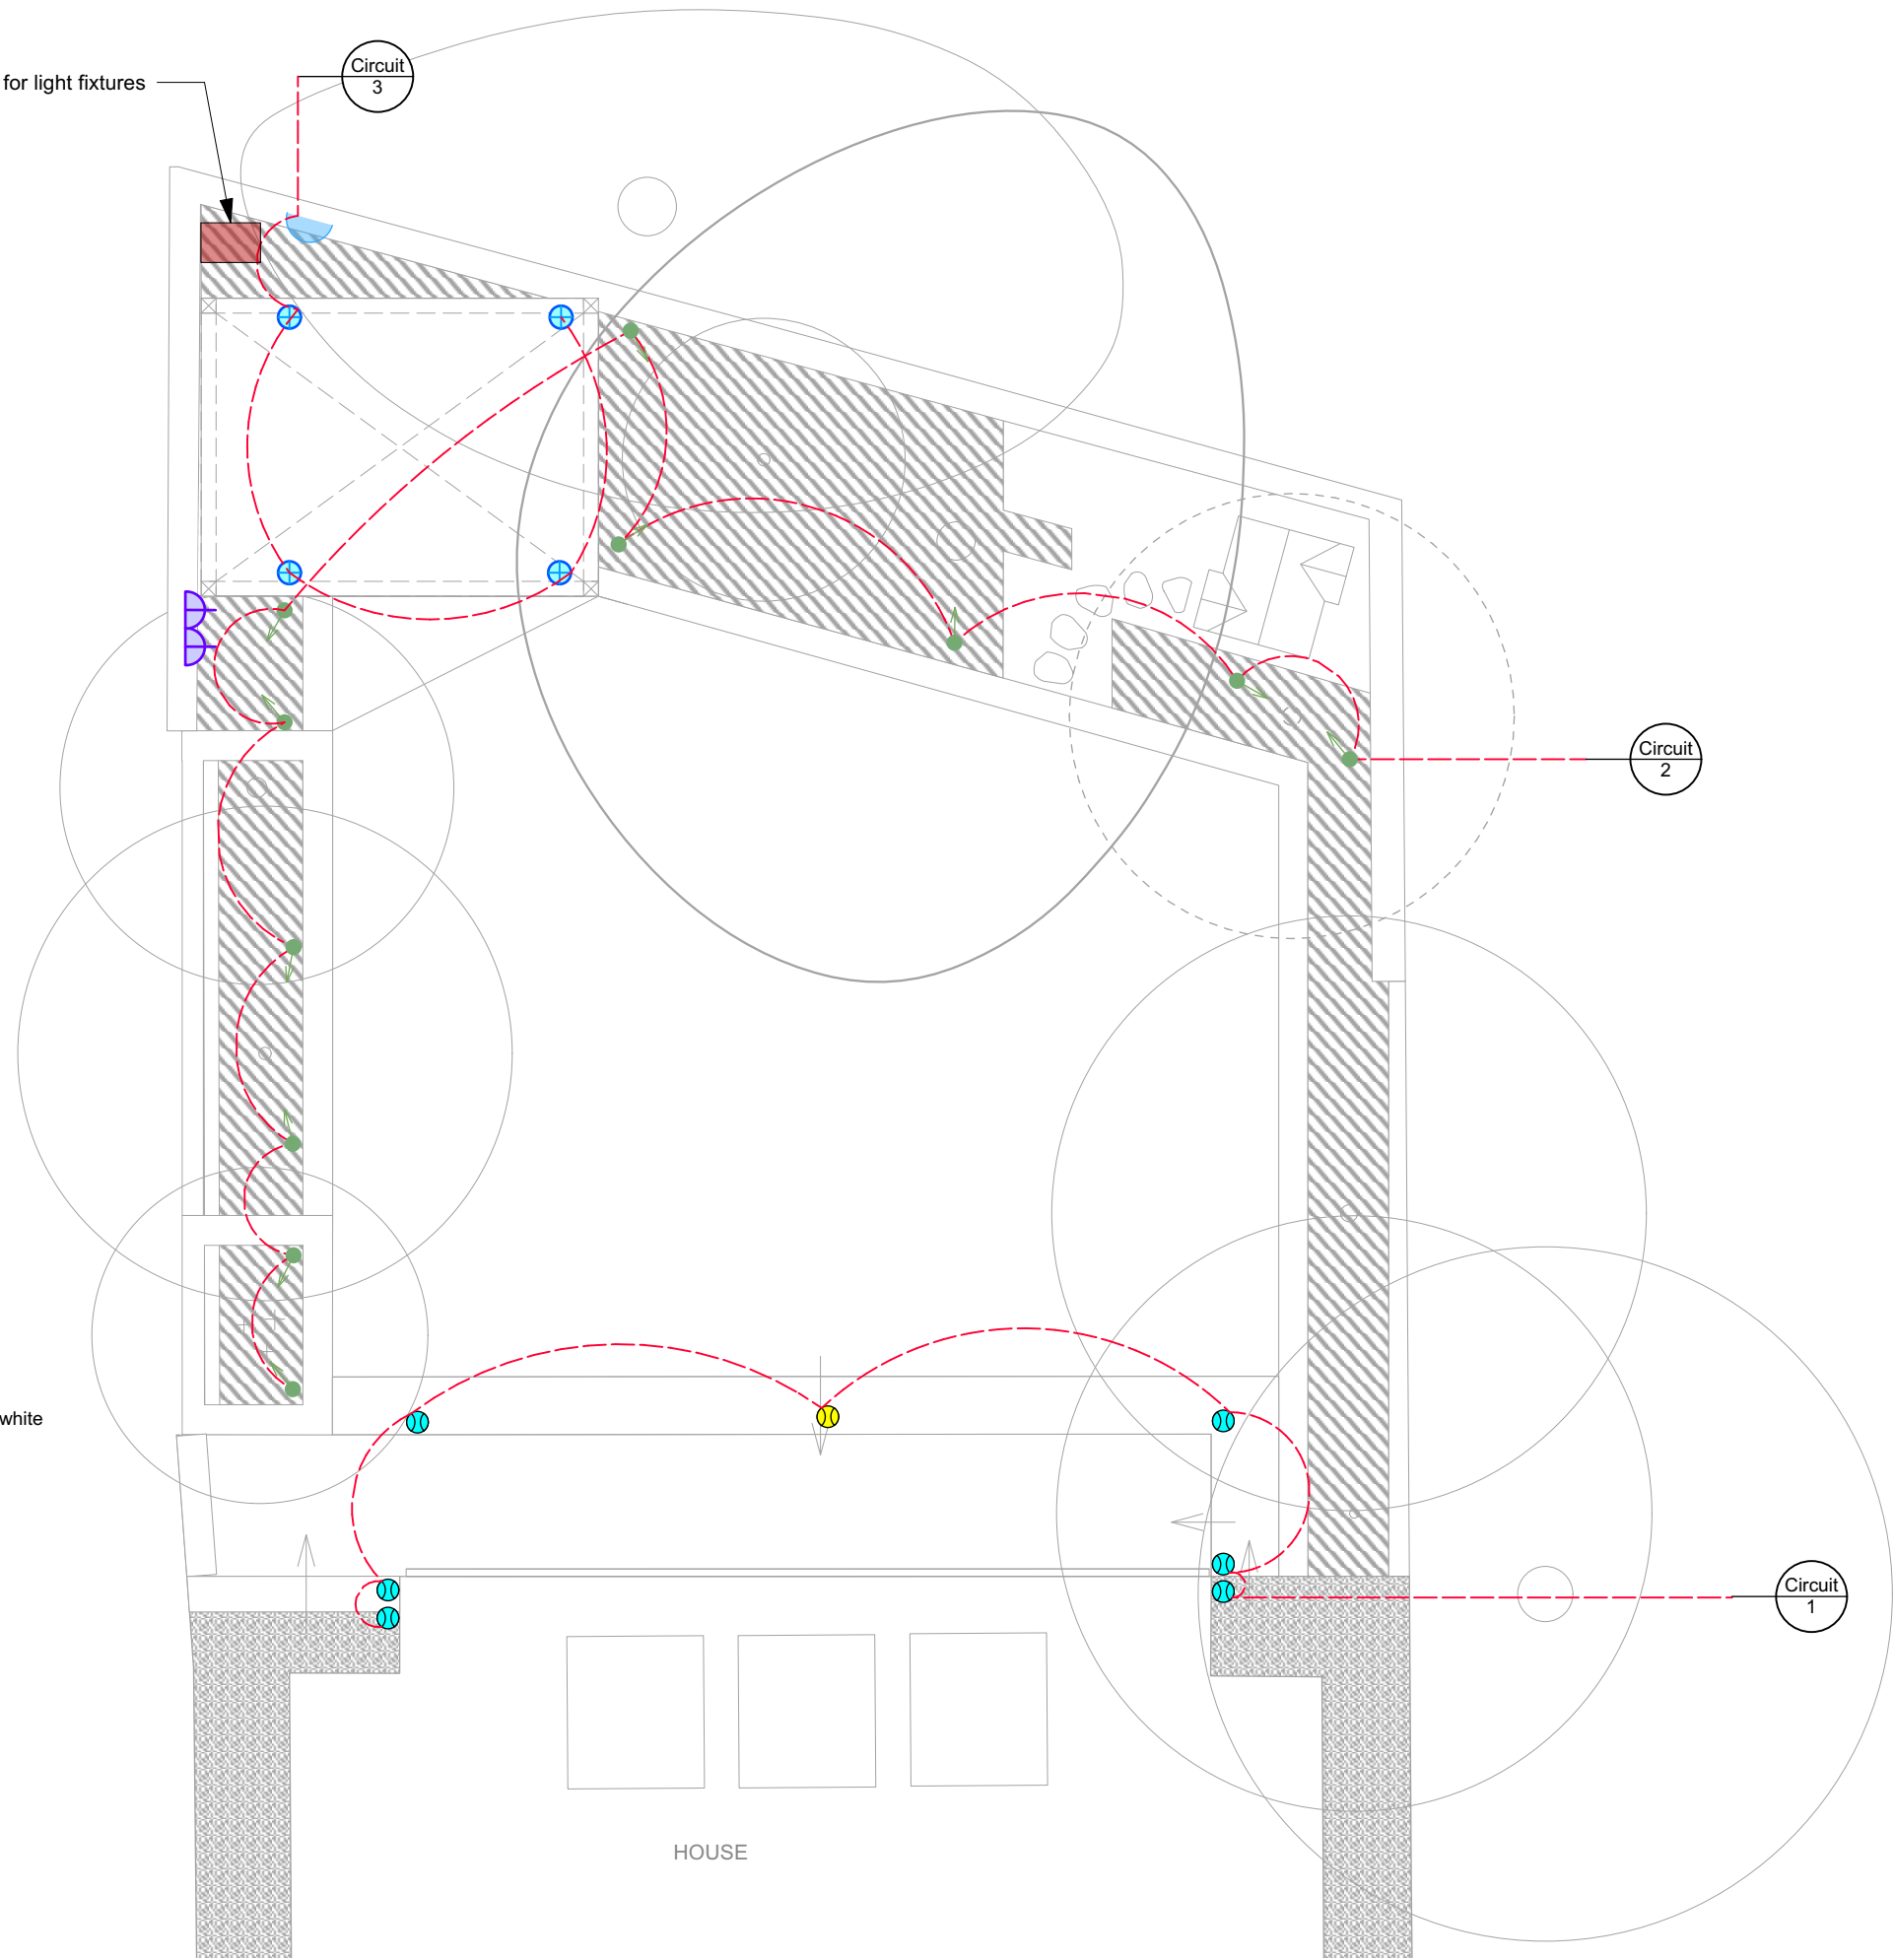

- 1 No. Collingwood adjustable wall spot light, bronze finish, 5.7w, 240v, w/white, LED
- 6 No. LuxR LED Micro recessed step light, stainless steel, 1w, 350mA, 1 aperture, w/white
- 1 No. LuxR LED Micro recessed step light, stainless steel, 1w, 350mA, 3 apertures, w/white
- 11 No. LuxR modux one spike spot, 1w, w/white, black powder coated, with glare guard
- 4 No. Hunza Pure LED Slim Precessed round uplighters with canister, s/steel, 2w, 700mA, w/white
- 1 No. Double outdoor sockets (TBC)
- 3 No. circuits on remote control system (system to be discussed with client)

- Step lights**
- 6 No. LuxR LED Micro recessed step lights 180 degrees
- 1 No. LuxR LED Micro recessed step lights 360 degrees

- Tree lights**
- 6 No. Collingwood SL220 LED spike lights

- Gazebo & surrounds lighting**
- 1 No. Collingwood adjustable wall spot light



ROSEBANK

Studio G23, The Light Box, 111 Power Road,
Chiswick W4 5PY
+44 (0)203 876 5299
info@rosebanklandscaping.co.uk

Project	44 Kings Road, Richmond		
Client	Kirill Voronin		
Drg title	Rear Garden lighting plan		
Drg No.	PA.09		
Scale	1:75 @ A3		
Status	Stage 4	Issue Date	09/12/2024
Drawn	TD	Checked	NL

Unless otherwise specified all DIMs in mm. All DIMs must be checked on site. Do not scale from this drawing

1 **Rear garden lighting plan**
Scale: 1:75