
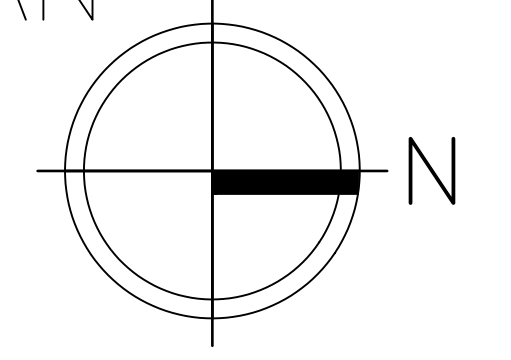


- LEGEND**
- FIRE ESCAPE ROUTE
  - CP FIRE ALARM CALL POINT
  - CO2 FIRE EXTINGUISHER
  - WATER FIRE EXTINGUISHER
  - 1/2 HOUR FD30S FIRE DOOR
  - 1/2 HOUR FIRE WALL
  - EMERGENCY LIGHTING
  - FIRE ALARM CONTROL
  - ILLUMINATED FIRE EXIT SIGNS
  - SMOKE DETECTORS

ROOF PLAN

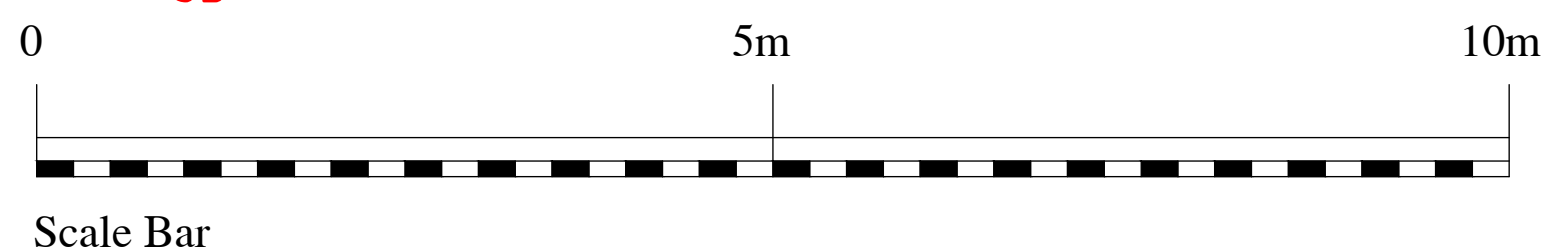

Revisions

New Aluminum Standing Seam Roof

**Note**  
Do not scale from this drawing. All dimensions to be checked on site. Report any discrepancies to the Architect. The property of this drawing is vested in Barnsley Hewett & Mallinson Ltd and must not be copied or reproduced in any way without their written consent. © BHM Architects Ltd

<b>2949 A100</b>	<b>P1</b>	Sheet No.	<p><b>Barnsley Hewett &amp; Mallinson</b> Unit P04, Old Power Station, 121 Mortlake High Street, London, SW14 8SN Tel: 0208 878 4967 E-mail: mail@bhmarshitects.com Web: www.bhmarchitects.com</p>
Project	ST MICHAEL'S CHURCH HALL 39 ELM BANK GARDEN, SW13 0NX	Scale	
Date	2024-12	Drawn by	
Document type	FIRE SAFETY STRATEGY	Approved by	
Title	GF AND ROOF PLAN	DLB	