



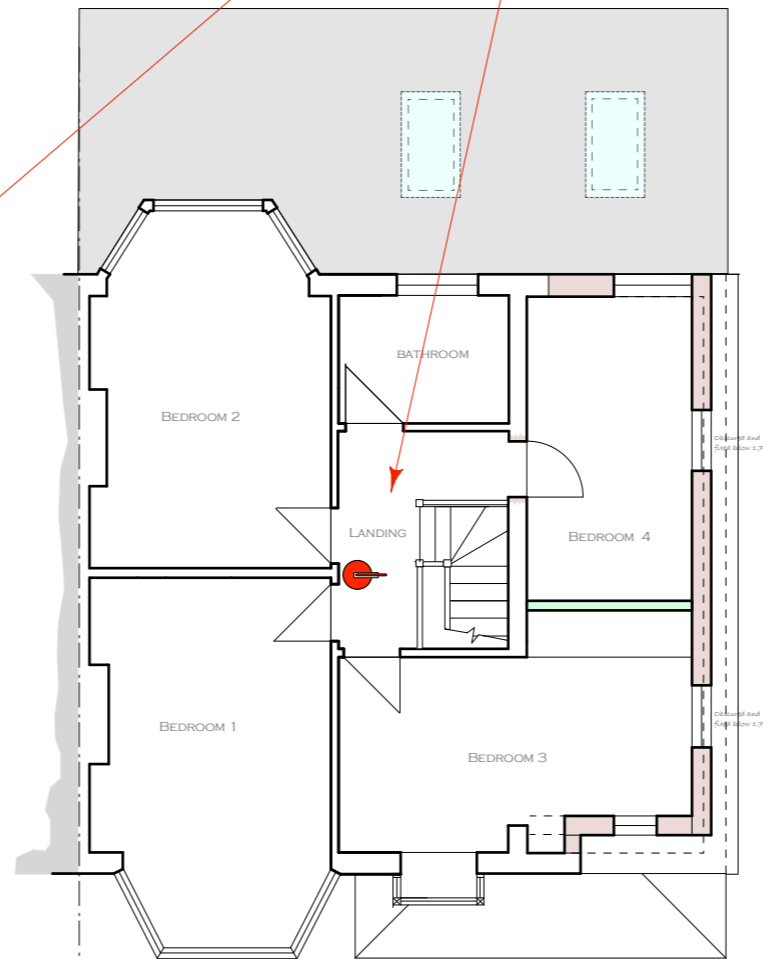

Smoke Heat & Carbon Monoxide Detectors Set out as Stated in the Approved Documents throughout the house and interlinked.

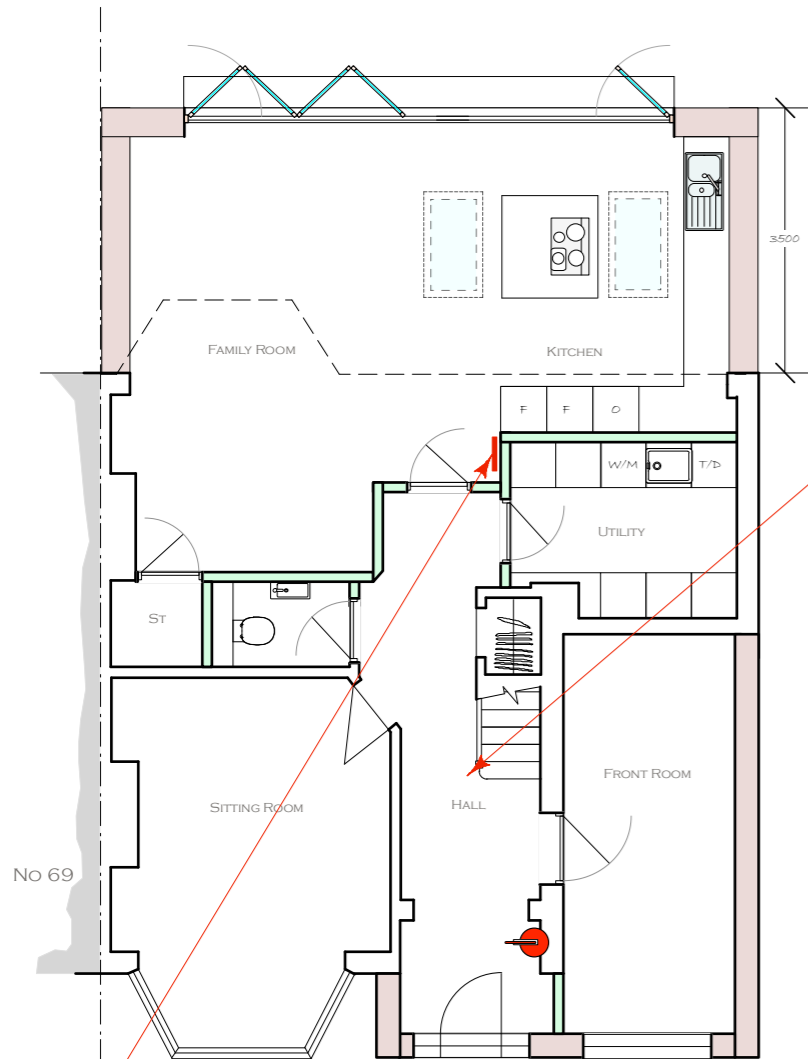

FIRST FLOOR PLAN



Fire Blanket in the Kitchen.



Fire Extinguishers

FIRE EXTINGUISHER GRADES:

- Class A:** will put out fires fuelled by standard combustible materials, such as wood
 - Class B:** designed for use on flammable liquids such as oil or grease
 - Class C:** only suitable for electrical fires
 - Class D:** designed for use on flammable metals
- Many fire extinguishers serve multiple purposes, so come under several class brackets. For example, you might see extinguisher models labelled as AB, BC or ABC.

A dry Foam Fire extinguisher will put out AB&C



rev :	date :	description :
title : FIRE SAFETY EQUIPMENT FLOOR PLANS		
site : 71 CYPRESS AVE WHITTON TW2 7JY		
Franklyn Nevard Associates Telephone : 01473 372 382 (m) 07515 351 894 Architecture & Interior Design e-mail : franklyn@franklynnevard.co.uk Thurland, Sulleys Hill, Lower Raydon, Ipswich, Suffolk, IP7 5QQ		
sheet size : A3	scale : 1:100	date : Nov 24 drawing No : 2141/3/FS13 rev :

